



ADDENDUM

Addendum Number: 001
Project: Community Hospital MOB 1 PET/CT Remodel
Project Number: 257406.00
Date: March 2, 2026

The following items are included as part of this addendum:

SPECIFICATIONS

NONE

DRAWINGS

0 - GENERAL

- NONE

5 - ARCHITECTURAL

- NONE

8 - STRUCTURAL

- NONE

9 - MECHANICAL

- NONE


10 - PLUMBING

- MEDICAL GAS
 - Add N2O medical gas to room CT B1053 per attached sketch

11 - ELECTRICAL

- NONE

End of Addendum

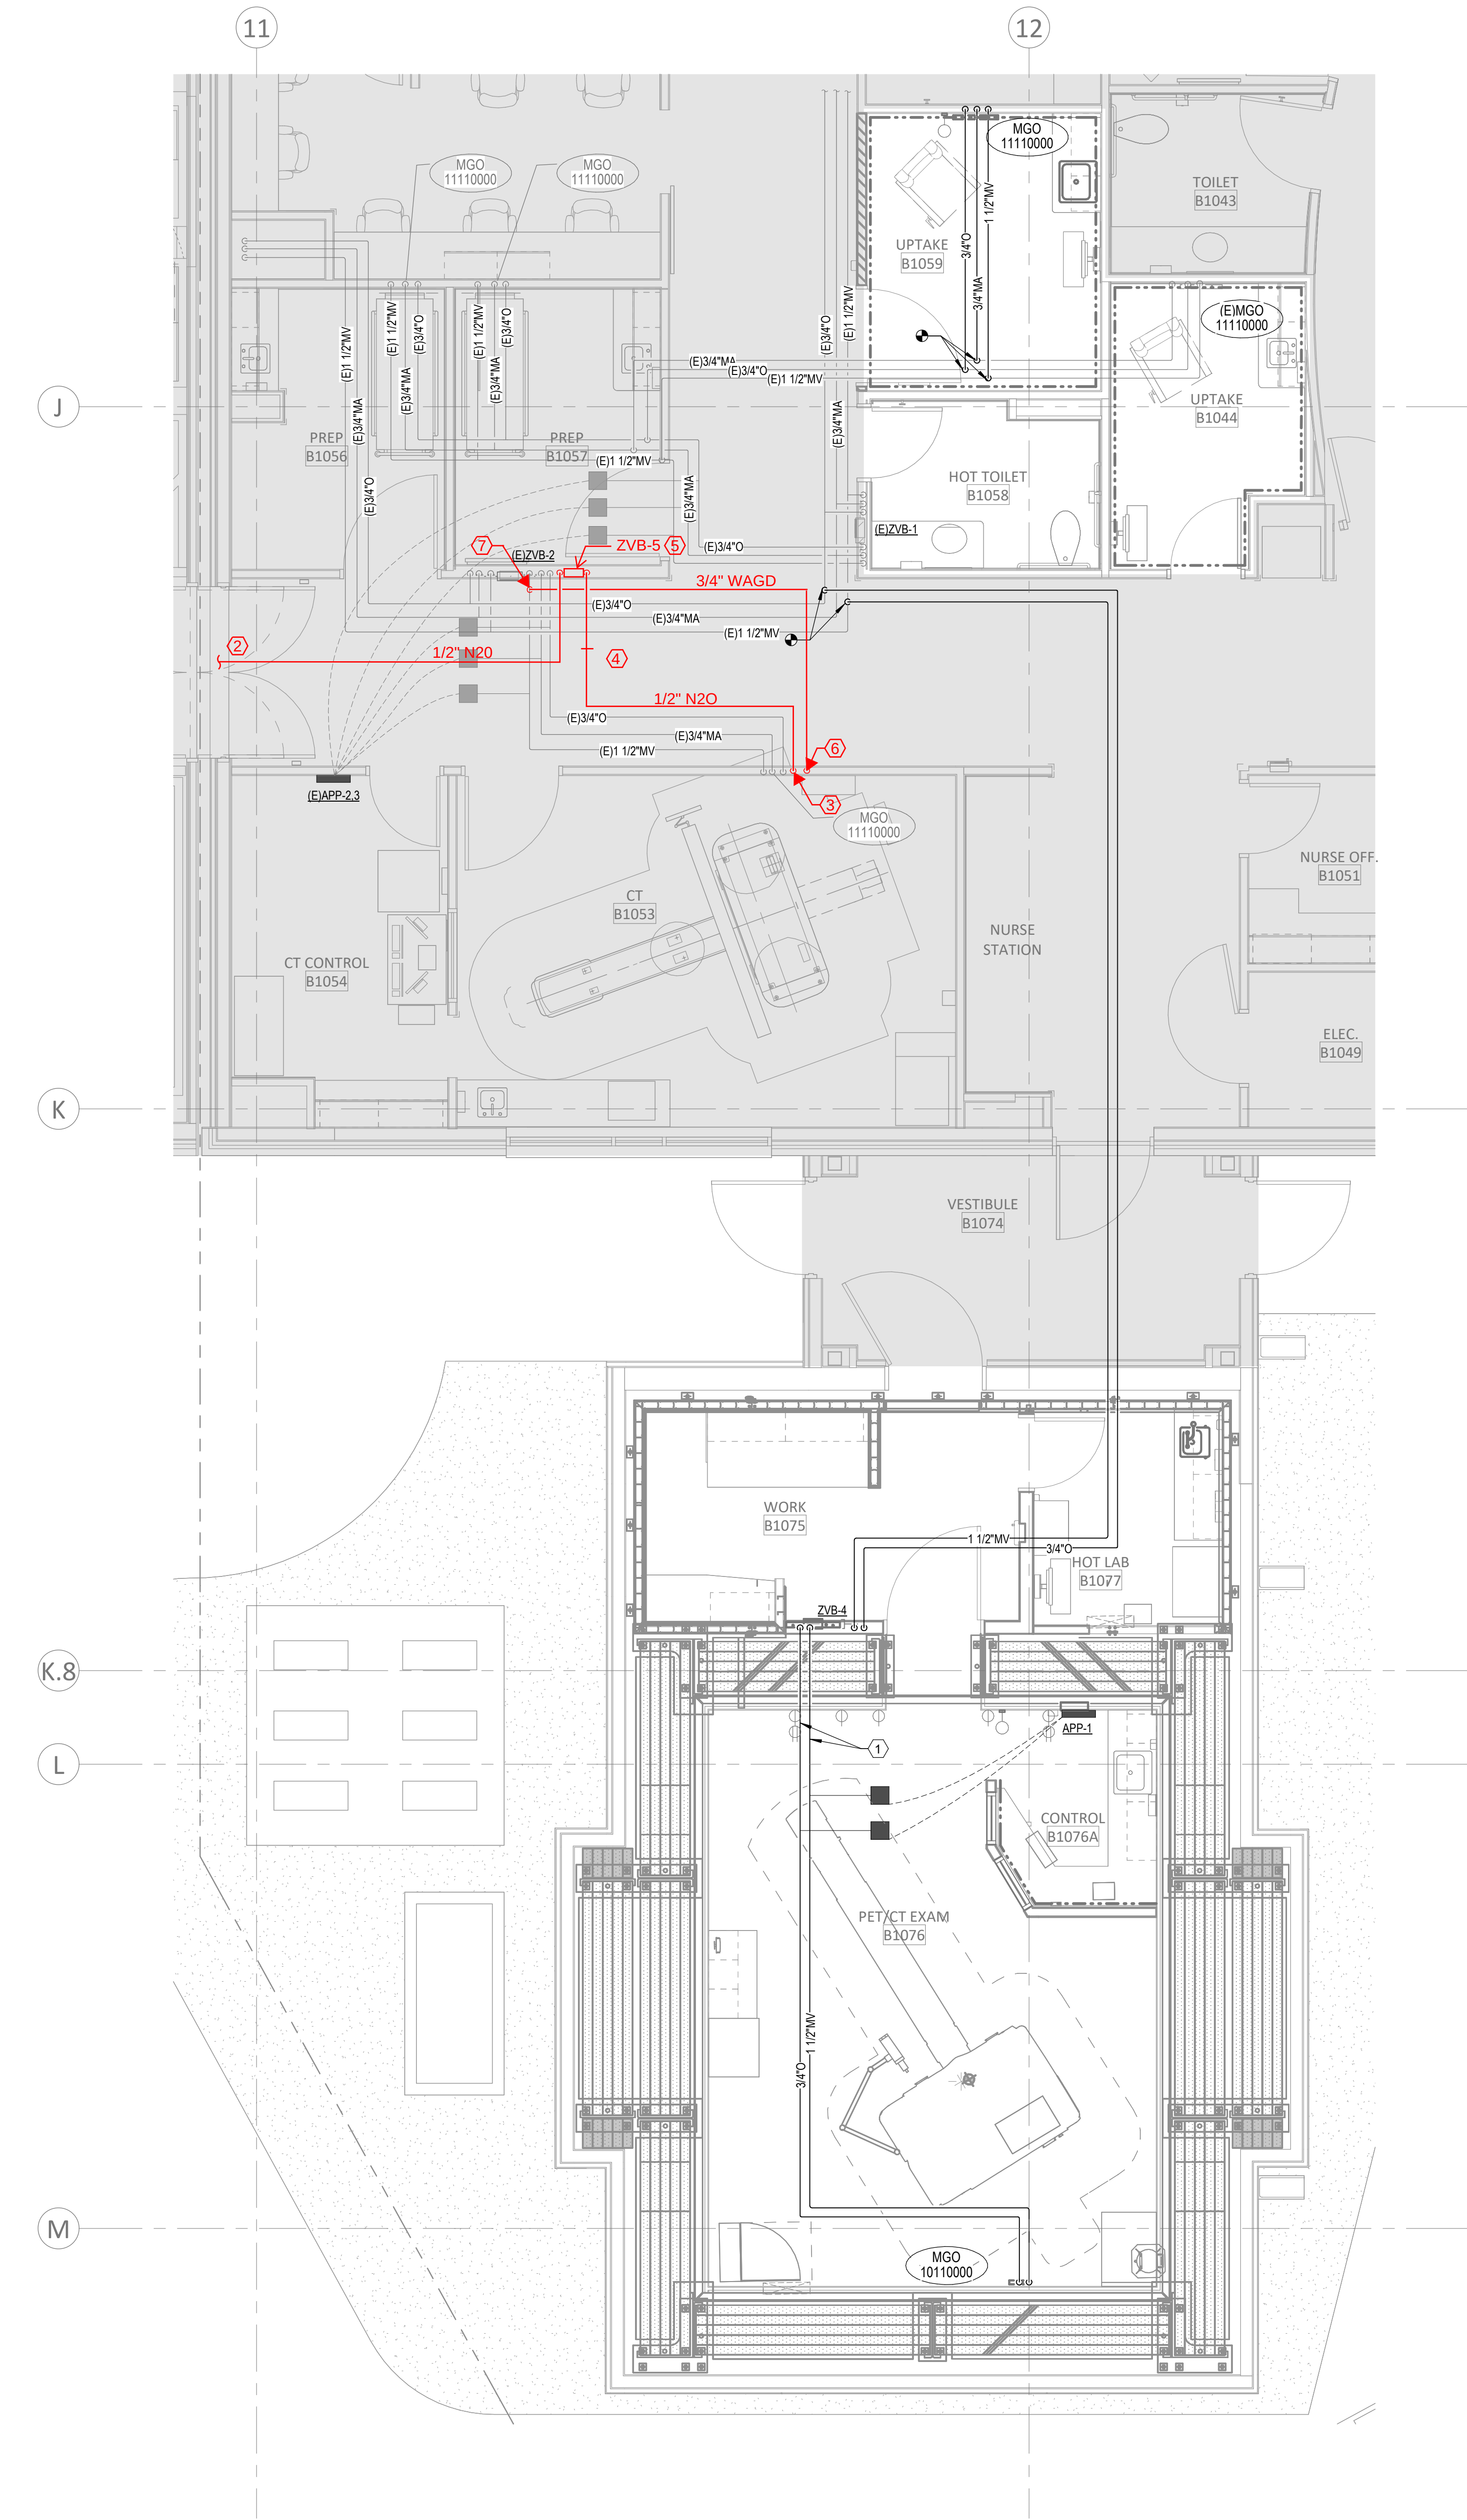

1 FLOOR PLAN - FLOOR 1 - AREA A - MEDICAL GAS
P3.11 1/4" = 1'-0"

GENERAL NOTES

A. REFER TO GENERAL INFORMATION/LEGEND SHEET.

LEGEND NOTES

1. CONTRACTOR TO USE EXISTING PENETRATIONS FROM CONDUIT REMOVAL AS A PATH FOR MEDICAL GASES THROUGH SHIELDING.
2. CONTRACTOR TO CONNECT NEW 1/2" N2O LINE TO EXISTING N2O LINE SERVING CT - 1125 PRIOR TO ZONE VALVE BOX.
3. CONTRACTOR TO EXTEND NEW 1/2" N2O LINE DOWN TO NEW MEDICAL GAS OUTLET. MATCH ALL FINISHES TO WHAT IS EXISTING.
4. CONTRACTOR TO ADD NEW 1/2" N2O LINE TO (E)APP-2.3. MAKE ALL FINAL CONNECTIONS AS PER MANUFACTURER'S RECOMMENDATIONS
5. CONTRACTOR TO EXTEND 1/2" N2O DOWN TO NEW ZVB-5. MAKE ALL FINAL CONNECTIONS AS PER MANUFACTURER'S RECOMMENDATIONS.
6. CONTRACTOR TO EXTEND NEW 3/4" WAGD LINE DOWN TO NEW MEDICAL GAS OUTLET. MATCH ALL FINISHES TO WHAT IS EXISTING.
7. CONTRACTOR TO CONNECT NEW WAGD PIPING LINE TO EXISTING VACUUM LINE. CONTRACTOR TO MAKE NEW CONNECTION AS FAR AWAY FROM EXISTING VACUUM INLET (MINIMUM OF 10').



BOULDER ASSOCIATES

1426 PEARL STREET, SUITE 300
BOULDER, COLORADO 80302
303.499.7795



WSP USA
2000 South Colorado Boulevard
Suite 2-1000
Denver, CO 80222
303.555.6605
wsp.com
WSP Project Number: US0051095.3525

PROJECT 257406.00

**COMMUNITY
HOSPITAL MOB 1
PET CT**

2373 G ROAD - SUITE #140
GRAND JUNCTION, CO
81505

**100% CONSTRUCTION
DOCUMENT**

DATE 02/06/2026

REVISIONS		
DESCRIPTION	DATE	

INTERIM REVIEW ONLY
These documents are incomplete, and
are released for interim review only and
are not intended for regulatory approval,
permit, or construction purposes.
Engineer
Eng. Reg. No.:
Date:

SHEET TITLE

**FLOOR PLAN - MEDICAL
GAS**

SHEET NUMBER

P3.11