

A	A/C	AIR CONDITIONING	F	F/F	FACE TO FACE	P	PBD	PARTICLEBOARD
	AB	ABOVE		FA	FIRE ALARM		PCF	POUNDS PER CUBIC FOOT
	ACST	ACOUSTIC, ACOUSTICAL		FAAP	FIRE ALARM ANNUNCIATOR PANEL		PPC	PORTLAND CEMENT PLASTER
	ADA	AMERICANS WITH DISABILITIES ACT		FAC	FIRE ALARM CONTROL PANEL		PLAM	PLASTIC LAMINATE
	ADJ	ADJUSTABLE		FDC	FLOOR CLEAN OUT		PLBG	PLUMBING
	ADJUT	ADJUTANT		FD	FLOOR DRAIN		PLYW	PLYWOOD
	ADF	ABOVE FINISH FLOOR		FDO	FIRE DEPARTMENT CONNECTION		PREFAB	PREFABRICATED
	AL	ALTERNATE		FDN	FOUNDATION		PREFNP	PREFINISHED
	ALUM	ALUMINUM		FE	FIRE EXTINGUISHER		PRKG	PARKING
	ANOD	ANODIZED		FEC	FIRE EXTINGUISHER CABINET		PSF	POUNDS PER SQUARE FOOT
	ARCH	ARCHITECT, ARCHITECTURAL		FF	FINISH FACE		PSI	POUNDS PER SQUARE INCH
	ASPH	ASPHALT		FFE	FINISH FLOOR ELEVATION		PT	PAINT
	ASSY	ASSEMBLY		FH	FIRE HYDRANT		PTD	PAPER TOWEL DISPENSER
	AUTO	AUTOMATIC		FHC	FIRE HOSE CABINET		PTN	PARTITION
				FIN	FINISH		PVC	POLYVINYL CHLORIDE
B	BATT	BATT INSULATION		FIXT	FIXTURE	Q	QT	QUARRY TILE
	BKR	BACKER ROD		FLR	FLOOR		QTB	QUARRY TILE BASE
	BD	BOARD		FOF	FACE OF FINISH		QTY	QUANTITY
	BF	BOTH FACES		FS	FACE OF STUD			
	BLDG	BUILDING		FR	FRAME		R	
	BLKG	BLOCKING		FRP	FIBERGLASS REINFORCED PLASTIC		R	RADIUS, RISER
	BLW	BELOW		FRTW	FIRE RETARDANT TREATED WOOD		R	RADIUS RESISTANCE
	BM	BEAM		FT	FOOT		RA	RETURN AIR
	BN	BULLNOSE		FUR	FURRING		RB	RUBBER BASE
	BOD	BASIS OF DESIGN					RD	ROOF DRAIN
	BOS	BOTTOM OF STEEL					RDL	ROOF DRAIN LEADER
	BOT	BOTTOM					RE	REFER TO
	BRG	BEARING					REINF	REINFORCE
	BS	BOTH SIDES					REQD	REQUIRED
	BSMT	BASEMENT					REV	REVISION
	BTWN	BETWEEN					RM	ROOM
	BUR	BUILT UP ROOFING					RO	ROUGH OPENING
	BW	BOTH WAYS					RP	REVOLUTIONS PER MINUTE
	BYND	BEYOND					RTU	ROOF TOP UNIT
C	CG	CORNER GUARD	G	GA	GAGE	R		
	CIP	CAST IN PLACE		GALV	GALVANIZED		R	RADIUS, RISER
	CLJ	CONTROL JOINT		GB	GRAB BAR		RA	RETURN AIR
	CL	CENTER LINE		GL	GLASS		RB	RUBBER BASE
	CLG	CEILING		GLU LAM	GLUED LAMINATED WOOD		RD	ROOF DRAIN
	CLST	CLOSET		GLZ	GLAZING		RDL	ROOF DRAIN LEADER
	CLT	CLEAR		GYP	GYPSUM		RE	REFER TO
	CLRM	CLOTH					REINF	REINFORCE
	CMU	CONCRETE MASONRY UNIT					REQD	REQUIRED
	COMP	COMPANY					REV	REVISION
	COL	COLUMN					RM	ROOM
	CONC	CONCRETE					RO	ROUGH OPENING
	CONT	CONTINUE					RP	REVOLUTIONS PER MINUTE
	CONTR	CONTRACTOR					RTU	ROOF TOP UNIT
	COORD	COORDINATE				S		
	CORR	CORRIDOR					SECTION	
	CPT	CARPET					SF	SQUARE FOOT, FEET
	CRS	COURSE(S)					SA	SUPPLY AIR
	CSWK	CASEWORK					SAT	SUSPENDED ACOUSTICAL TILE
	CTR	CENTER					SB	SLASH BLOCK
	CTV	CABLE TELEVISION					SCHED	SCHEDULE
	CUB	CUBIC					SC	

ARCHITECT:
Hord Coplan Macht
1800 Wazee St., Suite 450
Denver, CO. 80202

Ph: 303-607-0977
Fax: 303-607-0767
URL: www.hcm2.com

IMEG, Corp
780 E Orchard Road, Suite 250-S
Greenwood Village, CO 80111
Ph: 303-796-600
URL: imegcorp.com

CORE Consultants Inc.
3473 S Broadway
Englewood, CO 80113

Ph: 303-703-4444
URL: liveyourcore.com

IMEG, Corp
780 E Orchard Road, Suite 250-S
Greenwood Village, CO 80111
Ph: 303-796-600
URL: imegcorp.com

Hord Coplan Macht
1800 Wazee St., Suite 450
Denver, CO. 80202

Ph: 303-607-0977
Fax: 303-607-0767
URL: www.hcm2.com

IMEG, Corp
780 E Orchard Road, Suite 250-S
Greenwood Village, CO 80111
Ph: 303-796-600
URL: imegcorp.com

Ascent Group
79050 US Highway 40, Unit 1C
Winter Park, CO 80482
Ph: 303-499-3022
URL: ascentgrp.com

Material	Detail Number	Keynote Tag
Concrete	XX	101
CMU	A-XXX	054000.D01
Plywood	XX	
Gypsum	A-XXX	
Steel	XX	
Brick	XX	
Rough Lumber	A-XXX	
Finish Lumber	XX	
Rigid Insulation	A-XXX	
Batt Insulation	XX	

Figure 1: Examples of Detail Number and Keynote Tag. The figure shows a grid of material patterns and their corresponding detail numbers and keynote tags. The materials are Concrete, CMU, Plywood, Gypsum, Steel, Brick, Rough Lumber, Finish Lumber, Rigid Insulation, and Batt Insulation. The detail numbers are shown as 'XX' or 'A-XXX' with arrows pointing to the corresponding material. The keynote tags are shown as '101' or '054000.D01' with arrows pointing to the corresponding material.

[illegible]

125 Eastom Ave
Fraser, CO 80442
CONSTRUCTION DOCUMENTS SUMMER 2026

2026/02/11



G-001	GENERAL INFORMATION AND SHEET INDEX
G-002	LIFE SAFETY PLANS

C-100	DEMOLITION PLAN
C-101	EROSION CONTROL PLAN - INITIAL - PLAYGROUND
C-102	EROSION CONTROL PLAN - INITIAL - PARKING
C-103	EROSION CONTROL PLAN - INITIAL - ADDITION
C-104	EROSION CONTROL PLAN - INITIAL - ADDITION (2)
C-105	EROSION CONTROL PLAN - INITIAL - CD - GAS LINE
C-106	EROSION CONTROL PLAN - INTERIM & FINAL - PLAYGROUND
C-107	EROSION CONTROL PLAN - INTERIM & FINAL - PARKING
C-108	EROSION CONTROL PLAN - INTERIM & FINAL - ADDITION
C-109	EROSION CONTROL PLAN - INTERIM & FINAL - ADDITION (2)
C-110	EROSION CONTROL - INTERIM & FINAL - GAS LINE
C-200	GRADING PLAN - PLAYGROUND
C-300	GRADING PLAN - PARKING
C-400	GRADING PLAN - ADDITION
C-401	WATER PLAN - NORGREN ROAD
C-402	GAS LINE RELOCATION PLAN
C-500	STRIPING PLAN
C-501	PAVING PLAN
C-600	STANDARD DETAILS AND NOTES
C-700	STANDARD DETAILS & NOTES

L-001	GENERAL INFORMATION
L-100	SITE DEMOLITION PLAN PRE-K PLAYGROUND
L-200	OVERALL SITE MATERIALS PLAN
L-201	SITE MATERIALS PLAN PRE-K PLAYGROUND ENLARGEMENT
L-500	SITE DETAILS - 1

A-111	FLOOR PLANS
A-121	REFLECTED CEILING PLANS
A-121A	FIRST FLOOR REFLECTED CEILING PLAN - AREA A
A-121B	FIRST FLOOR REFLECTED CEILING PLAN - AREA B
A-121C	FIRST FLOOR REFLECTED CEILING PLAN - AREA C
A-141	OVERALL FINISH PLANS, FINISH LEGEND & ROOM FINISH SCHEDULE
A-141A	FIRST FLOOR FINISH PLAN - AREA A
A-141B	FIRST FLOOR FINISH PLAN - AREA B
A-141C	FIRST FLOOR FINISH PLAN - AREA C
A-142B	SECOND FLOOR FINISH PLAN - AREA B
A-200	EXTERIOR ELEVATIONS
A-601	DOOR, WINDOW, STOREFRONT SCHEDULE, TYPES, AND DETAILS

M-000	MECHANICAL, PLUMBING AND FIRE PROTECTION COVER SHEET
MD-111A	LEVEL 01 DEMOLITION PLAN - MECHANICAL - AREA A
M-121A	LEVEL 01 PLAN - PIPING - AREA A
M-121C	LEVEL 01 PLAN - PIPING - AREA C
M-122A	LEVEL 02 PLAN - PIPING - AREA A
M-122B	LEVEL 02 PLAN - PIPING - AREA B
M-400	MECHANICAL DETAILS
M-500	MECHANICAL DIAGRAMS
M-601	MECHANICAL SCHEDULES

E-000	ELECTRICAL COVER SHEET
ED-121A	LEVEL 01 DEMOLITION PLAN - LIGHTING - AREA A
ED-121B	LEVEL 01 DEMOLITION PLAN - LIGHTING - AREA A
ED-121C	LEVEL 01 DEMOLITION PLAN - LIGHTING - AREA C
E-122	LEVEL 02 DEMOLITION PLAN - LIGHTING - AREA B
E-111C	LEVEL 01 PLAN - POWER AND SYSTEMS - AREA C
E-112B	LEVEL 02 PLAN - POWER AND SYSTEMS - AREA B
E-121A	LEVEL 01 PLAN - LIGHTING - AREA A
E-121B	LEVEL 01 PLAN - LIGHTING - AREA B
E-121C	LEVEL 01 PLAN - LIGHTING - AREA C
E-122B	LEVEL 02 PLAN - LIGHTING - AREA B
E-002	ELECTRICAL SCHEDULE

S-010	GENERAL NOTES AND INSPECTION SCHEDULES
S-100	EAST WING, NEW OPENINGS

ALTERNATE 01: PRESCHOOL PLAYGROUND SCOPE, POURED IN PLACE SURFACING AND SHADE STRUCTURE.

ALTERNATE 02: LIGHTING REPLACEMENT, REPLACE ALL CEILING TILE AND LIGHTING IN CORRIDORS AS INDICATED ON ARCHITECTURAL AND ELECTRICAL DRAWINGS. COST BREAK OUT A SEPARATE COST FOR REPLACEMENT LIGHTING SCOPE IN GYMNASIUM.

ALTERNATE 03: INTERIOR FLOORING AND PAINTING SCOPE. PAINT AND CARPET AREAS INDICATED ON FINISH DRAWINGS.

ALTERNATE 04: PARKING LOT PAVING SCOPE, MILL AND OVERLAY EXISTING PARKING LOT AS SHOWN ON CIVIL DRAWINGS. ADD PAVING IN AREA INDICATED BETWEEN EXISTING LOT AND ROADWAY.

ALTERNATE 05: FLOOD CONTROL SCOPE. ADD AREA DRAIN, PIPING, CONCRETE PANELS AT BUILDING ON THE WEST SIDE OF THE BUILDING AT RECENT CLASSROOM ADDITION. REFER TO CIVIL DRAWINGS AND DETAIL FOR WALL/FOUNDATION IN ARCHITECTURAL DRAWINGS.

ALTERNATE 06: HYDRONIC LOOP SCOPE, AS INDICATED ON MECHANICAL DRAWINGS.

ALTERNATE 07: WINDOW REFURBISHMENT AND REPLACEMENT SCOPE. SCOPE AS INDICATED ON EXTERIOR ELEVATIONS AND WINDOW SCHEDULE IN ARCHITECTURAL DRAWINGS. PROVIDE ADDITIONAL COST BREAK OUT FOR NEW WINDOWS AS INDICATED BY KEYNOTE 5 ON EXTERIOR ELEVATIONS.

ALTERNATE 08: WINDOWS IN CAFETERIA. PROVIDE THREE NEW WINDOWS IN CAFETERIA WITH NEW STRUCTURAL LINTELS. REFER TO EXTERIOR ELEVATIONS, WINDOW SCHEDULE AND STRUCTURAL DRAWINGS.

ARCHITECT
Hord Coplan Macht, Inc.
1800 Wazee Street, Suite 450
Denver, CO 80202
p. 303.607.0977
f. 303.607.0767

M/E/P ENGINEER
IMEG, Corp.
780 E Orchard Road, Suite 250-S
Greenwood Village, CO 80111
p. 303.795.6000
w. imegcorp.com

CIVIL ENGINEERS
CORE Consultants Inc.
3473 S Broadway
Englewood, CO 80113
p. 303.795.4444
w. liveyourcore.com

STRUCTURAL ENGINEERS
ASCENT Structural Engineering
1711 Pearl Street
Boulder, CO 80302
p. 303.499.3022
w. ASCENTgrp.com

EAST GRAND SCHOOL DISTRICT
Fraser Valley Elementary School
Renovation Summer 2026

125 Eastom Ave
Fraser, CO 80442

hord | coplan | macht

ARCHITECTURE
LANDSCAPE ARCHITECTURE
PLANNING
INTERIOR DESIGN

1	03/05/2026	Addendum 01
No.	Date	Revision

Project Name
Fraser Valley Elementary School
Renovation Summer 2026

Project Number	
222000.50	
Date (YYYY/MM/DD)	
2026/02/11	
Drawn By	Checked By
GW	KA
Drawing	
GENERAL INFORMATION AND SHEET INDEX	

G-001

CONSTRUCTION
DOCUMENTS SUMMER
2026

© Hord Coplan Macht, Inc.

ARCHITECT
Hord Coplan Macht, Inc.
1802 Wazee Street, Suite 450
Denver, CO 80202
p. 303.607.0977
f. 303.607.0767
w. hordcoplanmacht.com

M/E/P ENGINEER
IMEG, Corp.
780 E Orchard Road, Suite 250-S
Greenwood Village, CO 80111
p. 303.796.8000
w. imegcorp.com

CIVIL ENGINEERS
CORE Consultants Inc.
3473 S Broadway
Englewood, CO 80113
p. 303.703.4444
w. liveyourcore.com

STRUCTURAL ENGINEERS
ASCENT Structural Engineering
1711 Pearl Street
Boulder, CO 80302
p. 303.499.3022
w. ASCENTgrp.com

EAST GRAND SCHOOL DISTRICT
Fraser Valley Elementary School
Renovation Summer 2026

125 Easton Ave
Fraser, CO 80442

hord | coplan | macht
ARCHITECTURE
LANDSCAPE ARCHITECTURE
PLANNING
INTERIOR DESIGN

1	03/05/2026	Addendum 01
No.	Date	Revision




Project Name
Fraser Valley Elementary School
Renovation Summer 2026

Project Number
222000.50
Date (YYYY/MM/DD)
2026/02/11
Drawn By
GW
Checked By
KA
Drawing
FLOOR PLANS

A-111

CONSTRUCTION
DOCUMENTS SUMMER
2026

© Hord Coplan Macht, Inc.

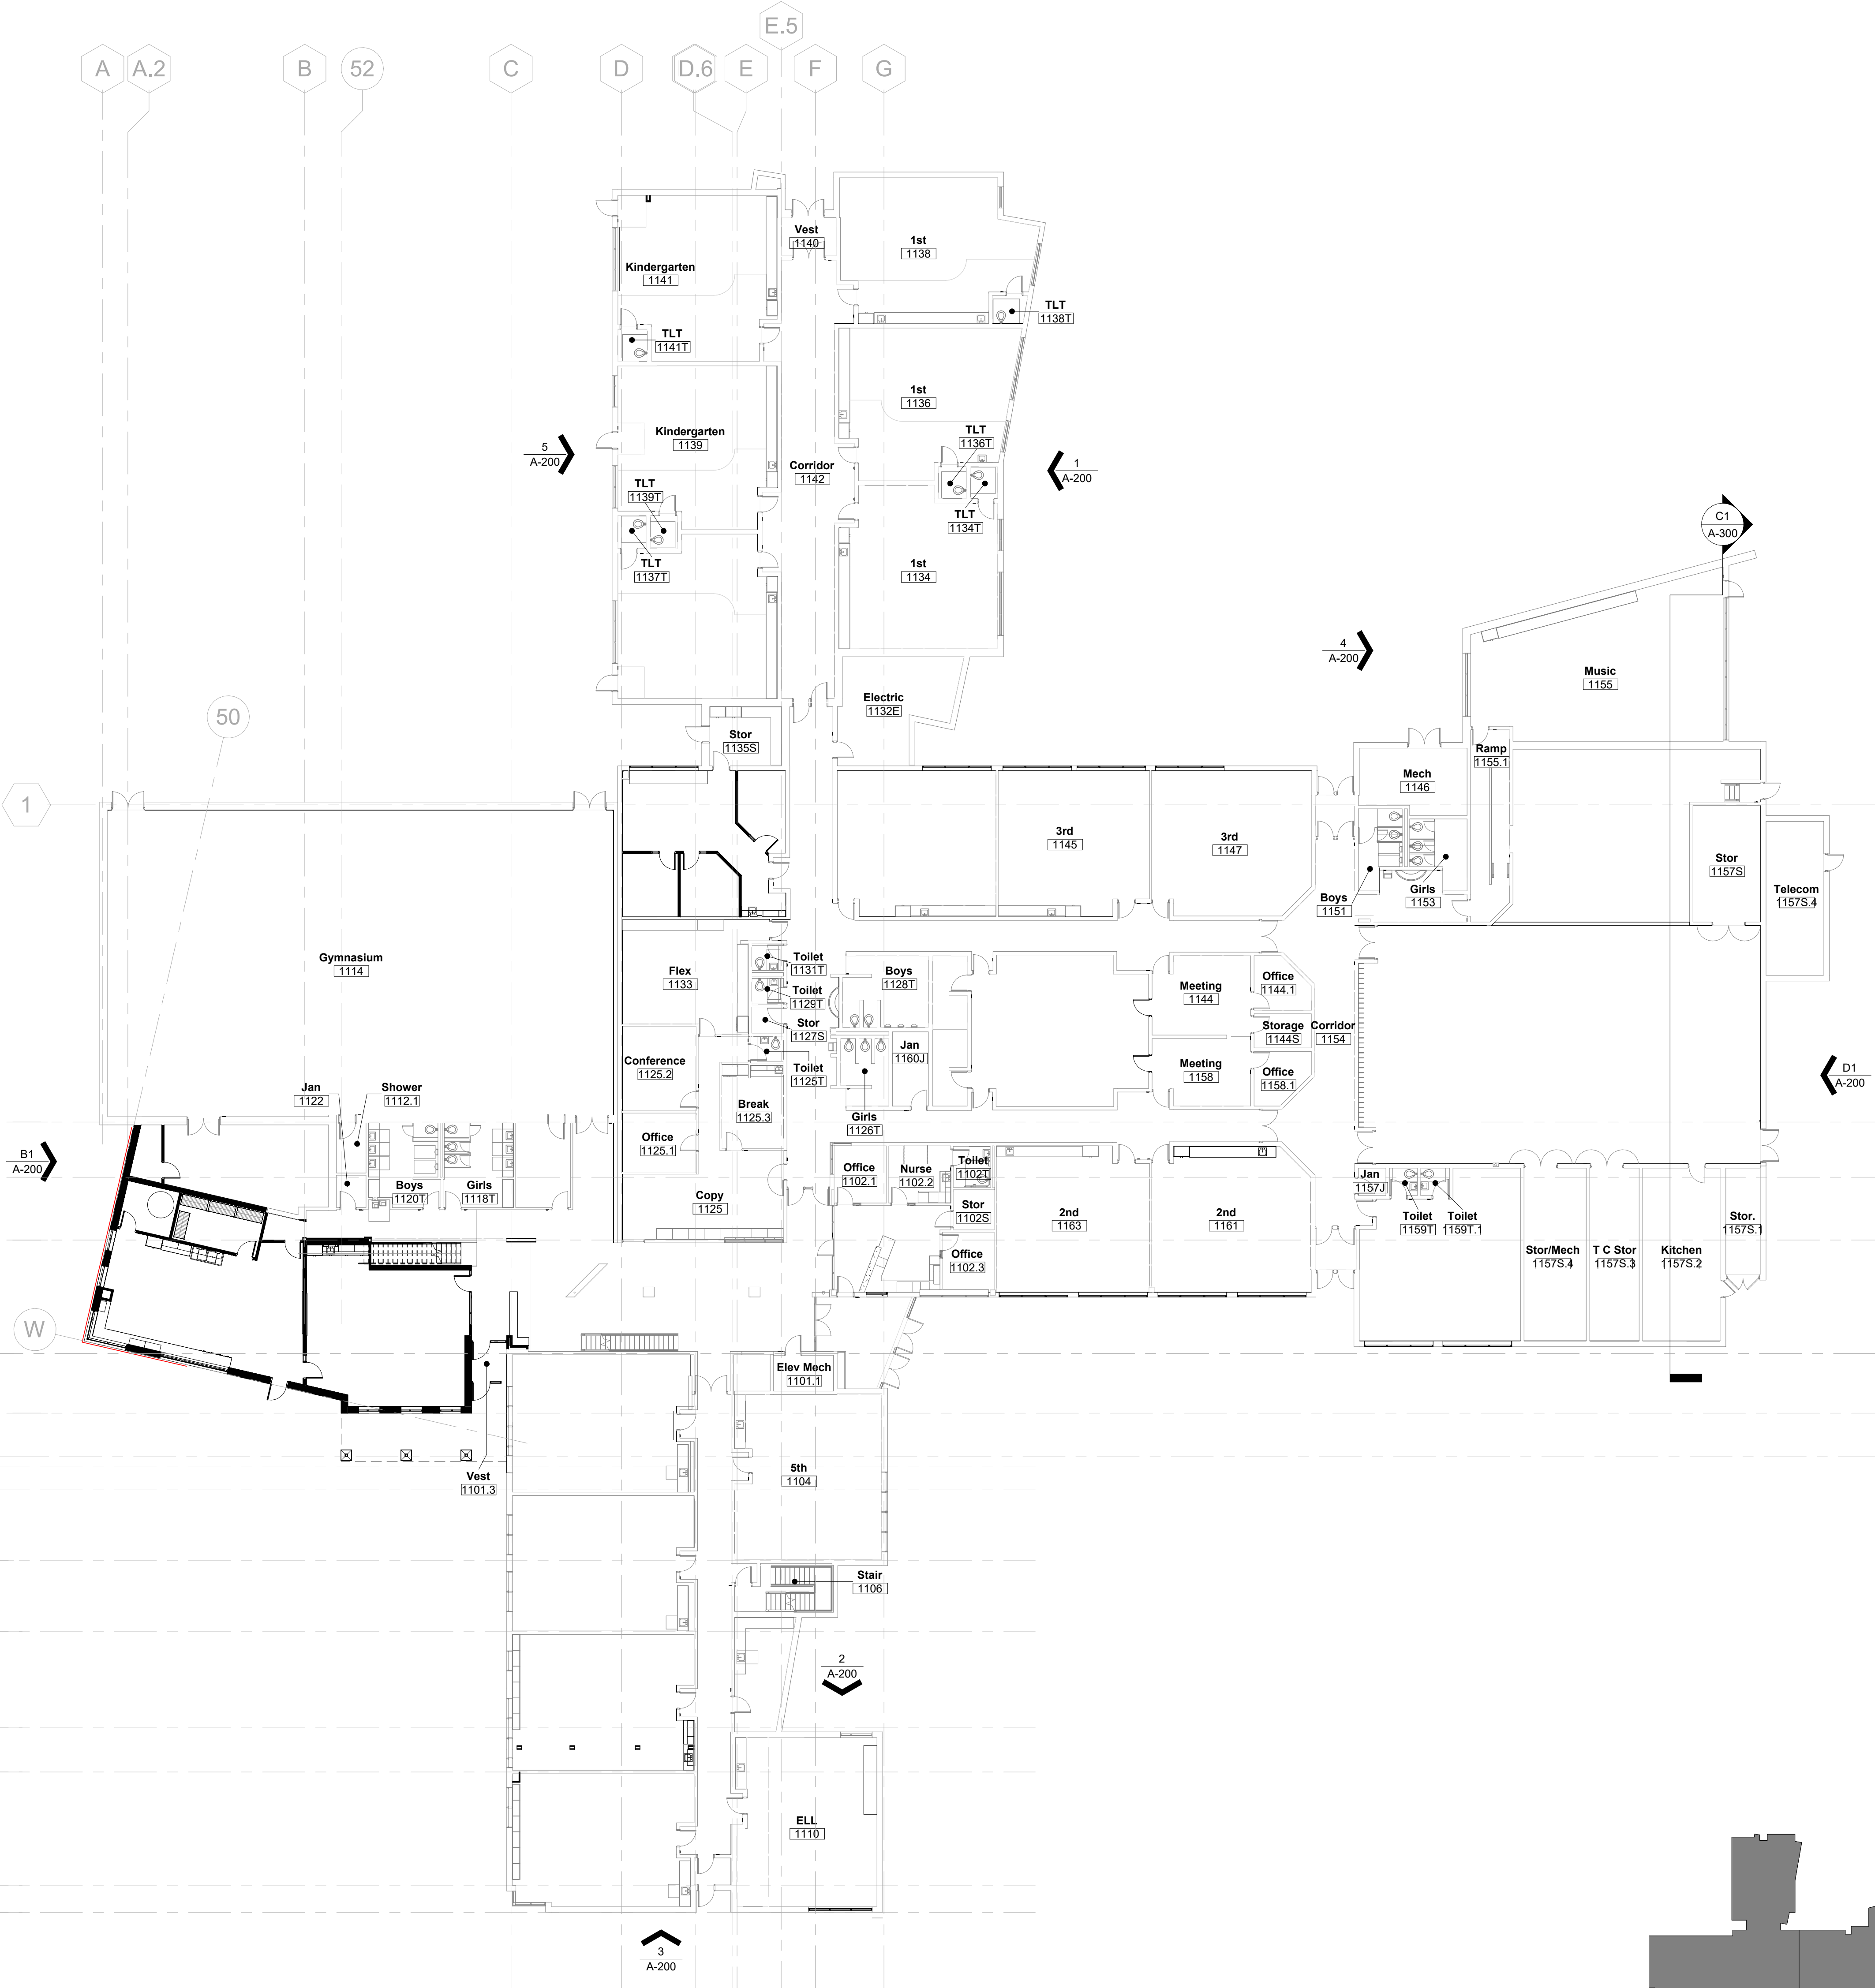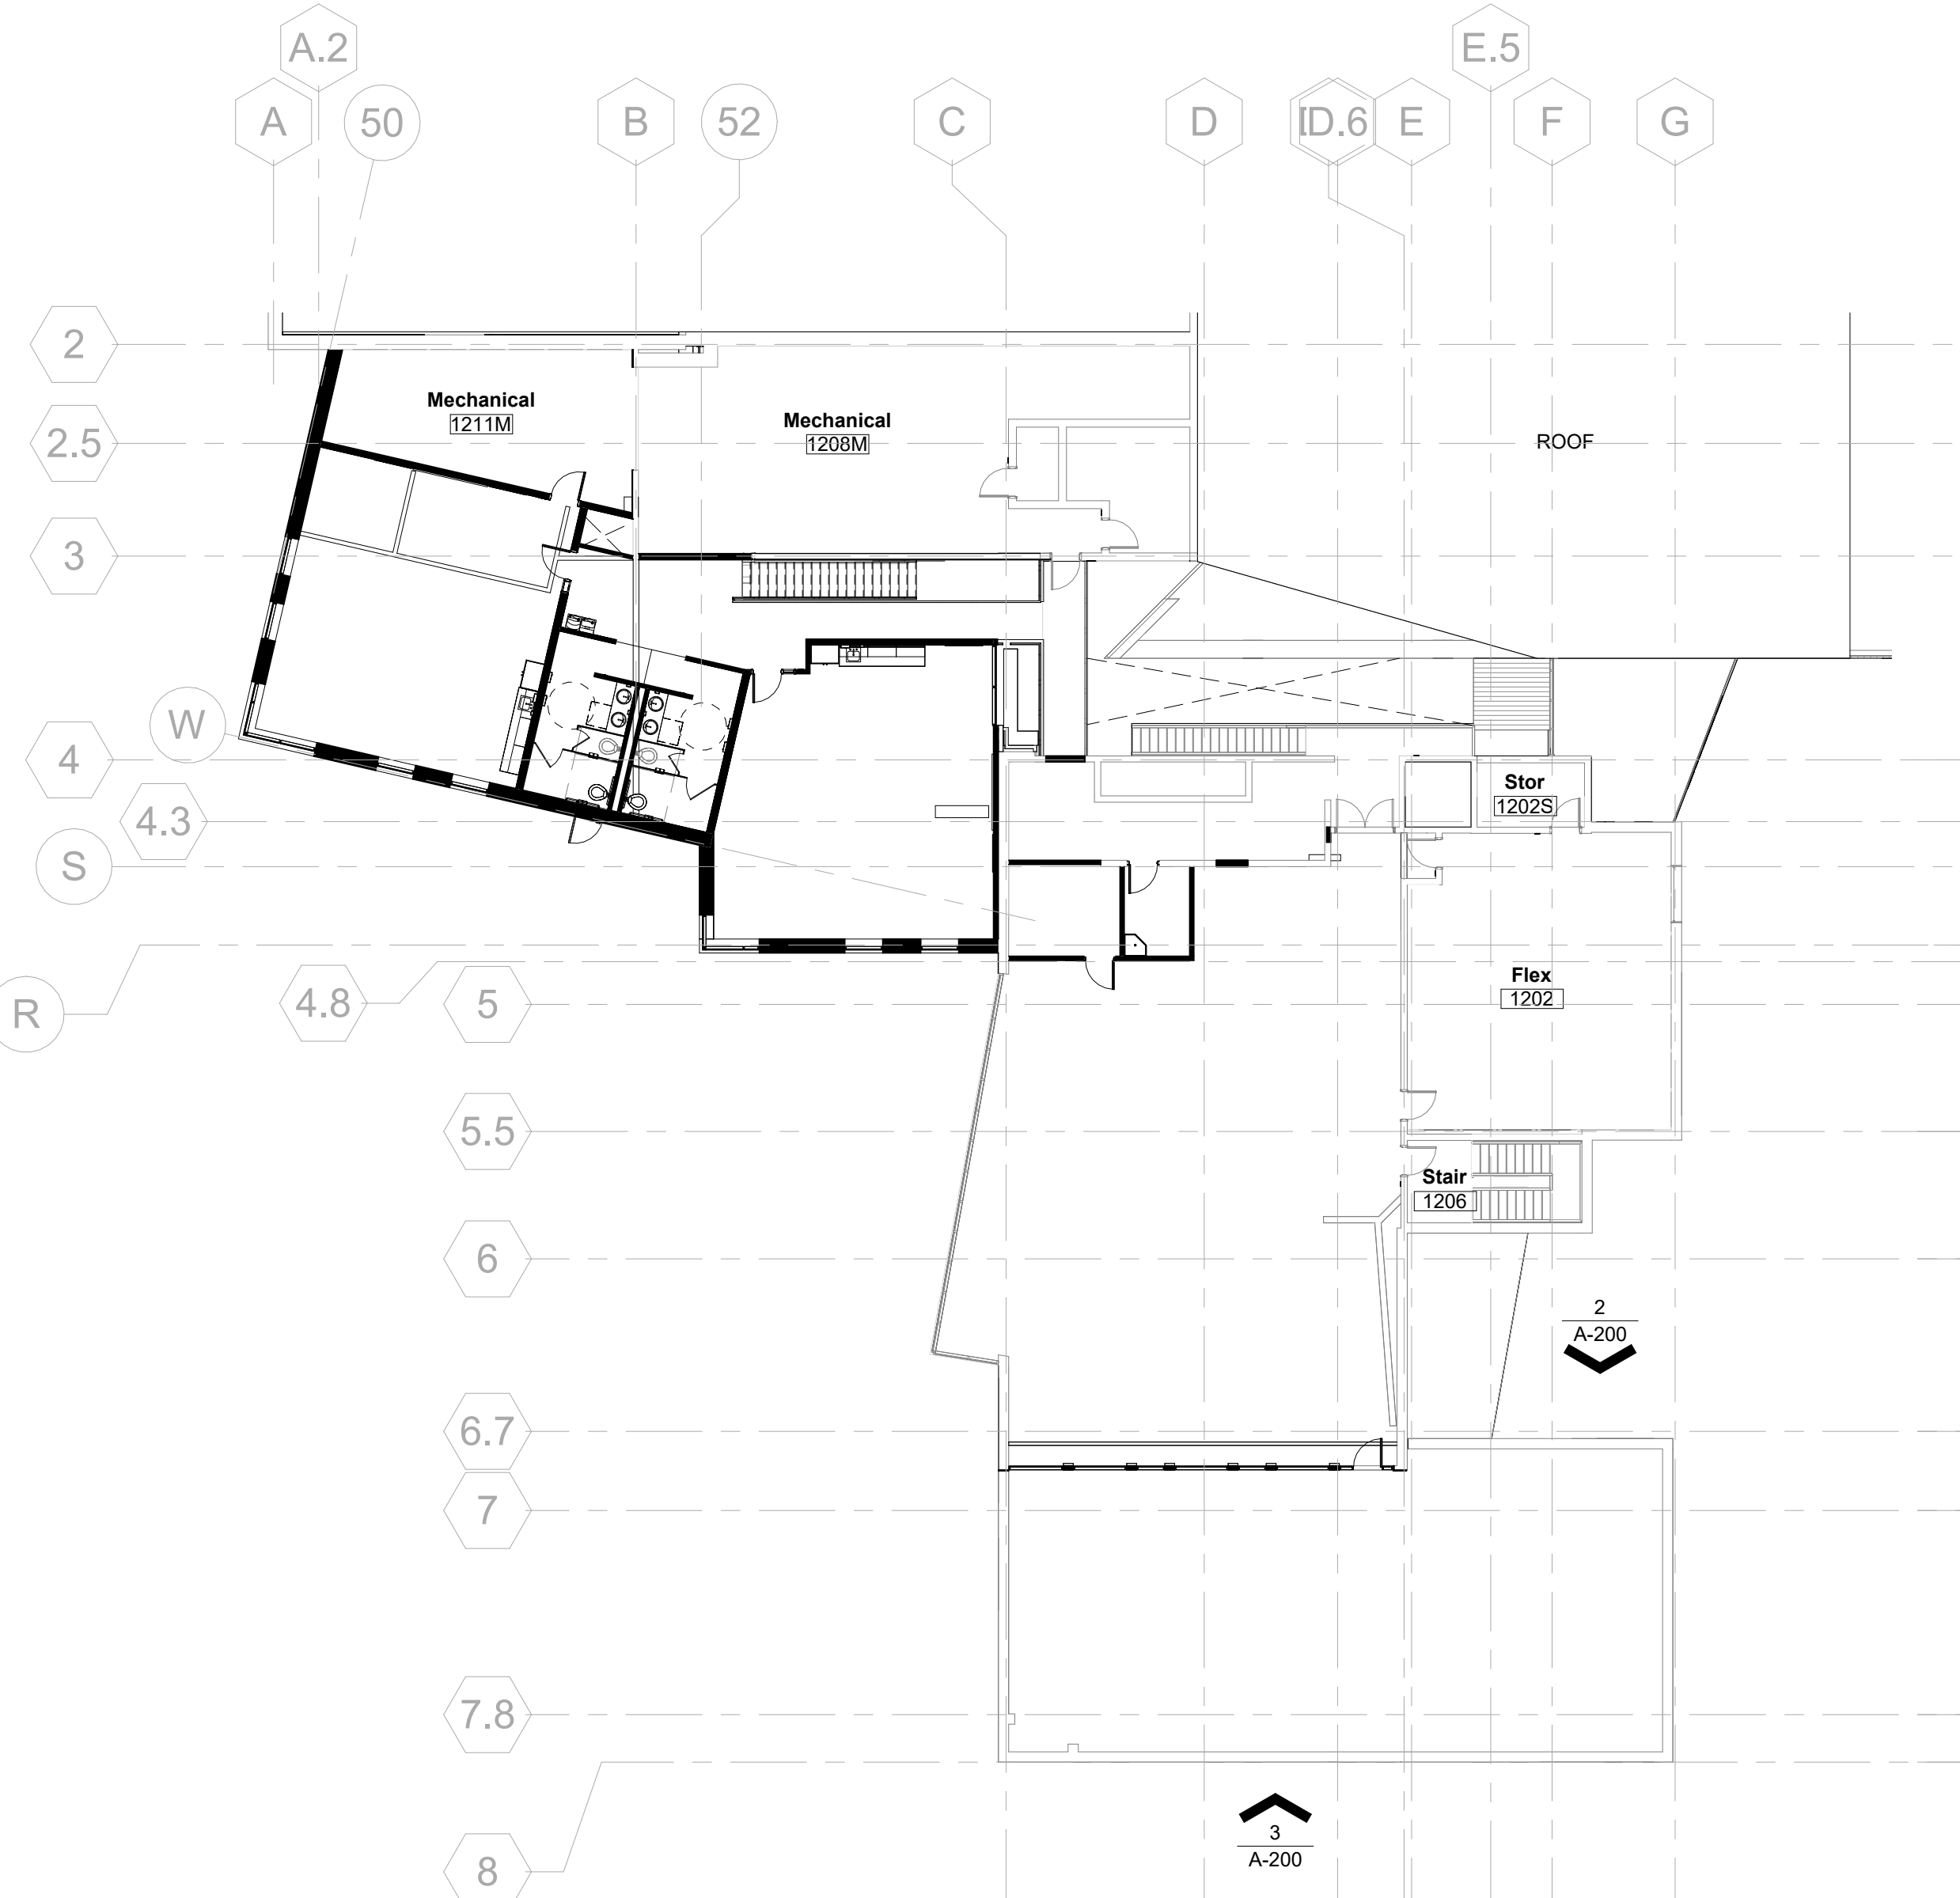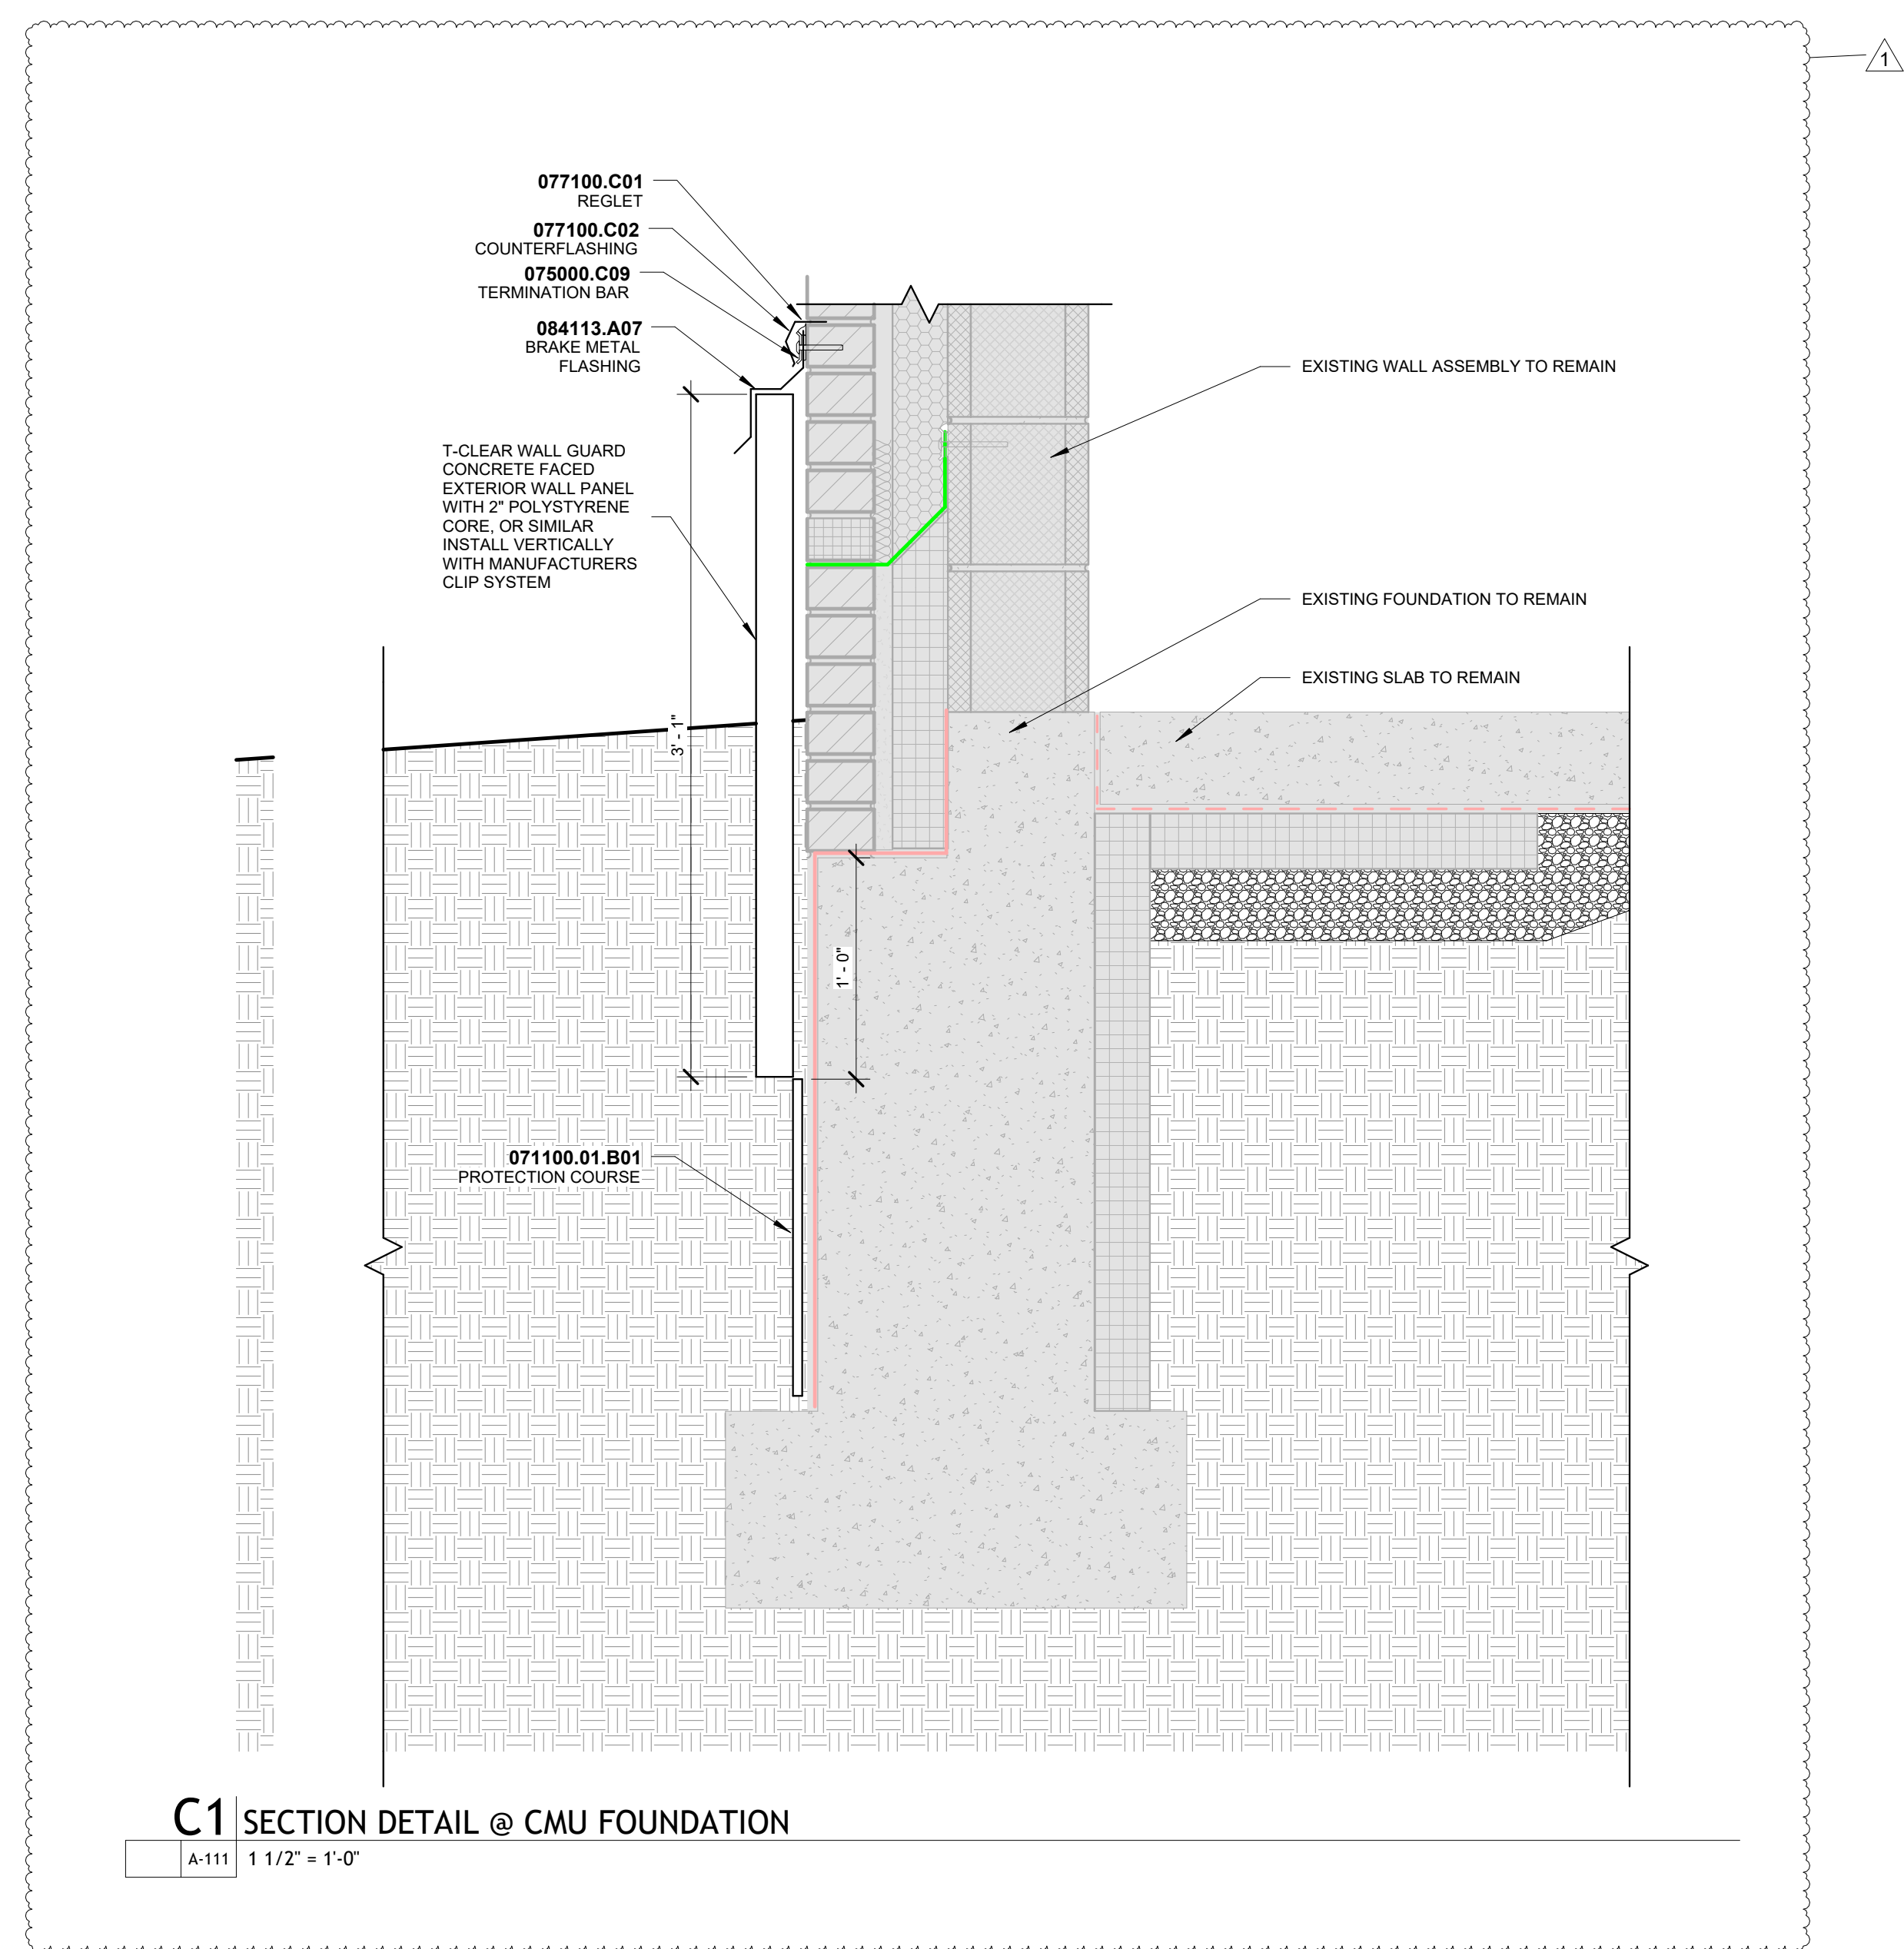

1. ALL CEILING ELEVATIONS TO BE DIMENSIONED FROM SLAB ELEVATION BELOW OR FINISH FLOORS.
2. CENTER ALL DEVICES, SPRINKLER HEADS, ETC. IN CEILING TILE.

1. ALL CEILING ELEVATIONS TO BE DIMENSIONED FROM SLAB ELEVATION BELOW OR FINISH FLOORS.
2. CENTER ALL DEVICES, SPRINKLER HEADS, ETC. IN CEILING TILE.

C-1
NEW 24" X 48" ACOUSTIC CEILING PANELS. EXISTING REMAIN.

C-2
EXISTING SOFFIT, NEW PAINT

C-4
EXISTING GYP CEILING, NEW PAINT

C-5
EXISTING GYP CEILING, PATCH, REPAIR, AND PAINT WHERE EXISTING RECESSED LINEAR FIXTURES WERE REMOVED.

NOT IN PROJECT SCOPE

ARCHITECT
Hord Coplan Macht, Inc.
8000 Wazee Street, Suite 450
Denver, CO 80202
P. 303.607.0977
F. 303.607.0767

M/E/P ENGINEER
IMEG, Corp.
1000 E Orchard Road, Suite 250-S
Greenwood Village, CO 80111
P. 303.796.6000
W. imegcorp.com

CIVIL ENGINEERS
Core Consultants Inc.
1473 S Broadway
Englewood, CO 80113
P. 303.703.4444
W. coreyoure.com

STRUCTURAL ENGINEERS
ASCENT Structural Engineering
7171 Pearl Street
Boulder, CO 80302
P. 303.499.3022
W. ASCENTgrp.com

Fraser Valley Elementary School
Renovation Summer 2026

125 Eastom Ave
Fraser, CO 80442

ARCHITECTURE
LANDSCAPE ARCHITECTURE
PLANNING
INTERIOR DESIGN

1	03/05/2026	Addendum 01
No.	Date	Revision

Project Name
Fraser Valley Elementary School
Renovation Summer 2026

Project Number
22000.50

2026/02/11


Drawn By	Checked By
GW	KA

FIRST FLOOR REFLECTED
CEILING PLAN - AREA B

A-121B


CONSTRUCTION
DOCUMENTS SUMMER
2026

Hord Coplan Macht, Inc.

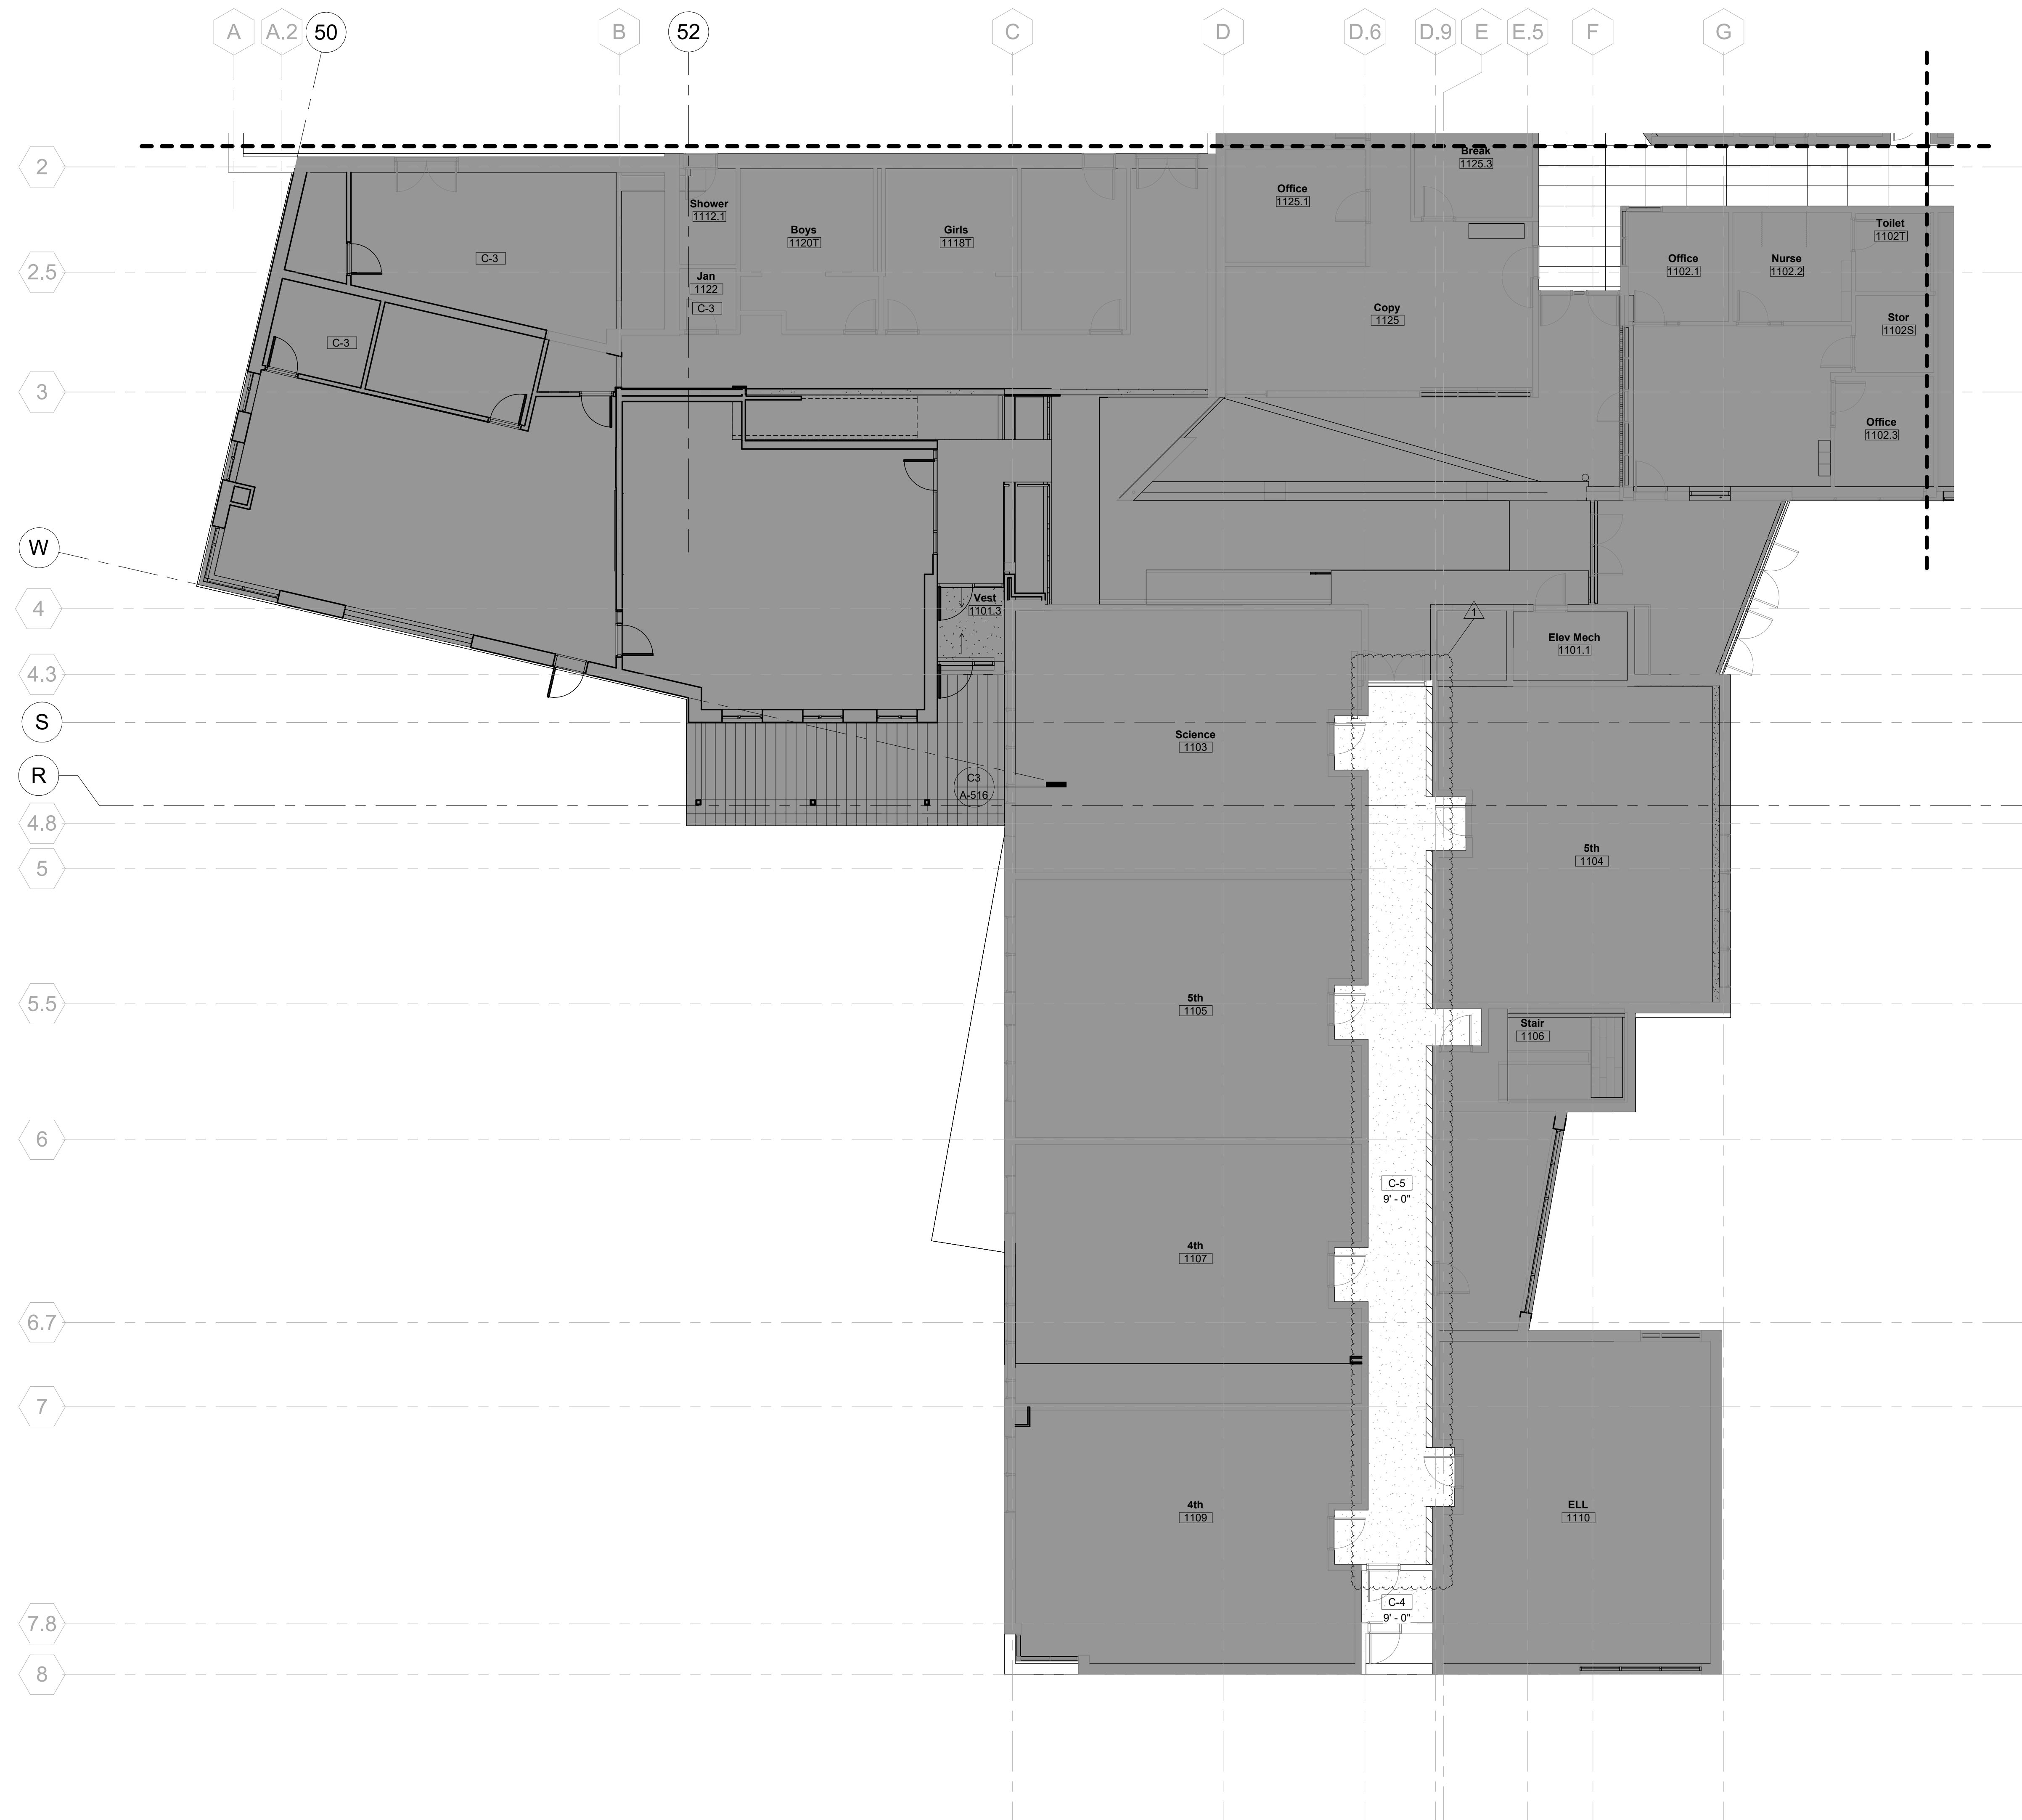

A1 FIRST FLOOR REFLECTED CEILING PLAN - AREA B

A-200	A-121B	1/8" = 1'-0"
-------	--------	--------------

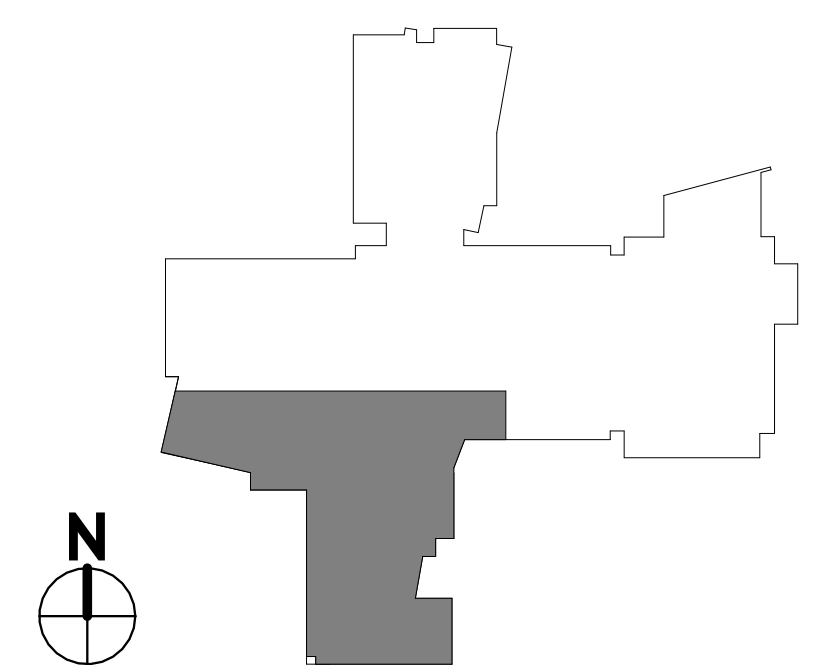

Autodesk Docs/122000-50 Fraser Elementary School/220000 - Fraser Elem School - R2025.nt

3/5/2025 10:26:01 AM

WEST GRAND SCHOOL DISTRICT
Fraser Valley Elementary School
Renovation Summer 2026


125 Eastom Ave
Fraser, CO 80442

125 Eastom Ave
Fraser, CO 80442

Project Name
Fraser Valley Elementary School
Renovation Summer 2026

A-601

© Hord Coplan Macht, Inc.

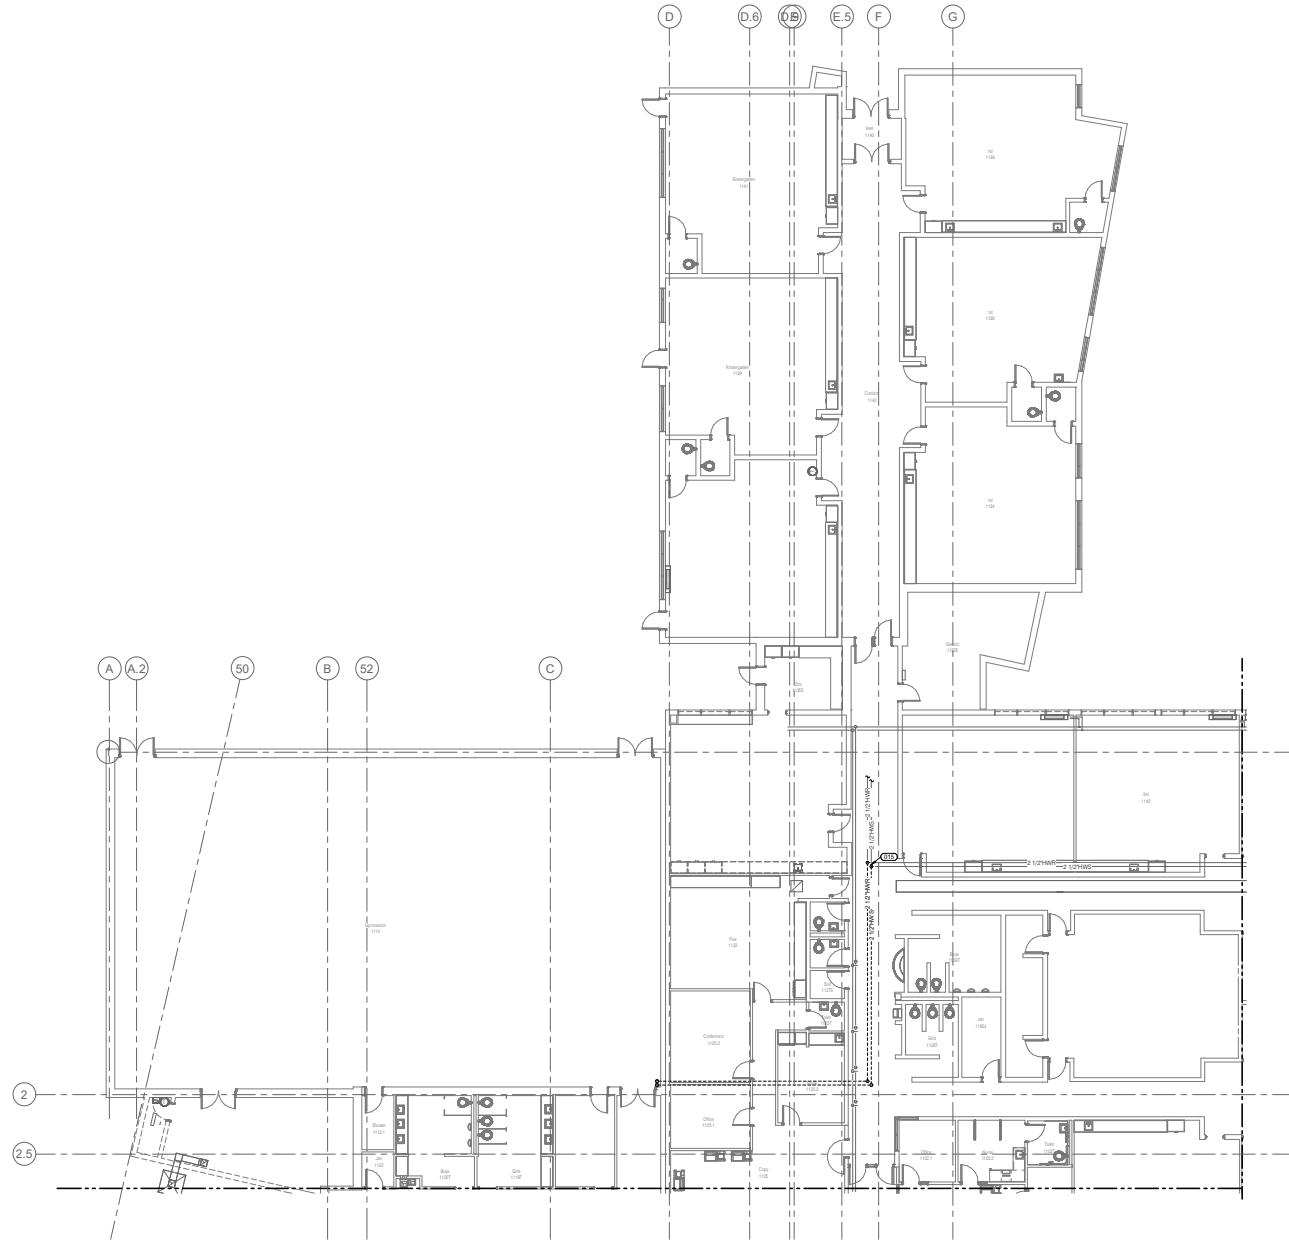

115
ALTERNATE OR DISCONNECT EXISTING HWS & HWR FROM EXISTING BOILER B-3 FROM HIGH-ABR PIPING FROM PUMPS P-7 AND P-8 SERVING 10 NORTH WING ADDITION.

ADDENDUM 01

KEYNOTES

ARCHITECT
Hord Coplan Macht, Inc.
1800 W. 10th Street, Suite 450
Denver, CO 80202
P: 303.801.2707
F: 303.801.2767
www.hcmach.com

STRUCTURAL ENGINEER
Academy Group
1800 W. 10th Street, Suite 450
Denver, CO 80202
P: 303.801.2707
F: 303.801.2767
www.academygroup.com

MEP ENGINEER
MEG, Corp.
1800 W. 10th Street, Suite 450
Denver, CO 80202
P: 303.801.2707
F: 303.801.2767
www.megcorp.com

CIVIL ENGINEER
JVA, Inc.
1800 W. 10th Street, Suite 450
Denver, CO 80202
P: 303.801.2707
F: 303.801.2767
www.jva-inc.com

EAST GRAND SCHOOL DISTRICT
Fraser Valley Elementary School
Renovation Summer 2026

hord | coplan | macht
ARCHITECTURE
LANDSCAPE ARCHITECTURE
PLANNING
INTERIOR DESIGN

No.	Date	Revision
1	02/02/2026	ADDENDUM 01

 

Project Name
Fraser Valley Elementary School
Renovation Summer 2026

Project Number
22200.50
Date (YYYYMMDD)
2026/02/11

Drawn By
BME

Checked By
BME


Project
LEVEL 01 DEMOLITION PLAN - MECHANICAL - AREA A

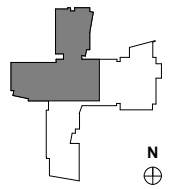

MD-111A



100% CONSTRUCTION DOCUMENTS

© Hord Coplan Macht, Inc.

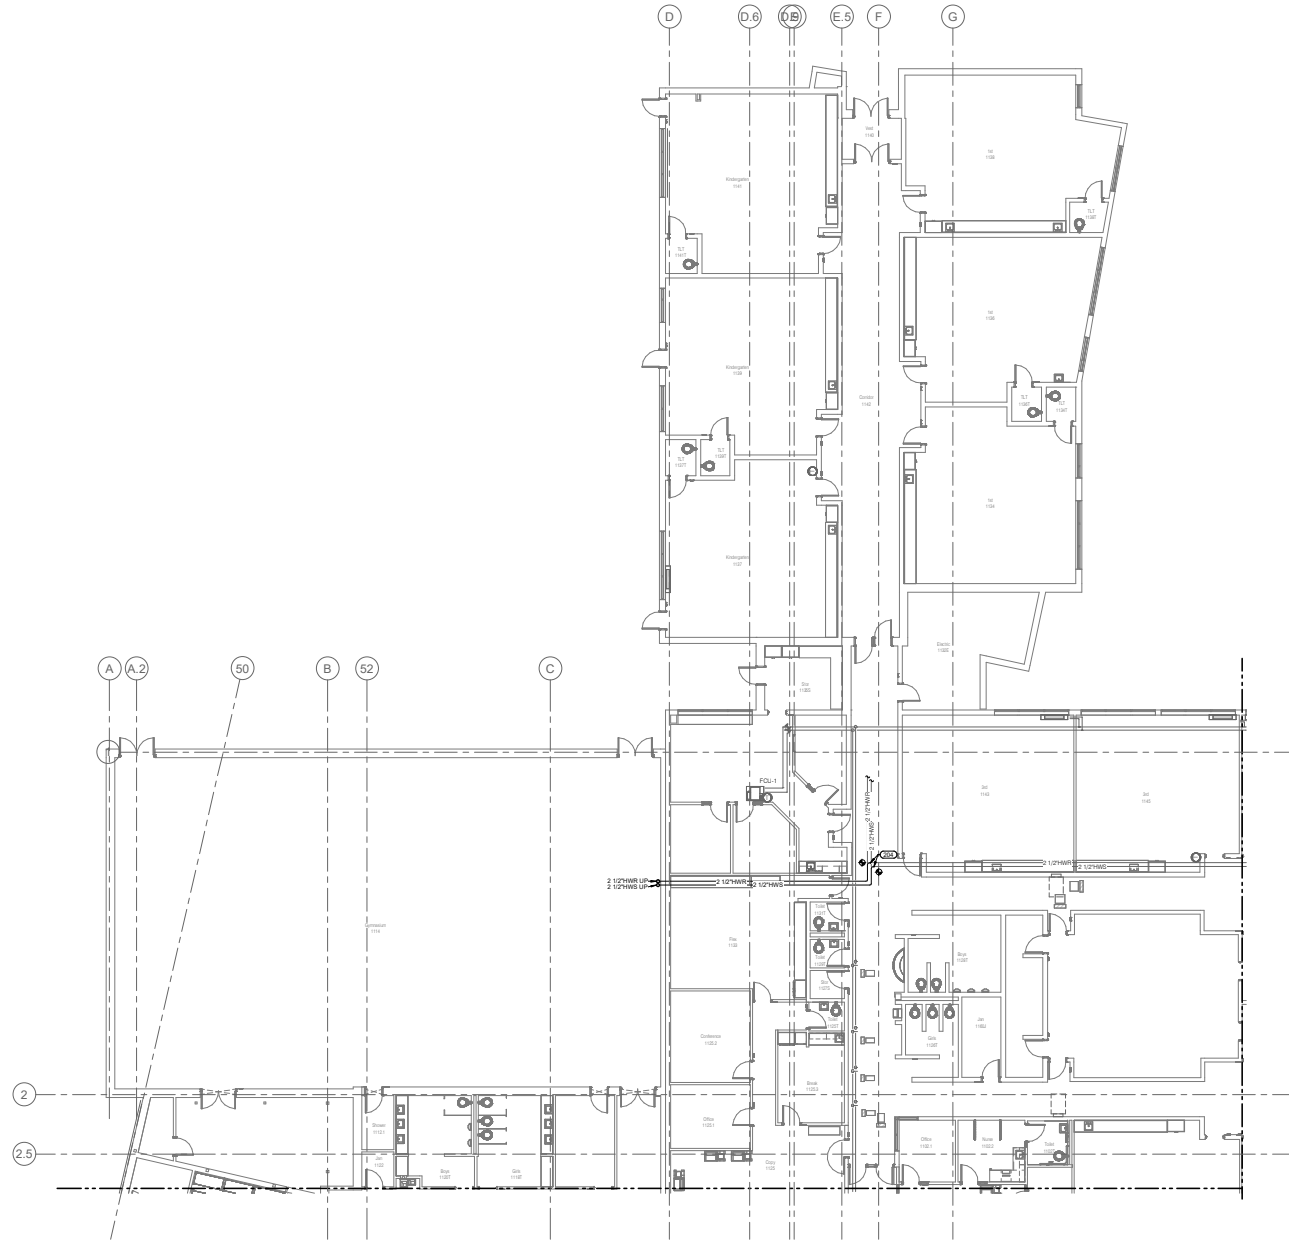

KEYNOTES

 004 ALTERNATE DE. CONNECT TO AND EXTEND EXISTING HWB & HWB PIPING FROM EXISTING SOLDER B-3 AS SHOWN.

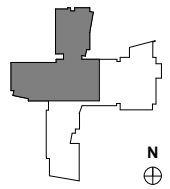

ARCHITECT
Hord Coplan Macht, Inc.
1800 Wacker Street, Suite 450
Denver, CO 80202
P: 303.801.2000
F: 303.801.0767
www.hcmach.com

STRUCTURAL ENGINEER
Academy Group
7800 E. Colfax Avenue, Unit 110
Denver, CO 80231
P: 303.755.4000
www.academygroup.com

MEP ENGINEER
MEG, Corp.
1800 E. Colfax Avenue, Suite 250-B
Greenwood Village, CO 80111
P: 303.755.4000
www.megcorp.com

CIVIL ENGINEER
JVA, Inc.
3475 E. Broadway
Englewood, CO 80113
P: 303.703.4444
www.jva-inc.com

EAST GRAND SCHOOL DISTRICT
Fraser Valley Elementary School
Renovation Summer 2026

hord|coplan|macht
ARCHITECTURE
LANDSCAPE ARCHITECTURE
PLANNING
INTERIOR DESIGN

No.	Date	Revision
00000000	2026/02/11	2026/02/11

Project Name
Fraser Valley Elementary School
Renovation Summer 2026

Project Number
222000.50

Date (YYYYMMDD)
2026/02/11

Drawn By
ABR


Checked By
BHE

Creating
LEVEL 01 PLAN - PIPING - AREA A

M-121A

100% CONSTRUCTION DOCUMENTS


© Hord Coplan Macht, Inc.

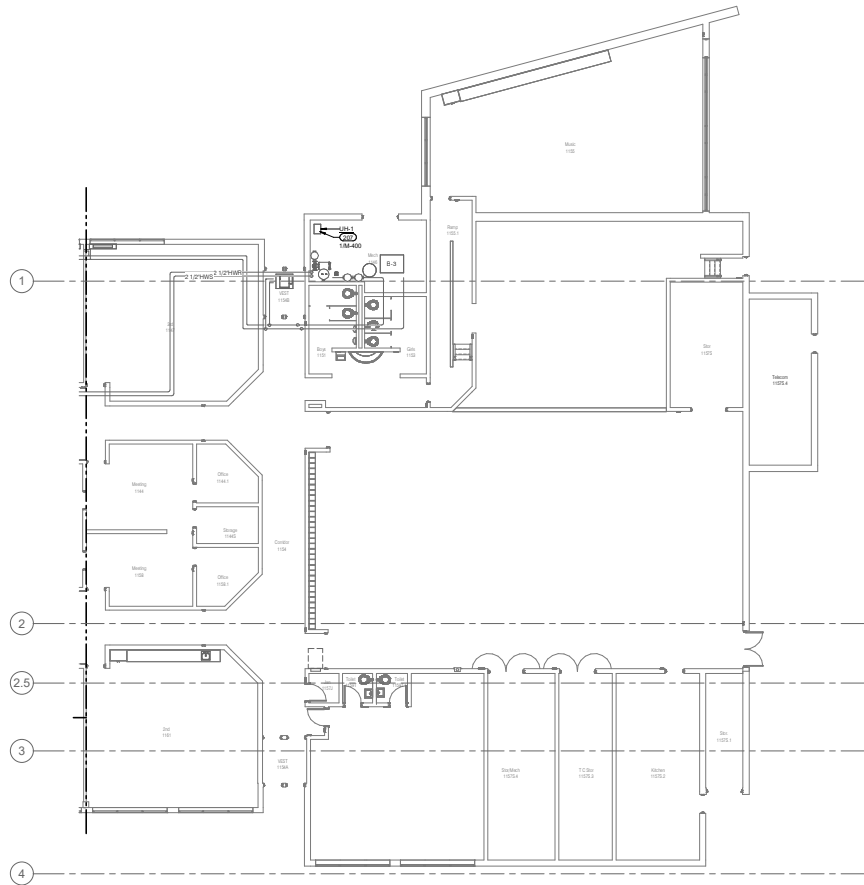

KEYNOTES

07 ALTERNATE OR PROVIDE AND INSTALL HYDRONIC UNIT HEATER. CONNECT INTO NEAREST HOT WATER SUPPLY AND RETURN PIPES. SEE SCHEDULE AND DETAIL.

1 LEVEL 01 PLAN - PIPING - AREA C

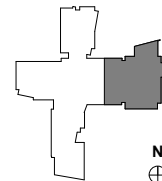

ARCHITECT
Hord Coplan Macht, Inc.
1800 W. 10th Street, Suite 450
Denver, CO 80202
P: 303.807.2000
F: 303.807.0767
www.hcmach.com

STRUCTURAL ENGINEER
Academy Group
1800 W. 10th Street, Suite 450
Denver, CO 80202
P: 303.807.2000
F: 303.807.0767
www.academygroup.com

M/E/P ENGINEER
IMEG Corp.
1800 W. 10th Street, Suite 450
Denver, CO 80202
P: 303.807.2000
F: 303.807.0767
www.imegcorp.com

CIVIL ENGINEER
JVA, Inc.
1800 W. 10th Street, Suite 450
Denver, CO 80202
P: 303.807.2000
F: 303.807.0767
www.jva-inc.com

EAST GRAND SCHOOL DISTRICT
Fraser Valley Elementary School
Renovation Summer 2026

hord | coplan | macht
ARCHITECTURE
LANDSCAPE ARCHITECTURE
PLANNING
INTERIOR DESIGN

No.	Date	Revision
1	02/02/2026	ADDITIONAL 01

Project Name
Fraser Valley Elementary School
Renovation Summer 2026

Project Number
22200.50

Date (YYYYMMDD)
2026/02/11

Drawn By
AJR


Checked By
BME

Creating
LEVEL 01 PLAN - PIPING - AREA C

M-121C

100% CONSTRUCTION
DOCUMENTS

© Hord Coplan Macht, Inc.

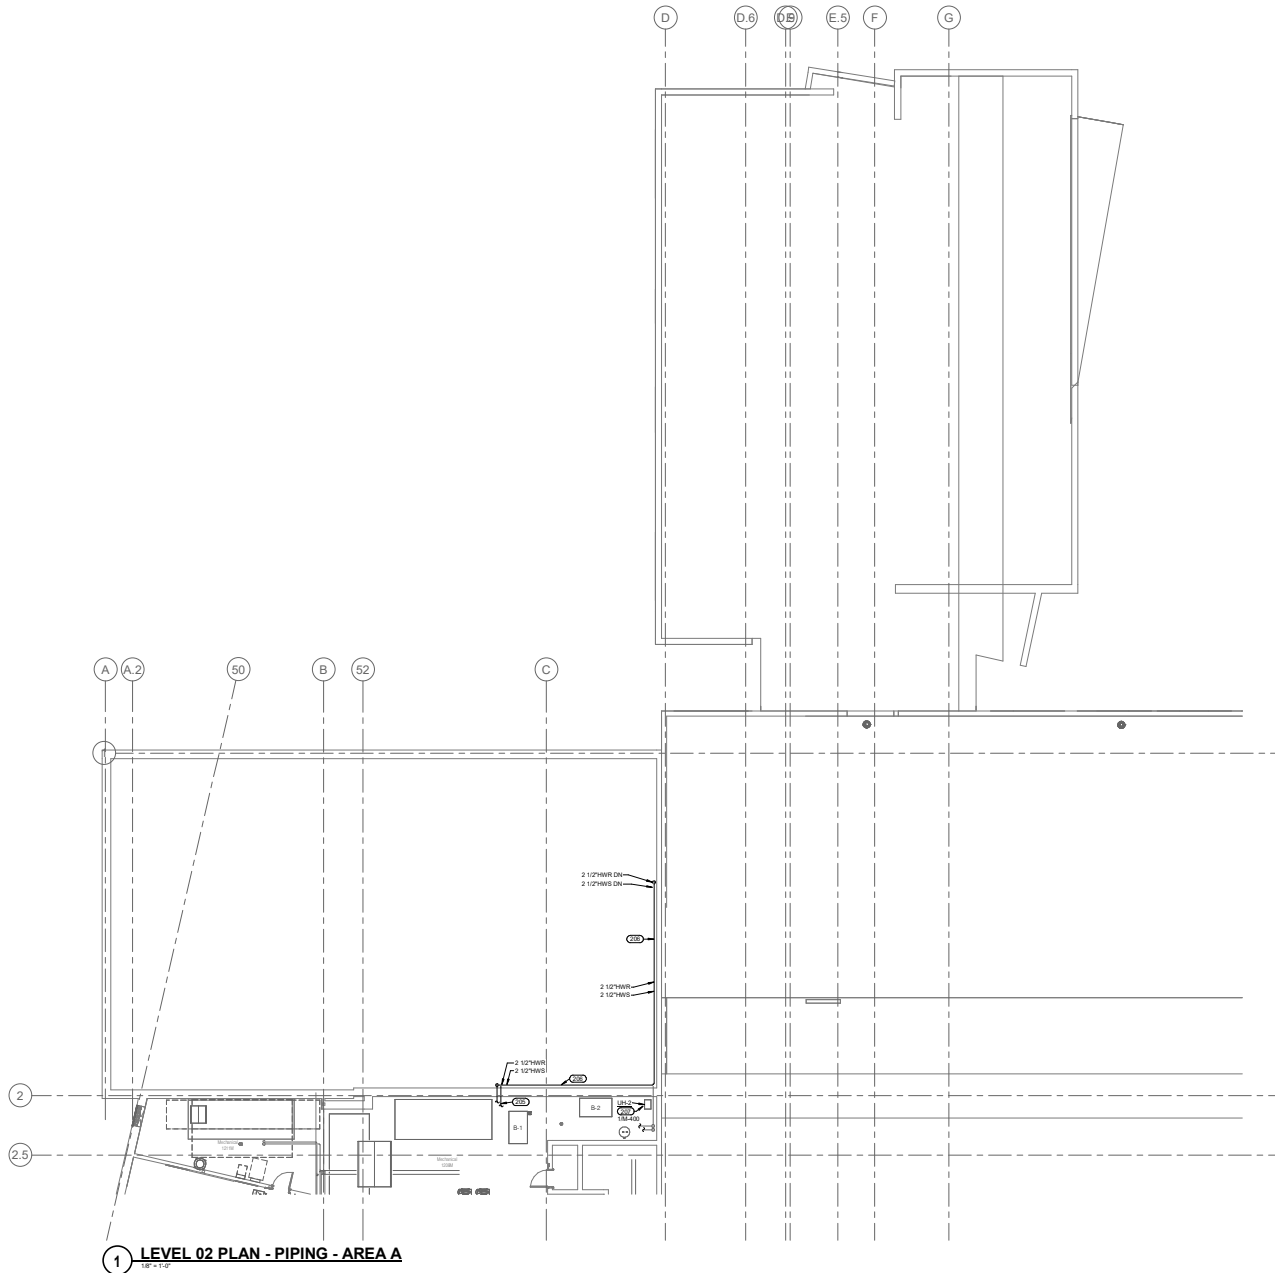


KEYNOTES

105 ALTERNATE SE CONNECT TO NEW LINE & HYD CHANGES VALVES. REFER TO HEATING WATER FLOW AND CONTROL DIAGRAM FOR ADDITIONAL DETAILS.

106 ALTERNATE OR PIPING IN CHIMNEY SHALL BE ROUTED AS HIGH AS POSSIBLE AND SHALL BE ALUMINUM JACKETED WHERE EXPOSED TO PRETECT FROM DAMAGE.

107 ALTERNATE SE PROVIDE AND INSTALL HYDRONIC UNIT HEATER. CONNECT INTO EXISTING HOT WATER SUPPLY AND RETURN PIPES. SEE SCHEDULE AND EST BL.

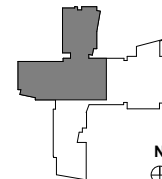

ARCHITECT
Hord Coplan Macht, Inc.
1800 Wacker Street, Suite 450
Denver, CO 80202
P: 303.807.0707
F: 303.807.0767
www.hcmach.com

STRUCTURAL ENGINEER
Bauer Group
7800 E. Tremont Ave., Unit 1-C
Winter Park, CO 80482
P: 303.934.3022
E: bauer@bg.com

MEP ENGINEER
IMEG Corp.
7800 E. Tremont Ave., Suite 250-B
Greenwood Village, CO 80111
P: 303.765.6000
E: imeg@imeg.com

CIVIL ENGINEER
JVA, Inc.
3475 E. Broadway
Englewood, CO 80113
P: 303.703.4444
E: jim@jva.com

EAST GRAND SCHOOL DISTRICT
Fraser Valley Elementary School
Renovation Summer 2026


hord|coplan|macht
ARCHITECTURE
LANDSCAPE ARCHITECTURE
PLANNING
INTERIOR DESIGN

No.	Date	Revision
1	02/02/2026	ADOPTED FOR
Project Name		
Fraser Valley Elementary School		
Renovation Summer 2026		
Project Number		
222000.50		
Date (YYYYMMDD)		
2026/02/11		
Drawn By	Checked By	
ABR	BME	
Creating		
LEVEL 02 PLAN - PIPING - AREA A		

M-122A

100% CONSTRUCTION DOCUMENTS

© Hord Coplan Macht, Inc.

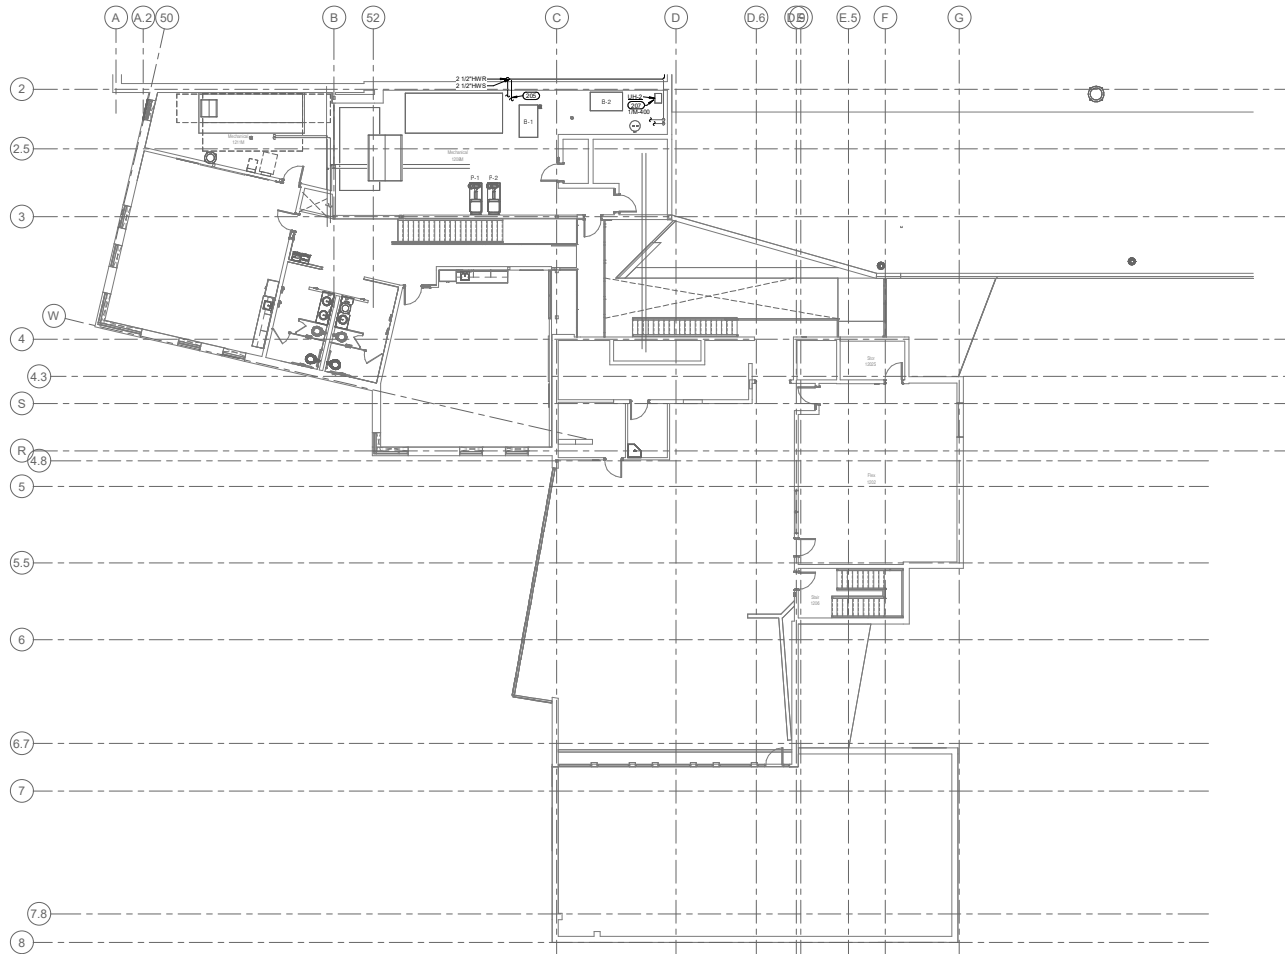

1 LEVEL 02 PLAN - PIPING - AREA B
1/8" = 1'-0"

KEYNOTES

205 ALTERNATE DE. CONNECT TO NEW 1/2\"/>

ADDITIONAL B1

ARCHITECT
Hord Coplan Macht, Inc.
1800 W. 1st Ave., Suite 450
Denver, CO 80202
P: 303.857.1700
F: 303.857.1767
www.hcmach.com

STRUCTURAL ENGINEER
Bentley Group
1800 W. 1st Ave., Suite 450
Denver, CO 80202
P: 303.857.1700
F: 303.857.1767
www.bentleygroup.com

M.E.P. ENGINEER
IMEG Corp.
1800 W. 1st Ave., Suite 450
Denver, CO 80202
P: 303.857.1700
F: 303.857.1767
www.imegcorp.com

CIVIL ENGINEER
JVA, Inc.
1800 W. 1st Ave., Suite 450
Denver, CO 80202
P: 303.857.1700
F: 303.857.1767
www.jva-inc.com

EAST GRAND SCHOOL DISTRICT
Fraser Valley Elementary School
Renovation Summer 2026

hord | coplan | macht
ARCHITECTURE
LANDSCAPE ARCHITECTURE
PLANNING
INTERIOR DESIGN

1	2026/02/11	ADDITIONAL B1
2		
3		
4		
5		
6		
7		
8		

Project Name
Fraser Valley Elementary School
Renovation Summer 2026

Project Number
222000.50

Date (YYYYMMDD)
2026/02/11

Drawn By
AJR

Checked By
BME

Creating
LEVEL 02 PLAN - PIPING - AREA B

M-122B

100% CONSTRUCTION DOCUMENTS

© Hord Coplan Macht, Inc.

1. REFER TO THE SPECIFICATIONS FOR TYPE DESCRIPTIONS AND JACKETING REQUIREMENTS. VALUES LISTED BELOW ARE BASED ON 2021 ECC REQUIREMENTS.
2. TYPE A INSULATION IS NOT ALLOWED IN NON-AIR CONDITIONED SPACES, SUCH AS MECHANICAL ROOMS, EXTERIOR, ATTICS, ETC.
3. TYPE B INSULATION GREATER THAN 1" THICK SHALL BE INSTALLED USING MULTIPLE LAYERS OF 3/4" OR 1" WITH STaggered SEAMS.
4. PROVIDE RIGID BUILT AT HANGERS, OTHER PRE-MANUFACTURED COUPLINGS (REFER TO PIPE HANGING AND SUPPORTS SPECIFICATIONS) OR TYPE C, D, OR E INSULATION. SEE SPEC. FOR MORE DETAILS.

PIPE SYSTEM	INSULATION TYPE	INSULATION THICKNESS PER NOMINAL PIPE OR TUBE SIZE				NOTES
		< 1"	1" TO < 1.5"	1.5" TO < 4"	4" TO < 8"	
21 PPRG - HEATING						
HWIR - HEATING WATER RETURN	A (Glasfrit), C (Cork/Isol), E (Polym), F (Phenol)	1.5"	1.5"	2"	2"	
HWIS - HEATING WATER SUPPLY	A (Glasfrit), C (Cork/Isol), E (Polym), F (Phenol)	1.5"	1.5"	2"	2"	

NOTES:
1. 30% PROPYLENE GLYCOL

2. ALTERNATE 06																						
TAG		LOCATION			CFM	COOL				ELECTRICAL						MAXIMUM DIMENSIONS						
NAME	NAME	NO.	ALTITUDE	ARRANGEMENT	DESIGN	FLUID / GLYCOL %	GPM	ENT %	WLT %	VOLTS/PH	FLA	DISCONNECT	BY (A)	TYPE (B)	BY (A)	SCCR	LENGTH	WIDTH	HEIGHT	MANUFACTURER	MODEL	NOTES
UP-1	MECHANICAL	1148	8800	VERTICAL	340	WATER / 30% PG	9	0.7	180	120 V	1	0.8 A	MFR	NF	MFR	5,000 A	1'-11"	11"	1'-0"	MOORE	HC16	1.2
UP-2	MECHANICAL	1208	8800	VERTICAL	340	WATER / 30% PG	9	0.7	180	120 V	1	0.8 A	MFR	NF	MFR	5,000 A	1'-11"	11"	1'-0"	MOORE	HC16	1.2

ARCHITECT
Hard Coplan Macth, Inc.
1800 Wazee Street, Suite 450
Denver, CO 80202
p. 303.687.0977
f. 303.687.0767

STRUCTURAL ENGINEER
Ascent Group
79050 US Highway 40, Unit 1C
Winter Park, CO 80482
p. 303.460.3622
w. ascntgip.com

M/E/P ENGINEER
IMEG, Corp.
7600 E. Orchard Road, Suite 250-S
Greenwood Village, CO 80111
p. 303.796.8500
w. imegcorp.com

CIVIL ENGINEER
JVA, Inc.
3473 S Broadway
Englewood, CO 80113
p. 303.703.4444
w. livejoycore.com

EAST GRAND SCHOOL DISTRICT
Fraser Valley Elementary School
Renovation Summer 2026

hord | coplan | machi
ARCHITECTURE
LANDSCAPE ARCHITECTURE
PLANNING
INTERIOR DESIGN

125 Eastom Ave
Fraser, CO 80442

1	03/05/2026	ADDENDUM 01

Project Name
Fraser Valley Elementary School
Renovation Summer 2026

Project Number
222000.50

Date (YYYY/MM/DD)
2026/02/11

Drawn By _____ Checked By _____
ABR BRE
Drawing _____
MECHANICAL SCHEDULES


M-601

100% CONSTRUCTION
DOCUMENTS

© Hord Coplan Macht, Inc.



3/5/2026 12:24:46 AM
Ascent: Drive C:\222000.50 Fraser Valley Elementary School\N17P2_25040815_04_1st Grand SD Fraser Valley
17P25040815_04_1st Grand SD Fraser Valley

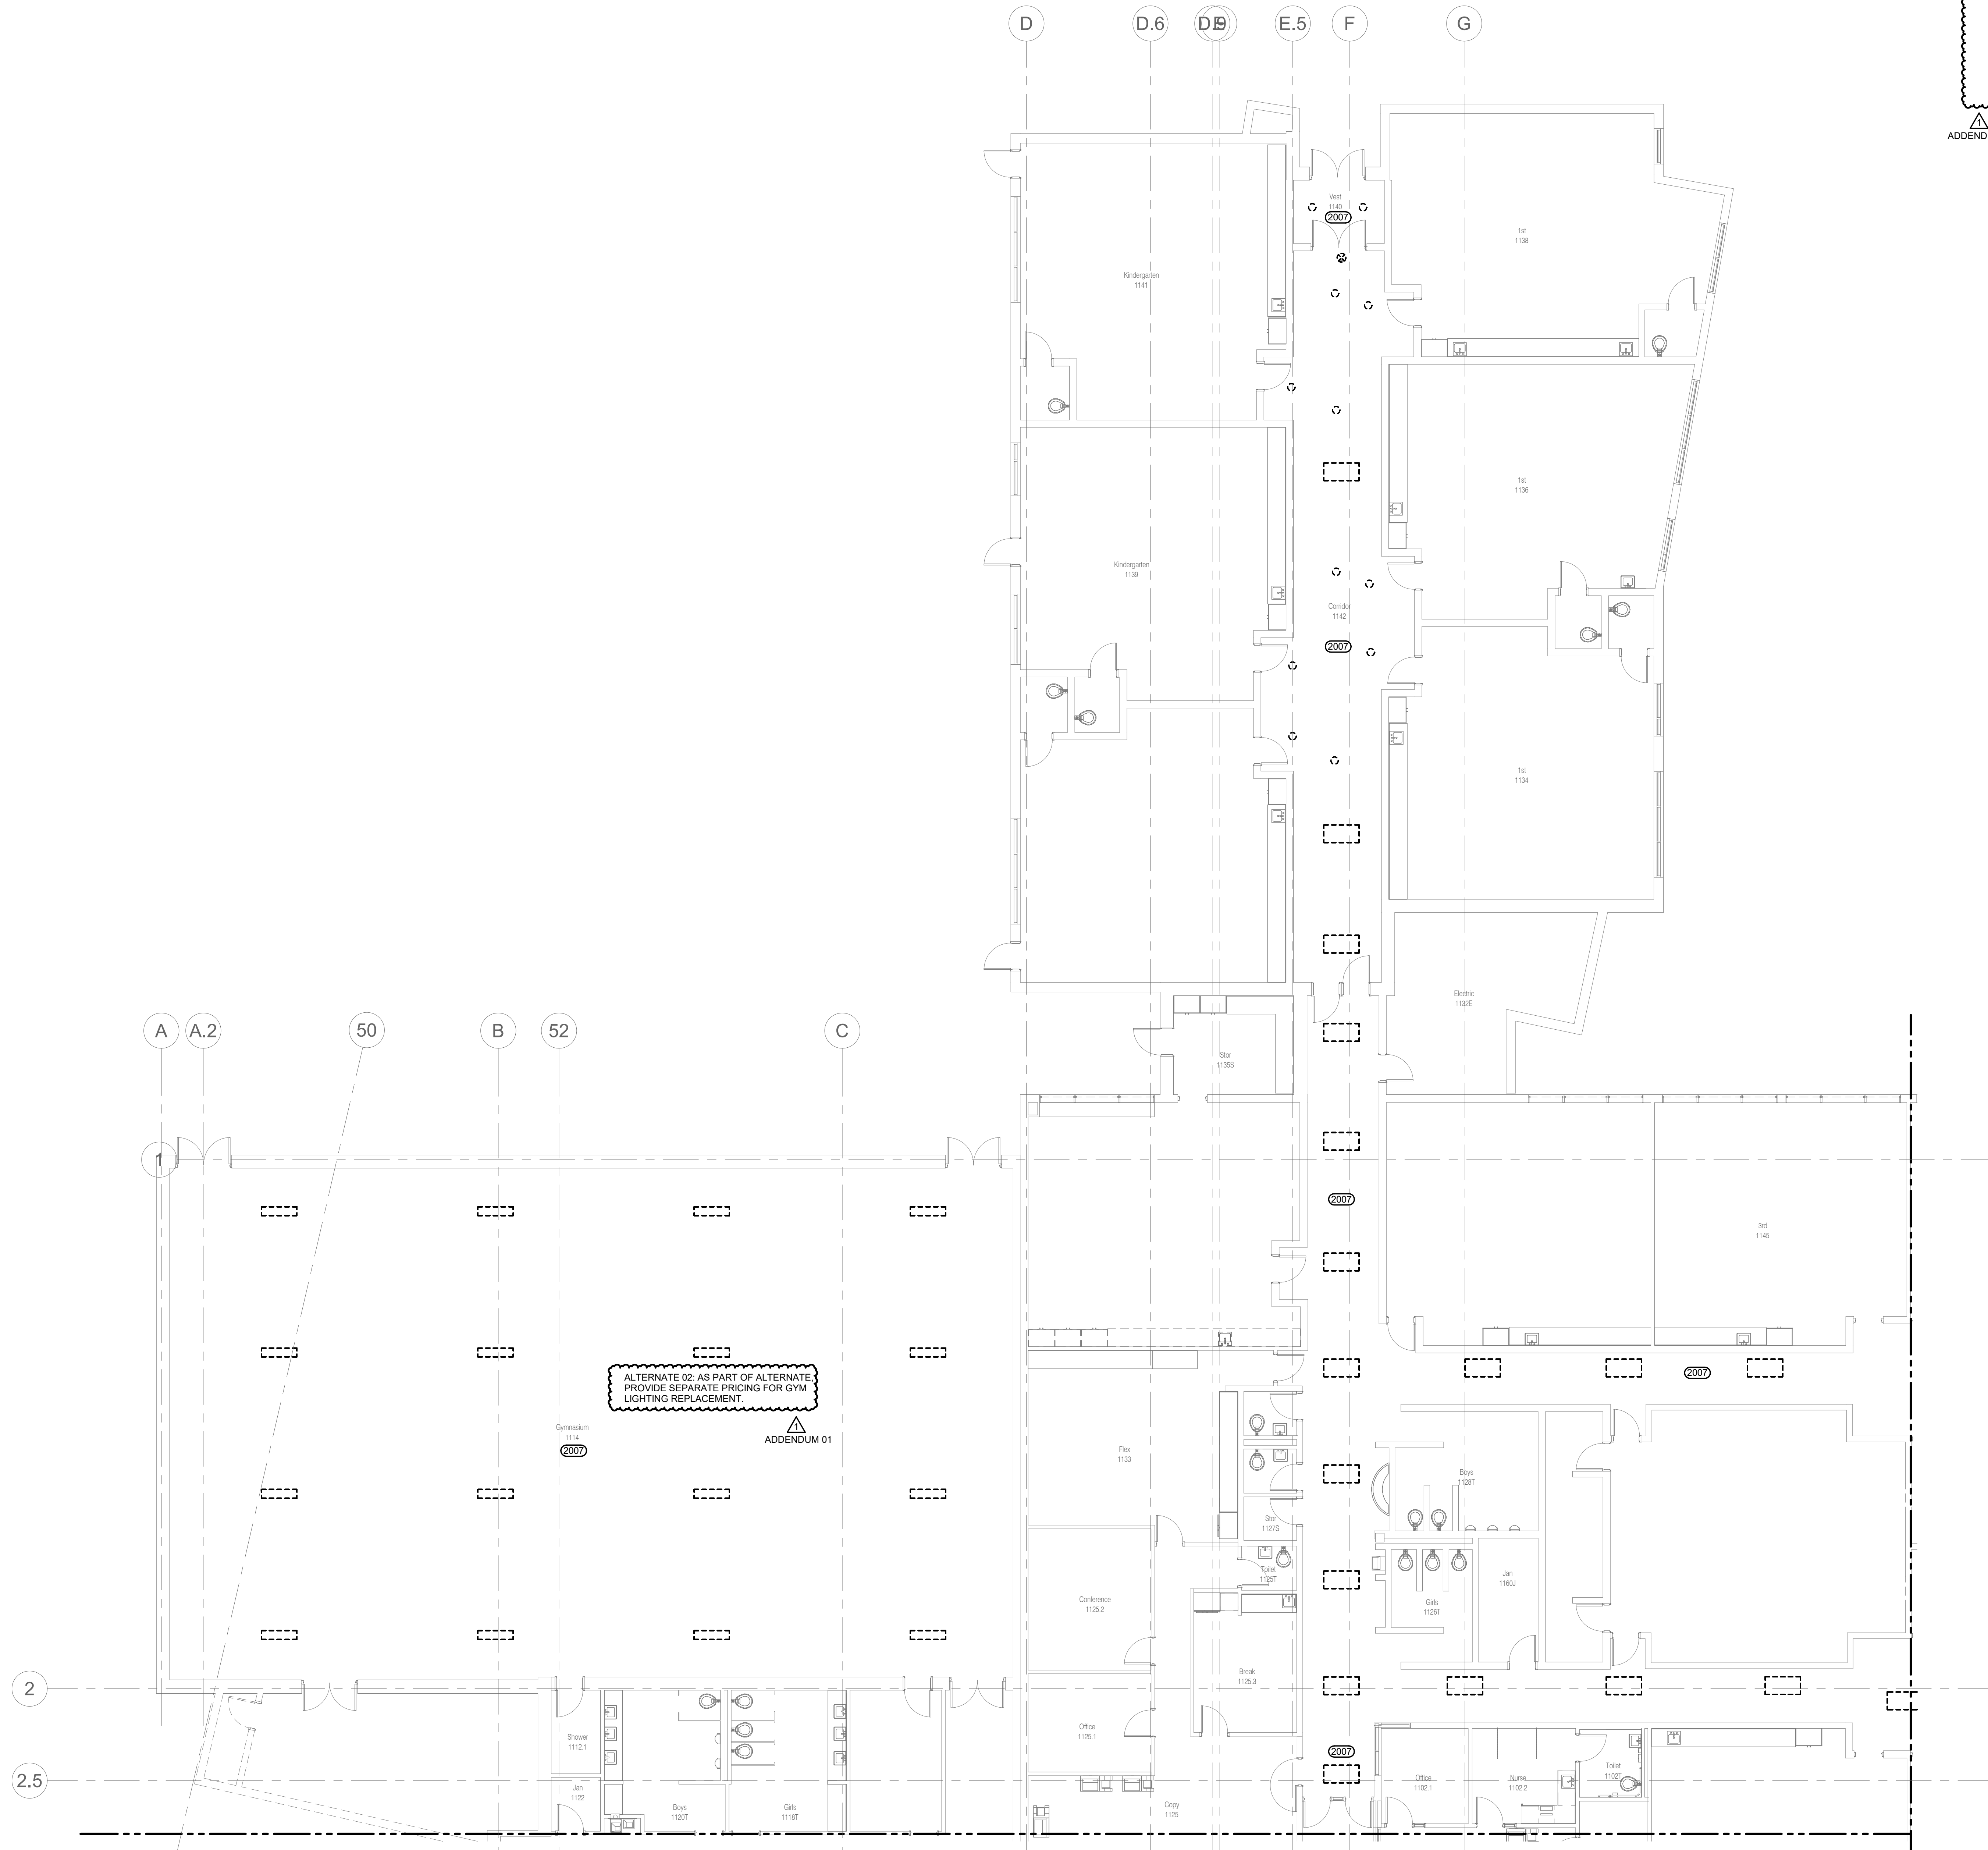

ELECTRICAL DEMOLITION GENERAL NOTES:

1. ALTERNATE 02: ALL LABOR AND MATERIALS RELATED TO LIGHTING REPLACEMENT SHALL BE SEPARATED AS AN ALTERNATE SCOPE OF WORK. PROVIDE SEPARATE PRICING FOR SCHOOL DISTRICT REVIEW.
2. SAVE AND PROTECT EXISTING LIGHTING CIRCUITS FOR RE-USE.

ADDENDUM 01
2007

KEYNOTES

REMOVE EXISTING LIGHTING IN THIS ROOM/SPACE. EXISTING LIGHTING CIRCUIT TO BE REUSED FOR NEW LED LIGHTING. REMOVE ASSOCIATED LIGHTING CONTROL DEVICES BUT SAVE AND PROTECT HOMERUN. SEE REMODEL PLANS FOR NEW FIXTURE LOCATIONS.

EAST GRAND SCHOOL DISTRICT Fraser Valley Elementary School Renovation Summer 2026

125 Eastom Ave
Fraser, CO 80442


hord | coplan | macht

ARCHITECTURE
LANDSCAPE ARCHITECTURE
PLANNING
INTERIOR DESIGN



No.	Date	Revision
1	03/05/2026	ADDENDUM 01

Project Name
Fraser Valley Elementary School
Renovation Summer 2026

Project Number
222000.50
Date (YYYY/MM/DD)
2026/02/11
Drawn By
AGG
Checked By
JMN
Drawing
LEVEL 01 DEMOLITION PLAN -
LIGHTING - AREA A

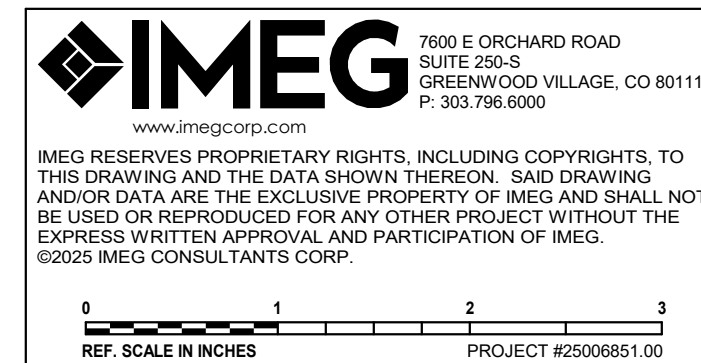

100% CONSTRUCTION
DOCUMENTS

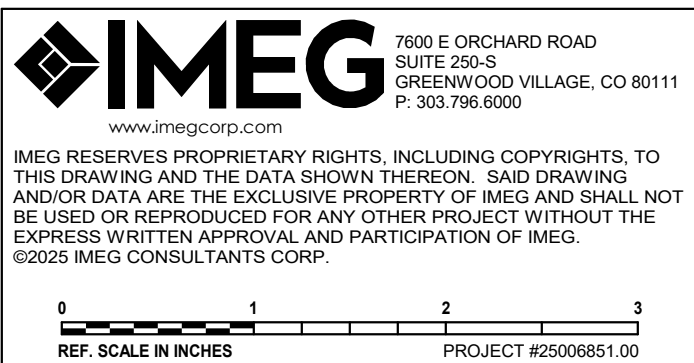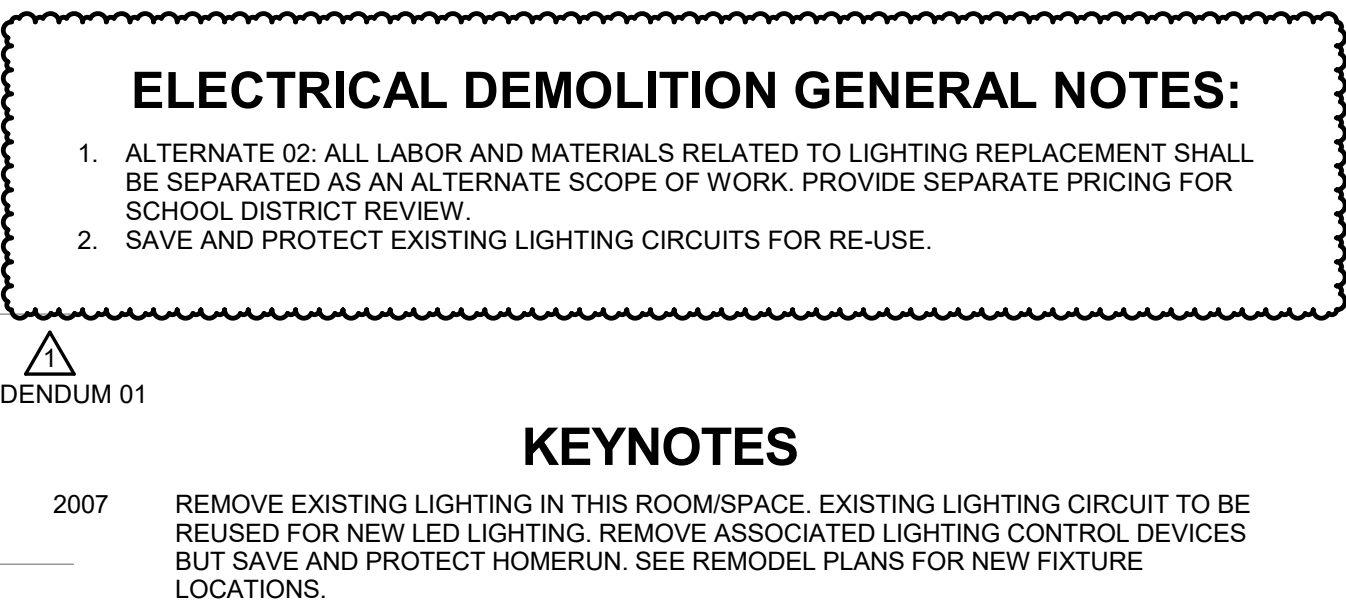

ARCHITECT
Lord Coplan Macht, Inc.
800 Wazee Street, Suite 450
Denver, CO 80202
v. 303.607.0377
303.607.0767

STRUCTURAL ENGINEER
Ascent Group
9050 US Highway 40, Unit 1C
Vinter Park, CO 80482
v. 303.499.9022
v. ascentgrp.com

E/E/P ENGINEER
IMEG, Corp.
600 E. Orchard Road, Suite 250-S
Greenwood Village, CO 80111
303.796.6000
v. imegcorp.com

CIVIL ENGINEER
IVA, Inc.
1473 S Broadway
Greenwood, CO 80113
303.703.4444
v. liveyourcore.com

Fraser Valley Elementary School
Renovation Summer 2026

125 Eastom Ave
Fraser, CO 80442

nord | coplan | macht
ARCHITECTURE
LANDSCAPE ARCHITECTURE
PLANNING
INTERIOR DESIGN

1	03/05/2026	ADDENDUM 01
No.	Date	Revision

Project Name
Fraser Valley Elementary School
Renovation Summer 2026

Project Number
222000.50

Date (YYYY/MM/DD)
2026/02/11

Drawn By
JAGG

Checked By
JMN

Drawing
LEVEL 01 DEMOLITION PLAN -
LIGHTING - AREA B

ED-121B

100% CONSTRUCTION
DOCUMENTS

Hord Coplan Macht, Inc.

Fraser Valley Elementary School
Renovation Summer 2026

1	03/05/2026	ADDENDUM 01
No.	Date	Revision

Project Number
22000.50

Drawn By: JMN
Checked By: JMN

ED 404 000


100% CONSTRUCTION DOCUMENTS


Hord Coplan Macht, Inc.

1. ALTERNATE 02: ALL LABOR AND MATERIALS RELATED TO LIGHTING REPLACEMENT SHALL BE SEPARATED AS AN ALTERNATE SCOPE OF WORK. PROVIDE SEPARATE PRICING FOR SCHOOL DISTRICT REVIEW.
2. SAVE AND PROTECT EXISTING LIGHTING CIRCUITS FOR RE-USE.

2007 REMOVE EXISTING LIGHTING IN THIS ROOM/SPACE. EXISTING LIGHTING CIRCUIT TO BE REUSED FOR NEW LED LIGHTING. REMOVE ASSOCIATED LIGHTING CONTROL DEVICES BUT SAVE AND PROTECT HOMERUN. SEE REMODEL PLANS FOR NEW FIXTURE LOCATIONS.

 ADDENDUM 01

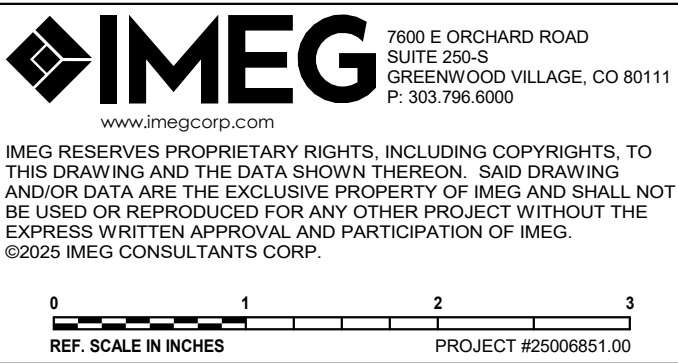

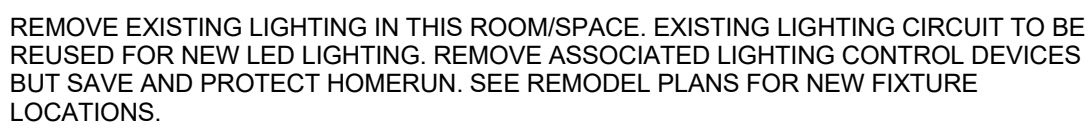

© Hord Coplan Macht, Inc.



IMEG

www.imegcorp.com

7600 E ORCHARD ROAD
SUITE 250-S
GREENWOOD VILLAGE, CO 80111
P: 303.738.6000

IMEG RESERVES PROPRIETARY RIGHTS, INCLUDING COPYRIGHTS. TO THE DRAWING AND THIS DATA SHOW THE DESIGN. SAID DRAWING AND/OR DATA ARE THE EXCLUSIVE PROPERTY OF IMEG AND SHALL NOT BE USED OR REPRODUCED FOR ANY OTHER PROJECT WITHOUT THE EXPRESS WRITTEN APPROVAL AND PARTICIPATION OF IMEG.

©2025 IMEG CONSULTANTS CORP.



REF. SCALE IN INCHES



PROJECT #25006851.00

1. ALTERNATE 02: ALL LABOR AND MATERIALS RELATED TO LIGHTING REPLACEMENT SHALL BE SEPARATED AS AN ALTERNATE SCOPE OF WORK. PROVIDE SEPARATE PRICING FOR SCHOOL DISTRICT REVIEW.
2. EC TO WIRE NEW LIGHTING AND LIGHTING CONTROL DEVICES TO EXISTING SAVED CIRCUITS. LOAD ADDED IS LESS THAN LOAD REMOVED. PROVIDE MULTI-VOLT DRIVERS FOR ALL FIXTURE TYPES, AND FIELD VERIFY CIRCUIT CHARACTERISTICS PRIOR TO START OF WORK.
3. ALL EXIT SIGNS TO BE CIRCUITED AHEAD OF LOCAL CONTROLS.

ARCHITECT
Hort Coplan Macht, Inc.
1800 Wazee Street, Suite 450
Denver, CO 80202
p. 303.607.0977
f. 303.607.0767

STRUCTURAL ENGINEER
Ascent Group
79050 US Highway 40, Unit 1C
Winter Park, CO 80482
p. 303.499.3022
w. ascentgrp.com

M/E/P ENGINEER
IMEG, Corp.
7600 E. Orchard Road, Suite 250-S
Greenwood Village, CO 80111
p. 303.696.8800
w. imegcorp.com

CIVIL ENGINEER
JVA, Inc.
3473 S Broadway
Englewood, CO 80113
p. 303.703.4444
w. liveyeysource.com

EAST GRAND SCHOOL DISTRICT
Fraser Valley Elementary School
Renovation Summer 2026

125 Eastom Ave
Fraser, CO 80442

ARCHITECTURE
LANDSCAPE ARCHITECTURE
PLANNING
INTERIOR DESIGN

[illegible]

Project Name	Fraser Valley Elementary School Renovation Summer 2026
--------------	---

Project Number
222000 50Date (YYYY/MM/DD)
2026/02/11

Drawn By _____ Checked By _____
AGG .JMN


Drawing


 
LEVEL 01 PLAN - LIGHTING -
AREA A

E-121A

100% CONSTRUCTION
DOCUMENTS

© Hord Coplan Macht, Inc.

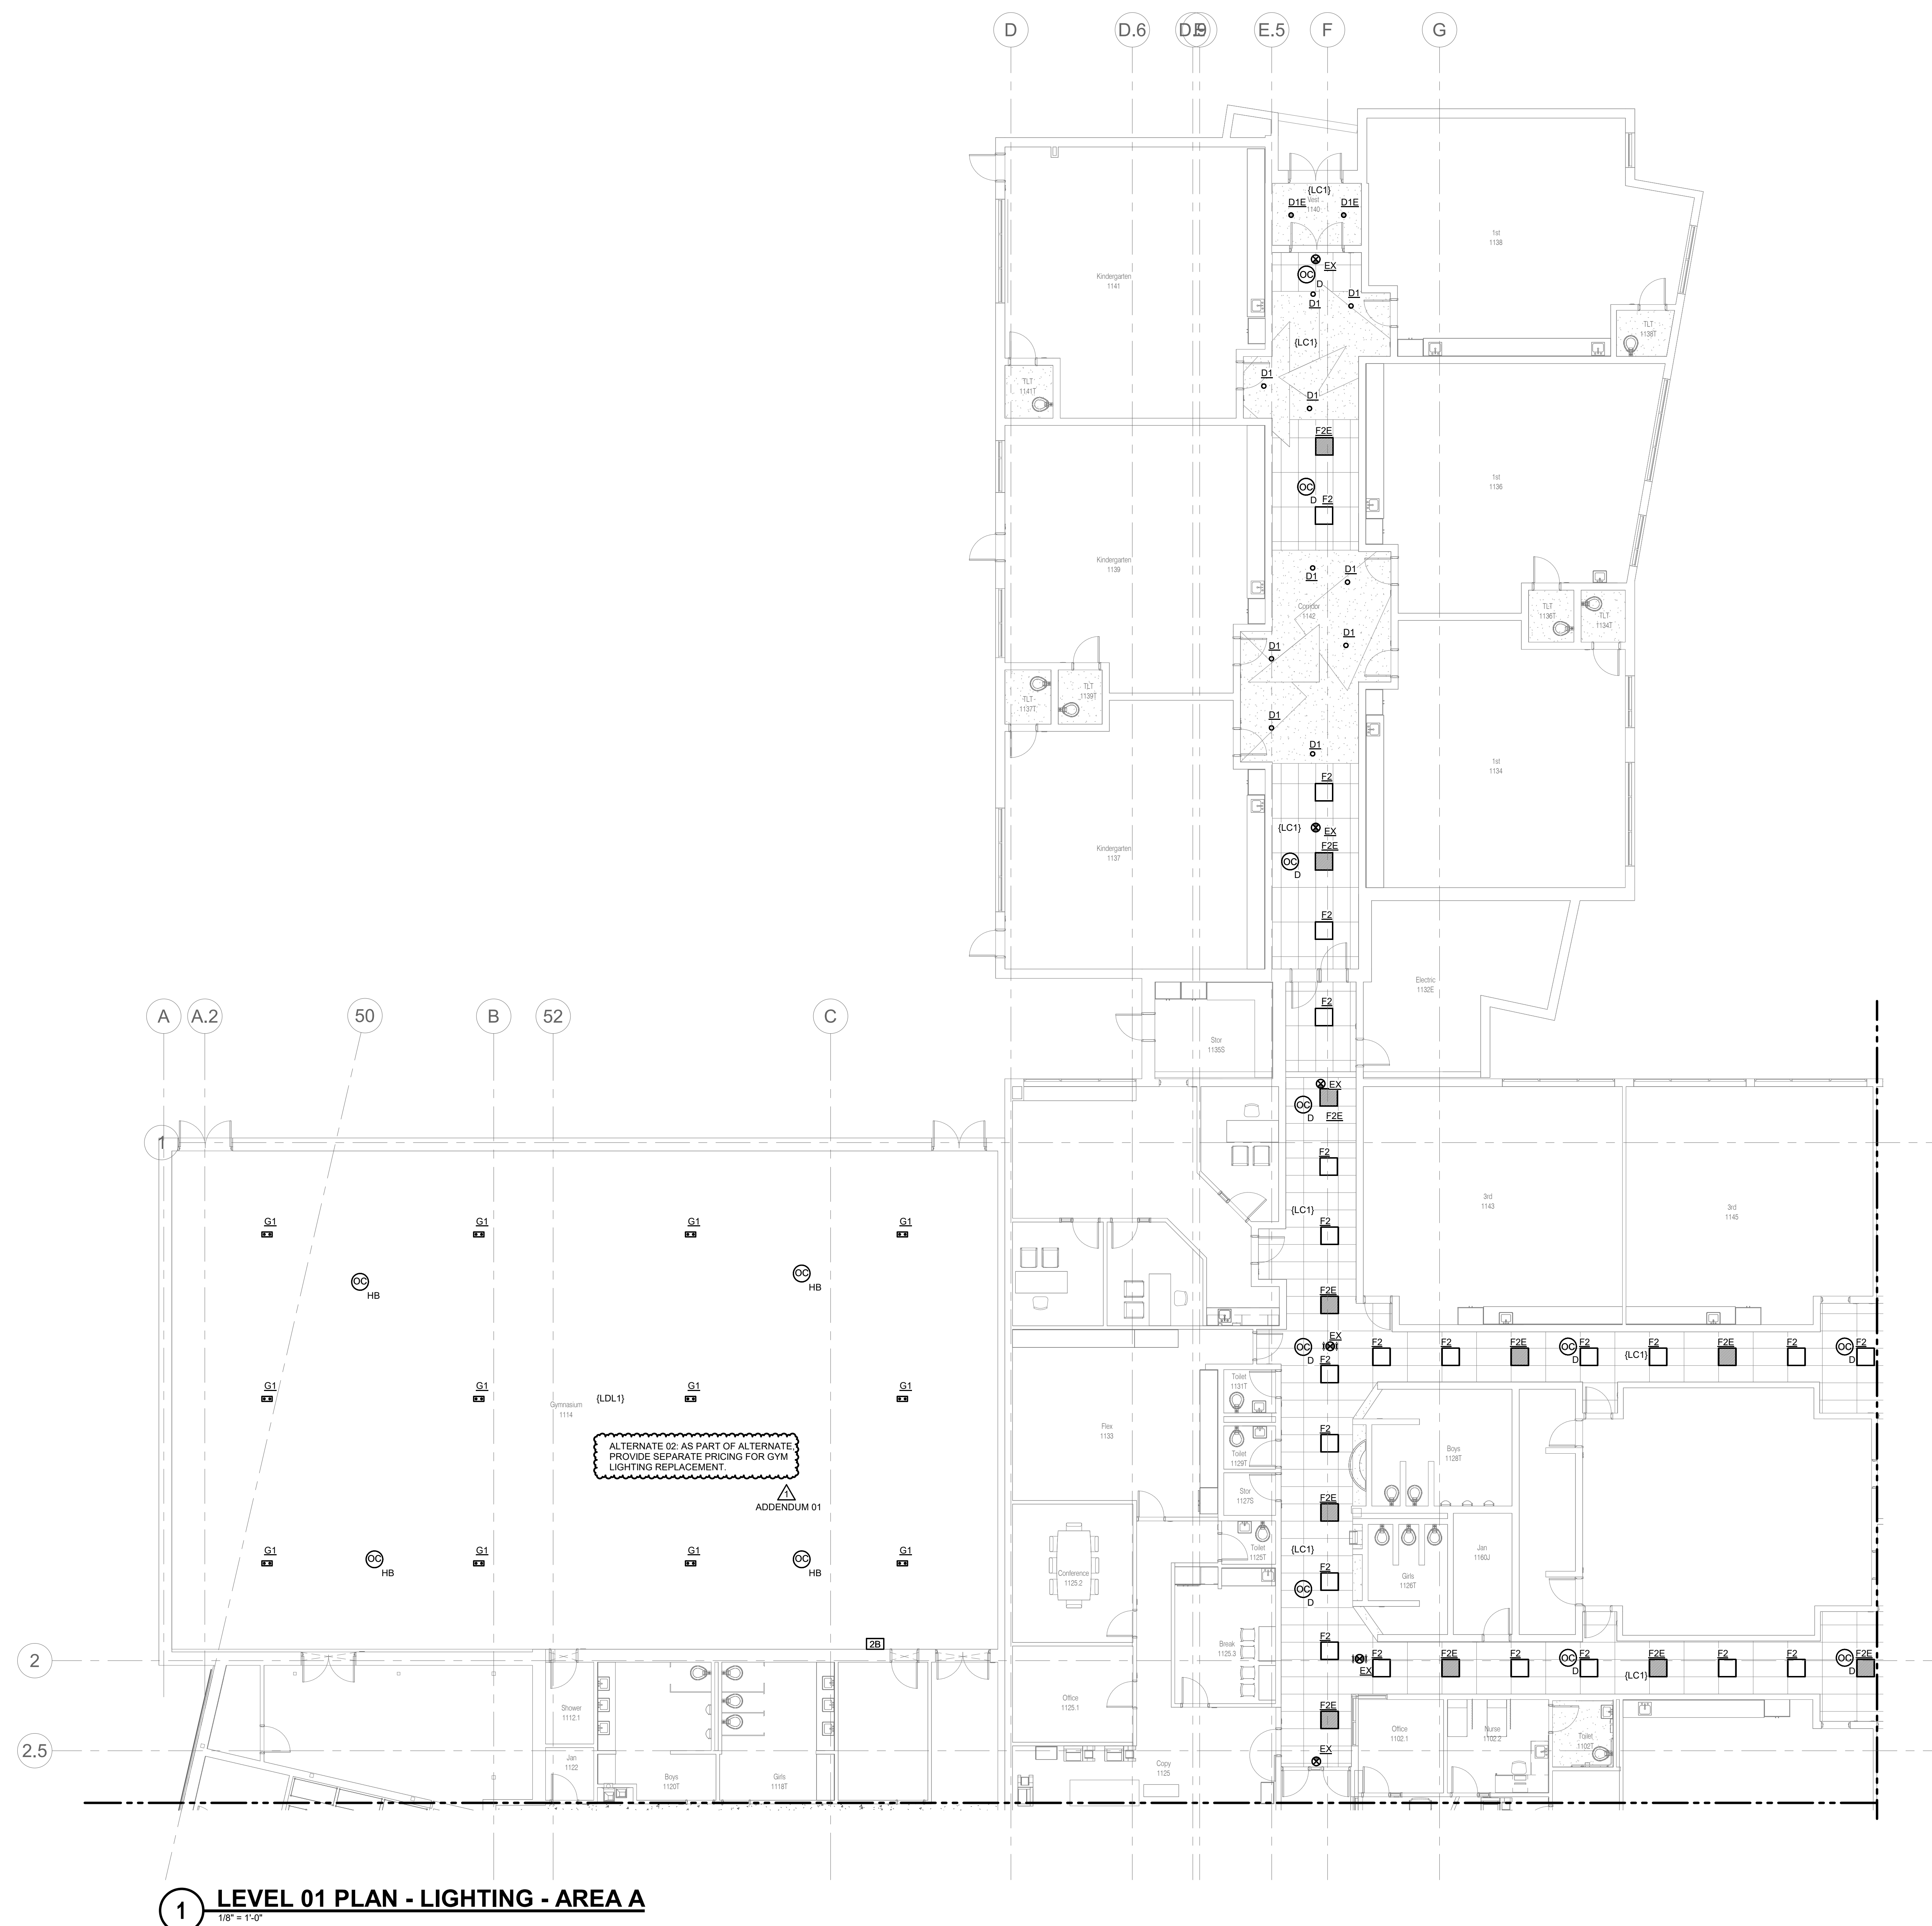

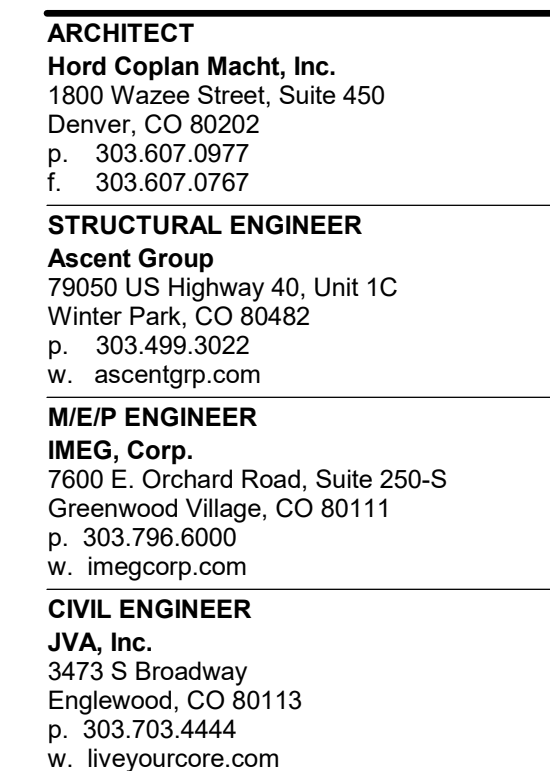

EAST GRAND SCHOOL DISTRICT
Fraser Valley Elementary School
Renovation Summer 2026

125 Eastom Ave
Fraser, CO 80442

hord | coplan | macht

ARCHITECTURE
LANDSCAPE ARCHITECTURE
PLANNING
INTERIOR DESIGN

1	03/05/2026	ADDENDUM 01
No.	Date	Revision

Project Name
Fraser Valley Elementary School
Renovation Summer 2026

Project Number	
222000.50	
Date (YYYY/MM/DD)	
2026/02/11	
Drawn By	Checked By
AGG	JMN
Drawing	
LEVEL 01 PLAN - LIGHTING - AREA B	

E-121B

100% CONSTRUCTION
DOCUMENTS

© Hord Coplan Macht, Inc.


125 Eastom Ave
Fraser, CO 80442



ord | coplan | macht
ARCHITECTURE
LANDSCAPE ARCHITECTURE
PLANNING
INTERIOR DESIGN

E-121C

© Hord Coplan Macht, Inc.

 ADDENDUM 01

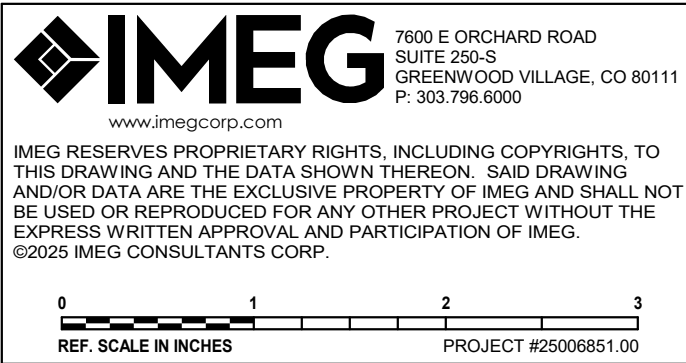

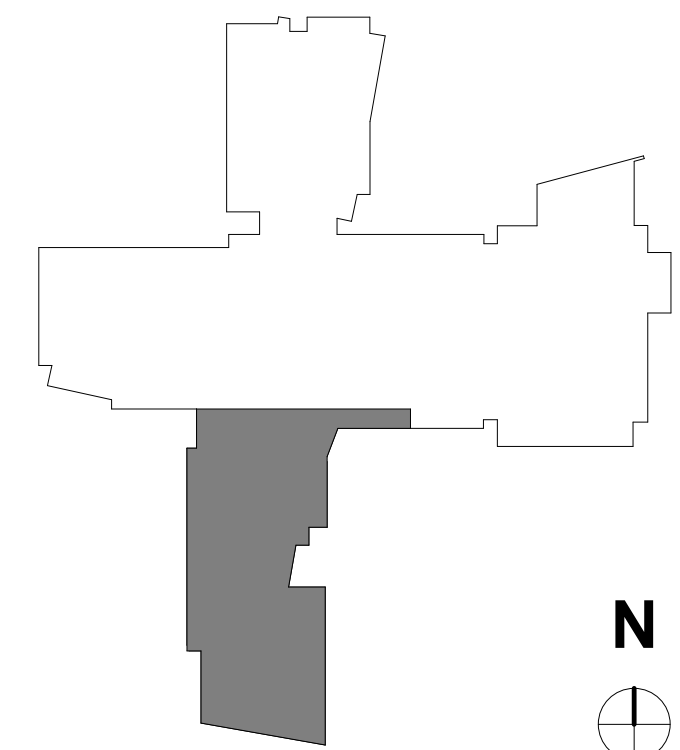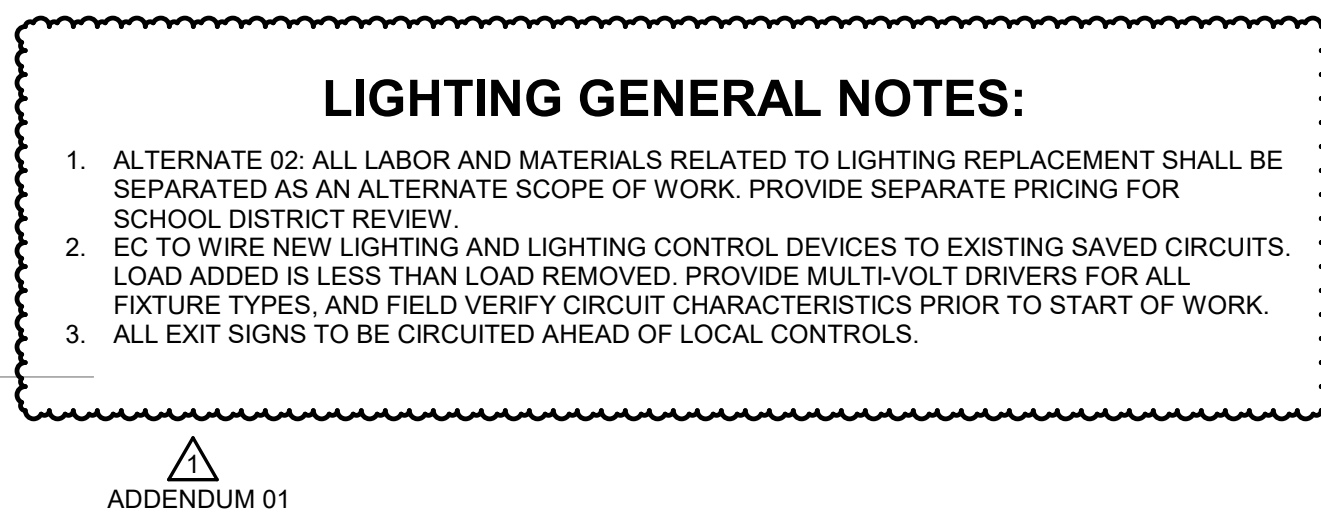

MEG 7600 E ORCHARD ROAD
SUITE 2050
GREENWOOD VILLAGE, CO 801
P: 303.796.6000
www.mmeg.com

MEG RESERVES PROPRIETARY RIGHTS, INCLUDING COPYRIGHTS, TO THE DRAWING AND THE DATA SHOWN THEREON. SAO DRAWING AND/OR DATA ARE THE EXCLUSIVE PROPERTY OF MEG AND SHALL NOT BE USED OR REPRODUCED FOR ANY OTHER PROJECT WITHOUT THE EXPRESS WRITTEN APPROVAL AND PARTICIPATION OF MEG.
©2025 MEG CONSULTANTS CORP.

REF. SCALE IN INCHES PROJECT #2500851.00

ARCHITECT
Hord Coplan Macht, Inc.
1800 Wazee Street, Suite 450
Denver, CO 80202
p. 303.607.0277
f. 303.607.0767

STRUCTURAL ENGINEER
Ascent Group
79050 US Highway 40, Unit 1C
Winter Park, CO 80482
p. 303.499.9022
w. ascentgrp.com

M/E/P ENGINEER
IMEG, Corp.
7600 E. Orchard Road, Suite 250-S
Greenwood Village, CO 80111
p. 303.795.6000
w. imegcorp.com

CIVIL ENGINEER
JVA, Inc.
3473 S Broadway
Englewood, CO 80113
p. 303.703.4444
w. liveyourcure.com

EAST GRAND SCHOOL DISTRICT
Fraser Valley Elementary School
Renovation Summer 2026

125 Eastom Ave
Fraser, CO 80442

hord | coplan | macht

ARCHITECTURE
LANDSCAPE ARCHITECTURE
PLANNING
INTERIOR DESIGN

1	03/05/2026	ADDENDUM 01
No.	Date	Revision

Project Name
Fraser Valley Elementary School
Renovation Summer 2026

Project Number
222000.50

Date (YYYY/MM/DD)
2026/02/11

Drawn By Checked By
AGG JMN

Drawing
LEVEL 02 PLAN - LIGHTING -
AREA B

E-122B

100% CONSTRUCTION
DOCUMENTS

© Hord Coplan Macht, Inc.

3/5/2026 8:00:07 AM
Ascent4-Docs\222000.50 Fraser Elementary School\NTP2_22040881_04_Inst-Grand-SD- Fraser_Valley
E-600.dwg_Cut

LIGHTING SEQUENCE OF OPERATION

NOTES: 1. [L##] DENOTES THE LIGHTING SEQUENCE OF OPERATIONS FOR THIS SPACE. 2. [R#] PUSH BUTTON REFERS TO SCENE QUANTITY. CONTROL STATION SHALL BE CAPABLE OF [RAISE/LOWER AND] SWITCHING ON/OFF FOR MULTIPLE SCENES AS INDICATED ON SHEETS AND THE LIGHTING SEQUENCE OF OPERATIONS (L##). 3. [Z#] DENOTES LIGHTING CONTROL ZONE. PROVIDE SEPARATE CONTROL OF EACH CONTROLLED ZONE. LUMINAIRES ASSOCIATED WITH THE SAME ZONE SHALL OPERATE TOGETHER WITHIN THE SAME PROGRAMMED SCENE. 4. a = SWITCH DESIGNATION FOR LIGHTING CONTROL. 5. VERIFY AND COORDINATE ALL TIME CLOCK SETTINGS WITH OWNER PRIOR TO FINAL PROGRAMMING. 6. VERIFY AND COORDINATE ALL PUSH BUTTON WALL DEVICES AND QUANTITIES OF INDIVIDUAL BUTTONS WITH SCENES AND ZONES PER LOCATION. 7. VERIFY AND COORDINATE ALL PUSH BUTTON QUANTITIES AND SCENE NAMES WITH OWNER PRIOR TO SUBMITTING ENGRAVING TEMPLATE TO MANUFACTURER.	
PLAN ID	LIGHTING SWITCHED
(LC1)	Sequence: Switched lights are controlled in this space. ON: The normal lights turn on by the central schedule. OFF: A scheduled sweep will turn lights off. The Master Lighting Control station will provide a 120 minute override. The occupancy sensor will provide a 15 minute override.
(LDL1)	Sequence: Dimmed lights are controlled in this space. ON: The lights turned on using a wall control or central schedule. ADJUST: The dimming luminaires are raised /lowered using a controller. Dimmable lights within the daylight zone will continuously adjust to the presence of daylight to maintain 50 foot-candles at +30". When the daylight target has exceeded 75footcandles, the luminaires shall completely shut off. OFF: The lights turn off using a wall controller or a scheduled sweep will turn lights off. The Master Lighting Control station will provide a 120 minute override. The occupancy sensor will provide a 15 minute override.

LED LUMINAIRE SCHEDULE

(DESC) DOOR:		DISTRIBUTION:		BEAMWIDTH:		(L/L) LENS/LOUVER:		K19 - KSH19 .156" ACRYLIC							
FA - FLAT ALUMINUM		II - ANSI/IES TYPE 2 DISTRIBUTION		NSP - VERY NARROW SPOT		A - 125" ACRYLIC		M - MATTE DIFFUSE CLEAR							
FS - FLAT STEEL		III - ANSI/IES TYPE 3 DISTRIBUTION		SP - SPOT		B - BAFFLE/LOUVER		N - NONE							
RA - REGRESSED ALUMINUM		IV - ANSI/IES TYPE 4 DISTRIBUTION		MD - MEDIUM		C - CLEAR ALZAK		P - POLYCARBONATE							
RS - REGRESSED STEEL		V - ANSI/IES TYPE 5 DISTRIBUTION		WD - WIDE		F - FROSTED ACRYLIC		R - HIGH IMPACT DR ACRYLIC							
FINISH:				VWD - VERY WIDE		G - TEMPERED GLASS		SS - SEMI-SPECULAR CLEAR							
PAF - PAINT AFTER FABRICATION				WW - WALL WASH		K - KSH12 .125" ACRYLIC		O - OTHER (SEE DESCRIPTION)							
CFSA - COLOR-FINISH SELECTION BY ARCHITECT															
(MTG) MOUNTING:		RE - RECESSED				(WATT) PER:		FIX - FIXTURE, FT - FOOT, LAMP							
CL - CEILING SURFACE		SP - SUSPENDED				(TYPE) LED		RGB - COLOR CHANGING LED							
CV - COVE		SU - SURFACE				LED - LIGHT EMITTING DIODE		RGBW - COLOR CHANGING + WHITE							
FR - FLANGED RECESSED		UC - UNDER CABINET				TLED - TUBULAR LED LAMP		RGB - COLOR CHANGING + AMBER							
P - PERIMETER		WL - WALL				OLED - ORGANIC LED		RLED - RETROFIT LED							
PL - POLE		O - OTHER (SEE DESCRIPTION)				DLED - DYNAMIC TUNABLE LED		WLED - WARM DIM LED							
(TYPE) DRIVER:		0-10V - 0-10V DIMMING		EB - ELECTRONIC		HL - HIGH/LOW (100%/50%) STEP DIM		MV - MULTI-VOLTAGE ELECTRONIC							
DALI - DIGITAL ADDRESSABLE		ELV - ELECTRONIC LOW VOLTAGE		LM - LINE VOLTAGE DIMMING		RE - REMOTE		O - OTHER (SEE DESCRIPTION)							
DMX - DIGITAL MULTIPLEX		EM - EMERGENCY BATTERY		ML - MULTI-LEVEL SWITCHING											
CATALOG NUMBER SHALL NOT BE CONSIDERED COMPLETE AND MATERIAL SHALL NOT BE ORDERED BY MANUFACTURER AND CATALOG NUMBER ONLY. THE COMPLETE DESCRIPTION AND THE SPECIFICATION SHALL BE COORDINATED WITH THE CATALOG NUMBER TO DETERMINE THE EXACT MATERIAL AND ACCESSORIES TO BE ORDERED. THE FIRST MANUFACTURER LISTED IS THE BASIS OF DESIGN.															
VERIFY AND COORDINATE ALL CEILING TYPES WITH LUMINAIRE MOUNTING AND TRIM REQUIREMENTS PRIOR TO THE RELEASE OF THE LUMINAIRE ORDER.															
CONFIRM ALL COLORS AND FINISHES OF ALL LUMINAIRE COMPONENTS WITH ARCHITECT AND INTERIOR DESIGNER PRIOR TO THE RELEASE OF THE LUMINAIRE ORDER.															
UNLESS INDICATED ON LIGHTING PLANS OR BELOW, REFER TO ARCHITECTURAL AND INTERIOR DESIGN ELEVATIONS, SECTIONS AND DETAILS FOR ALL SUSPENDED AND WALL MOUNTED LUMINAIRE MOUNTING HEIGHTS.															
REFER TO SPECIFICATION SECTIONS LED LIGHTING 26.51.19 FOR ADDITIONAL INFORMATION AND REQUIREMENTS.															
INTERIOR CORRELATED COLOR TEMPERATURE 4000/4100K COLOR RENDERING INDEX (CRI) AT OR ABOVE 80, UNLESS NOTED OTHERWISE.															
EXTERIOR CORRELATED COLOR TEMPERATURE 3000K COLOR RENDERING INDEX (CRI) AT OR ABOVE 80, UNLESS NOTED OTHERWISE.															
				DIMENSIONS			WATT			LED		DRIVER			
ITEM	DESCRIPTION	L/L	MTG	L	W	H	DIA.	ANSI WATTS	PER	TYPE	QTY	DELIVERED LUMENS (MIN)	VOLTS	TYPE	MANUFACTURER AND MODEL
D1	OPEN RECESSED DOWNLIGHT, CLEAR SPECULAR PARABOLIC SELF TRIMMING REFLECTOR, DAMP LABEL, MEDIUM DISTRIBUTION	SS	RE			5 1/256"	6"	15 W	FIX	LED	1	1500	120 V	0-10V	HALO HC6
D1E	SAME AS D1 BUT WITH UL-924 INTEGRAL BATTERIES.	SS	RE			9 1/2"	6"	15 W	FIX	LED	1	1500	120 V	0-10V	HALO HC6
EX	SINGLE-FACE EXIT SIGN, WHITE THERMOPLASTIC BODY, GREEN LETTERS, EMERGENCY NI-CAD BATTERY INSIDE OF SIGN, UNIVERSAL ARROWS/MOUNTING, SELF TEST & DIAGNOSTICS OF INVERTER AND LAMPS	O	CL	1'-1"	2"	9"		5 W	FIX	LED	1	LED	120 V	EM	SURE-LITES APX
F2	EDGE-LIT FLAT PANEL, ALUMINUM BEZEL, STEEL BACKPLATE, SEAMLESS CORNERS, INTEGRAL GRID CLIPS, ACRYLIC LIGHT GUIDE, GASKETED WHITE FROST LENS. NO DIODE IMAGE SHALL BE VISIBLE.	F	RE	2'-0"	2'-0"	4 1/2"		30 W	FIX	LED	1	3333	120 V	0-10V	METALUX 22FP
F2E	SAME AS F2 BUT WITH UL-924 INTEGRAL BATTERIES.	F	RE	2'-0"	2'-0"	4 1/2"		30 W	FIX	LED	1	3333	120 V	0-10V	METALUX 22FP EL14W
G1	SUSPENDED LENSED HIGH BAY, IK10 LENS, IK09 HOUSING, GLARE CONTROL, FIELD SELECTABLE CCT AND LUMEN SETTINGS	F	SP	1'-2 3/16"	10 1/4"	4 1/4"		156 W	FIX	LED	1	24153	120 V	0-10V	METALUX LHBS
L2	4' LENSED LINEAR LED SYSTEM SUSPENSION, NO UPLIGHT, WHITE FINISH	F	SP	4'-0"	3 3/4"	3 3/4"		8 W	FT	LED	1	971	120 V	0-10V	CORELITE CONTINUA SQ4

ELECTRICAL CONNECTION SCHEDULE

	TAG NAME	VOLTAGE	APPARENT LOAD	FLA	MCA	MOCP	OCPD	CIRCUIT NUMBER	WIRE AND RACEWAY	SCCR	DISCONNECT BY	TYPE	CONTROLLER / STARTER BY	TYPE
D	UH-1	120 V, 1Ø	0.10 kVA	0.8 A	0 A	0 A	15 A	37	2#12 & 1#12 EGC IN 3/4" C.	5,000 A	MFR	NF	MFR	
LD	UH-2	120 V, 1Ø	0.10 kVA	0.8 A	0 A	0 A	15 A	39	2#12 & 1#12 EGC IN 3/4" C.	5,000 A	MFR	NF	MFR	
ALTERNATE 06: ALL WORK RELATED TO HYDRONIC LOOP TO BE PRICED SEPARATELY FOR SCHOOL DISTRICT REVIEW.														

ADDENDUM 01



1600 E ORCHARD ROAD
SUITE 200
GREENWOOD VILLAGE, CO 80111
P: 303.796.6000

www.imegcorp.com

IMEG RESERVES PROPRIETARY RIGHTS, INCLUDING COPYRIGHTS, TO THIS DRAWING AND THE DATA SHOWN THEREON. SAID DRAWING AND/OR DATA ARE THE EXCLUSIVE PROPERTY OF IMEG AND SHALL NOT BE USED OR REPRODUCED FOR ANY OTHER PROJECT WITHOUT THE EXPRESS WRITTEN APPROVAL AND PARTICIPATION OF IMEG. ©2025 IMEG CONSULTANTS CORP.

01

2

3

REF. SCALE IN INCHES

PROJECT #2500851.00

ARCHITECT
Hord Coplan Macht, Inc.
1850 Wazee Street, Suite 450
Denver, CO 80202
p. 303.607.0977
f. 303.607.0767

STRUCTURAL ENGINEER
Ascent Group
79050 US Highway 40, Unit 1C
Winter Park, CO 80482
p. 303.499.3022
w. ascentgrp.com

M/E/P ENGINEER
IMEG Corp.
7600 E. Orchard Road, Suite 250-S
Greenwood Village, CO 80111
p. 303.796.6000
w. imegcorp.com

CIVIL ENGINEER
JVA, Inc.
3473 S Broadway
Englewood, CO 80113
p. 303.703.4444
w. liveyourcore.com

EAST GRAND SCHOOL DISTRICT
Fraser Valley Elementary School
Renovation Summer 2026

125 Eastom Ave
Fraser, CO 80442

hord | coplan | macht

ARCHITECTURE
LANDSCAPE ARCHITECTURE
PLANNING
INTERIOR DESIGN

1

03/05/2026

ADDENDUM 01

No. Date Revision

Project Name
Fraser Valley Elementary School
Renovation Summer 2026

Project Number
222000.50

Date (YYYY/MM/DD)
2026/02/11

Drawn By
AGG

Checked By
JMN

Drawing
ELECTRICAL SCHEDULES

E-600

100% CONSTRUCTION
DOCUMENTS

ARCHITECT
Wood Coplan Macht, Inc.
 600 W. Venable Street, Suite 450
 Denver, CO 80202
 303.607.0977
 303.607.0767

E/P ENGINEER
EG, Corp.
 100 E Orchard Road, Suite 250-S
 Greenwood Village, CO 80111
 303.796.6000
 imegcorp.com

CIVIL ENGINEERS
Core Consultants Inc.
 73 S Broadway
 Englewood, CO 80113
 303.703.4444
 liveyourcore.com


STRUCTURAL ENGINEER
Ascen Group
 11 Peel Street, Ste 300
 Boulder, CO 80302
 303.499.3022
 ascengrp.com

Fraser Valley Elementary School
Renovation Summer 2026

125 Eastom Ave
Fraser, CO 80442

ord | coplan | macht

ARCHITECTURE
LANDSCAPE ARCHITECTURE
PLANNING
INTERIOR DESIGN

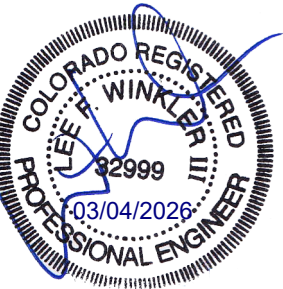[illegible]

01	3/16/26	Addendum 01
No.	Date	Revision

Project Name
Fraser Valley Elementary School
Renovation Summer 2026

Project Number
22000.50

Site (YYYY/MM/DD)
026/03/16


Drawn By	Checked By
WV	LFW
Drawing	
FAST WING, NEW OPENINGS	

FAST WING, NEW OPENINGS


S-100

ADDENDUM 01 SUMMER 2026


Hord Coplan Macht, Inc.

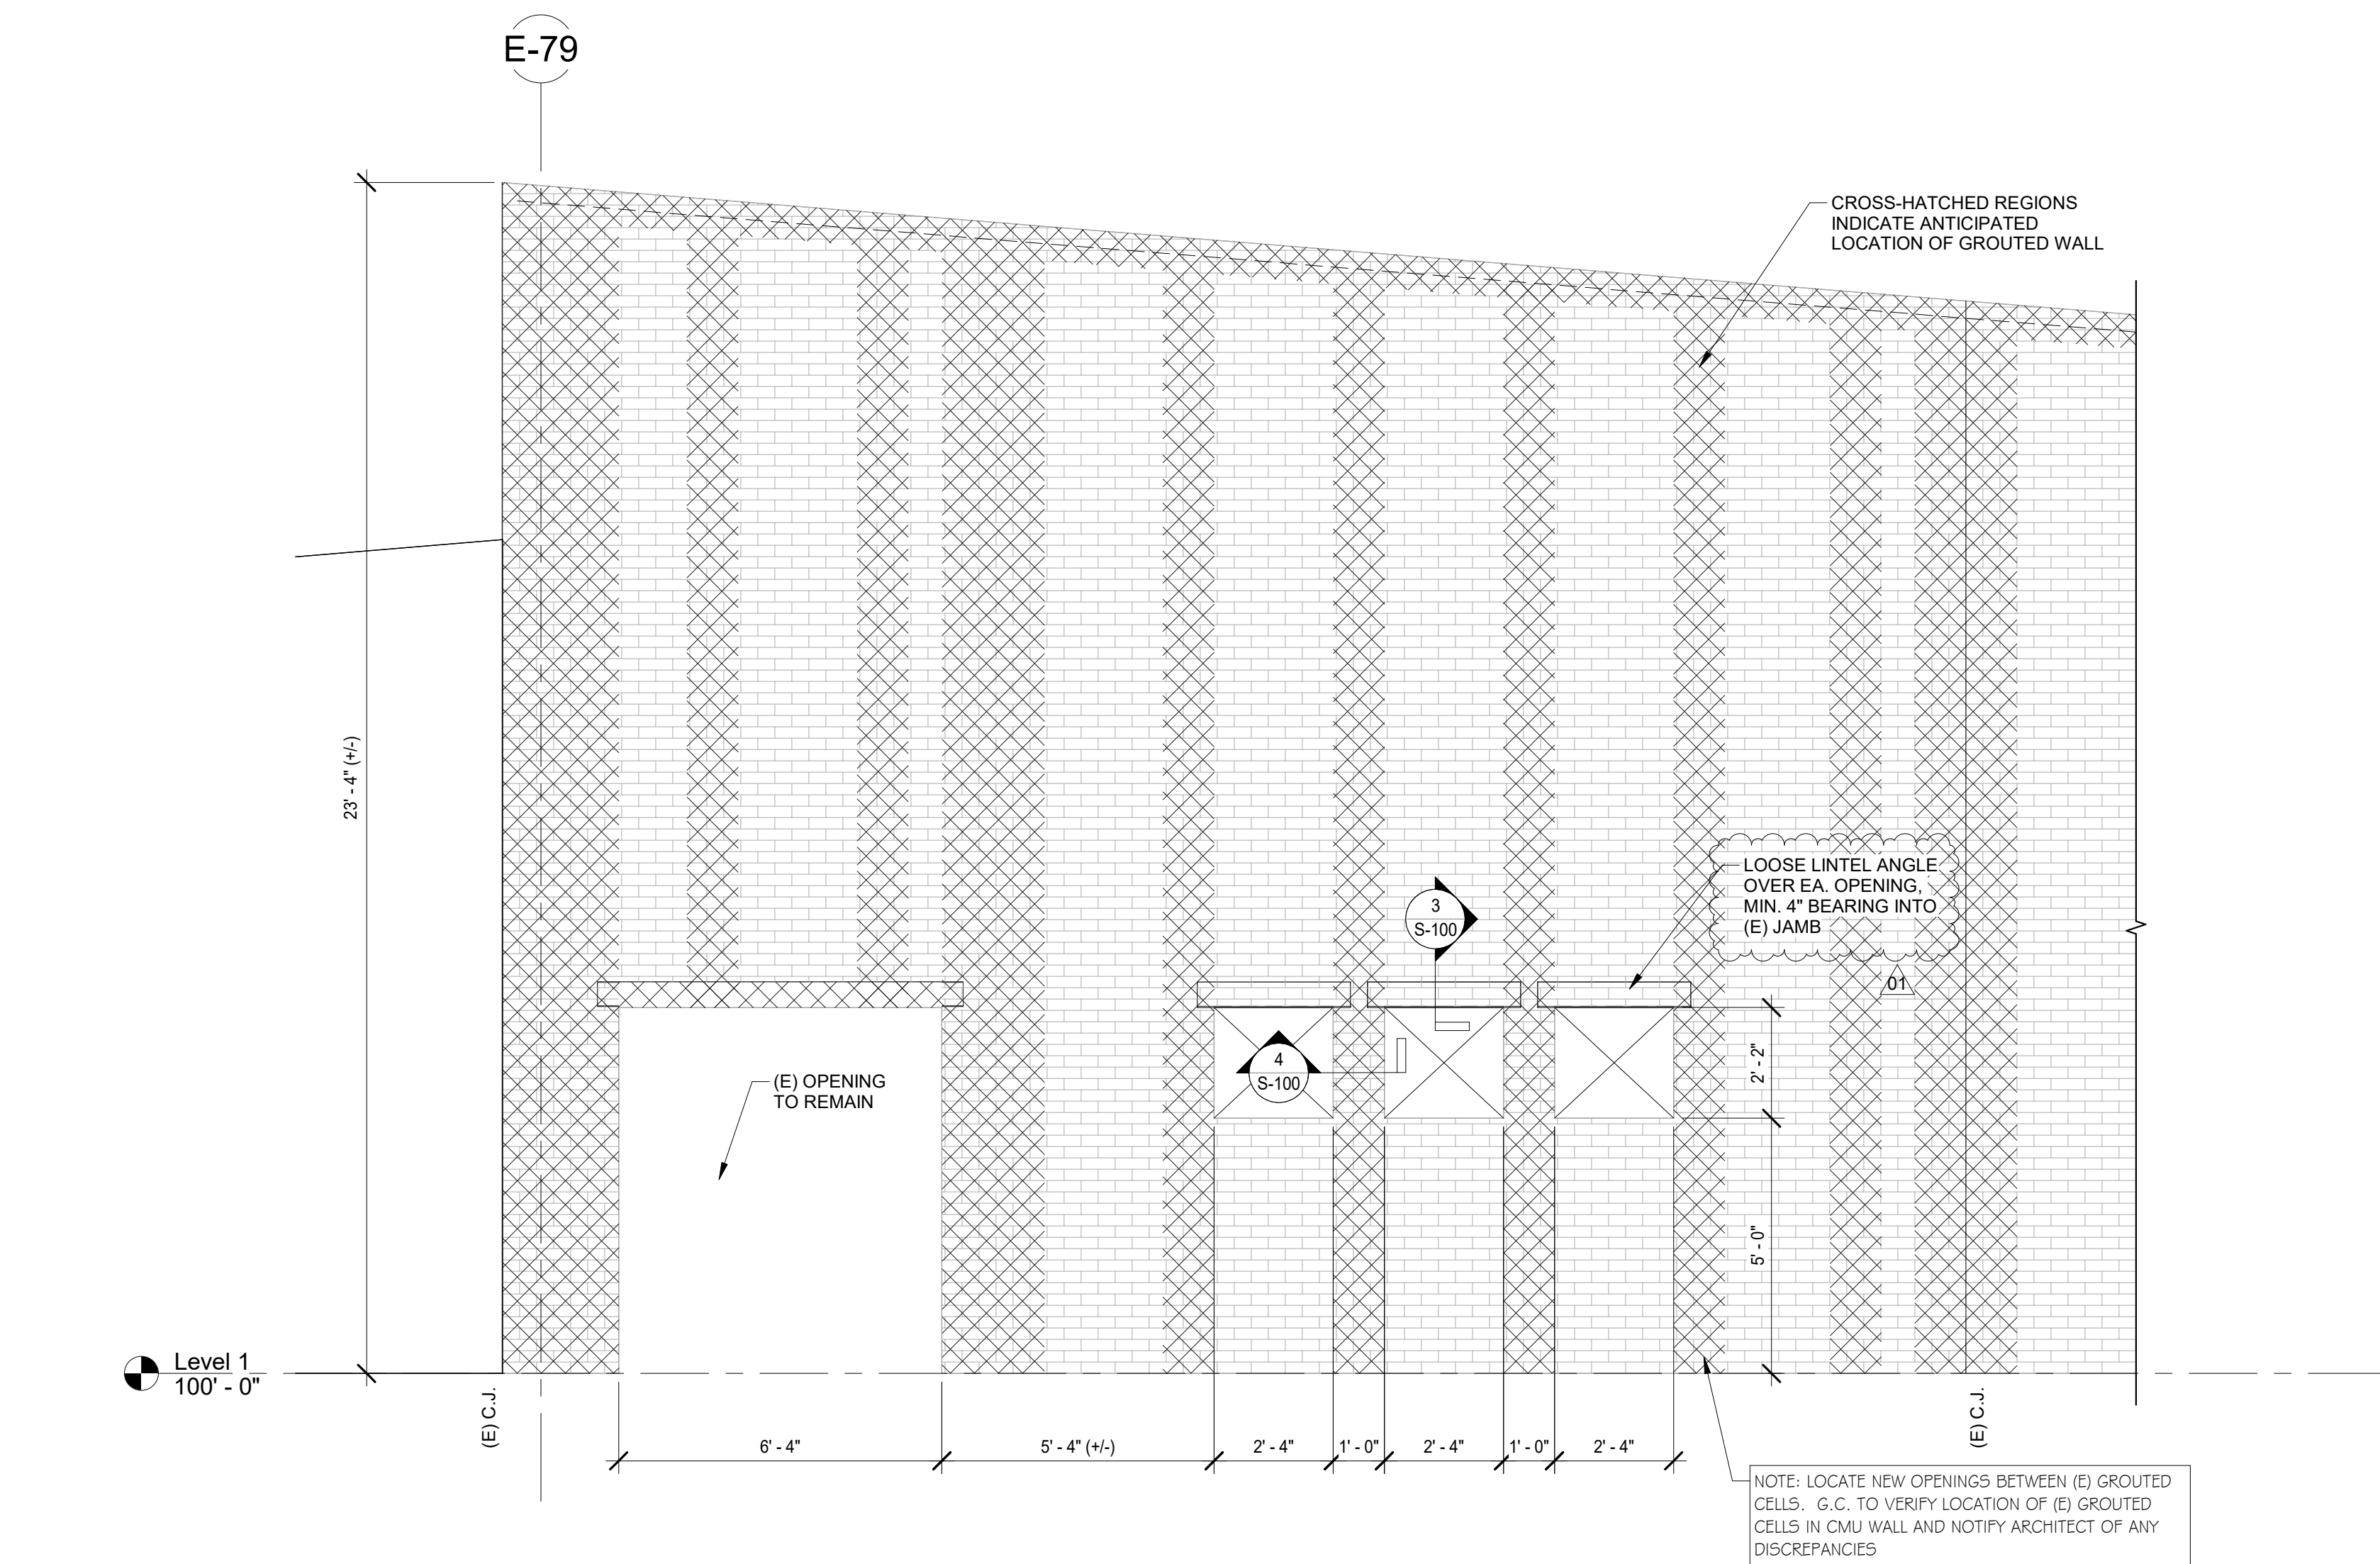


2 EAST WALL ELEVATION
S-100 3/8" = 1'-0"

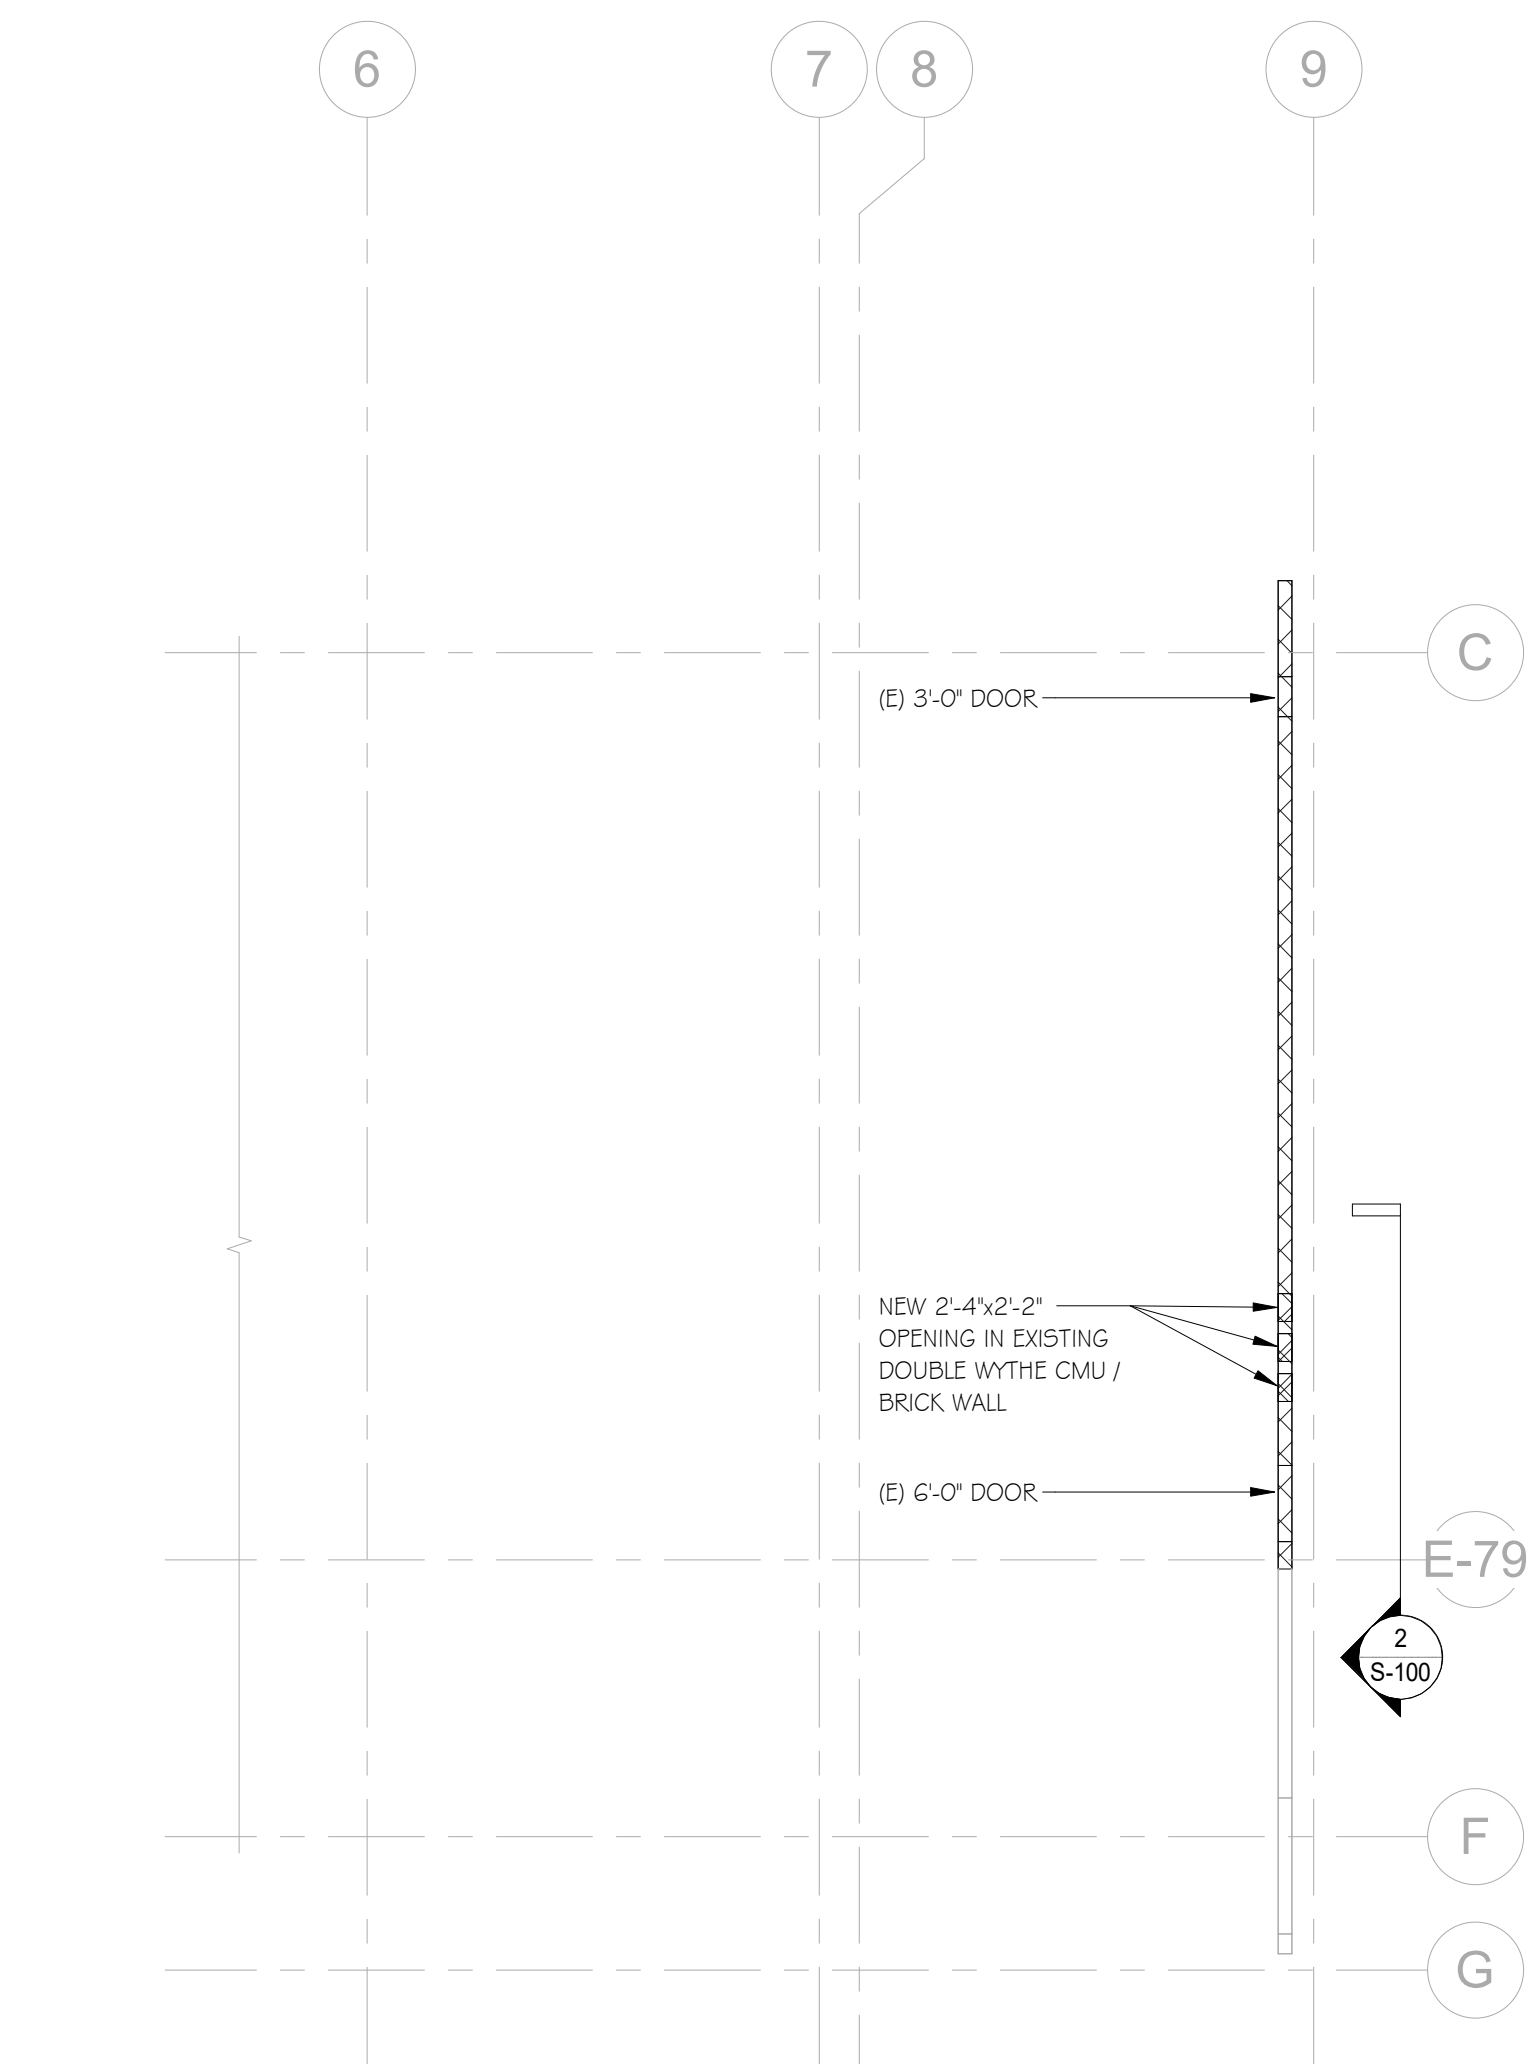

1 PARTIAL PLAN - AREA C
S-100 1/16" = 1'-0"

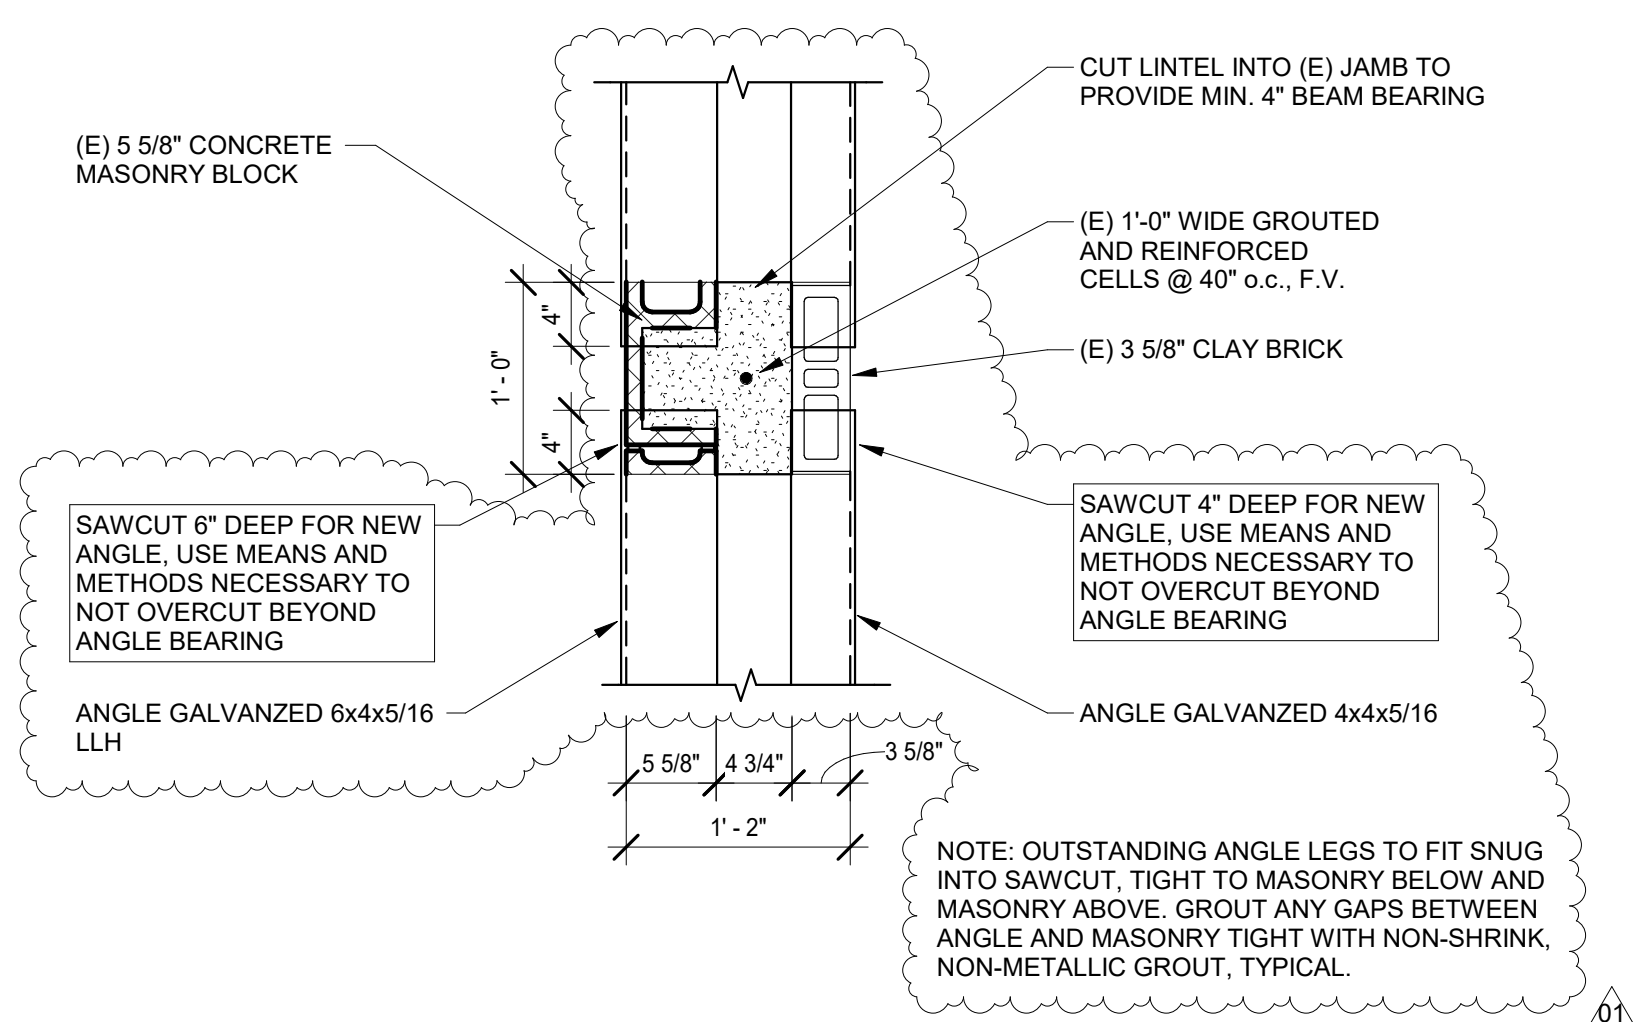

4 EAST WALL, CMU JAMB
100 1" = 1'-0"

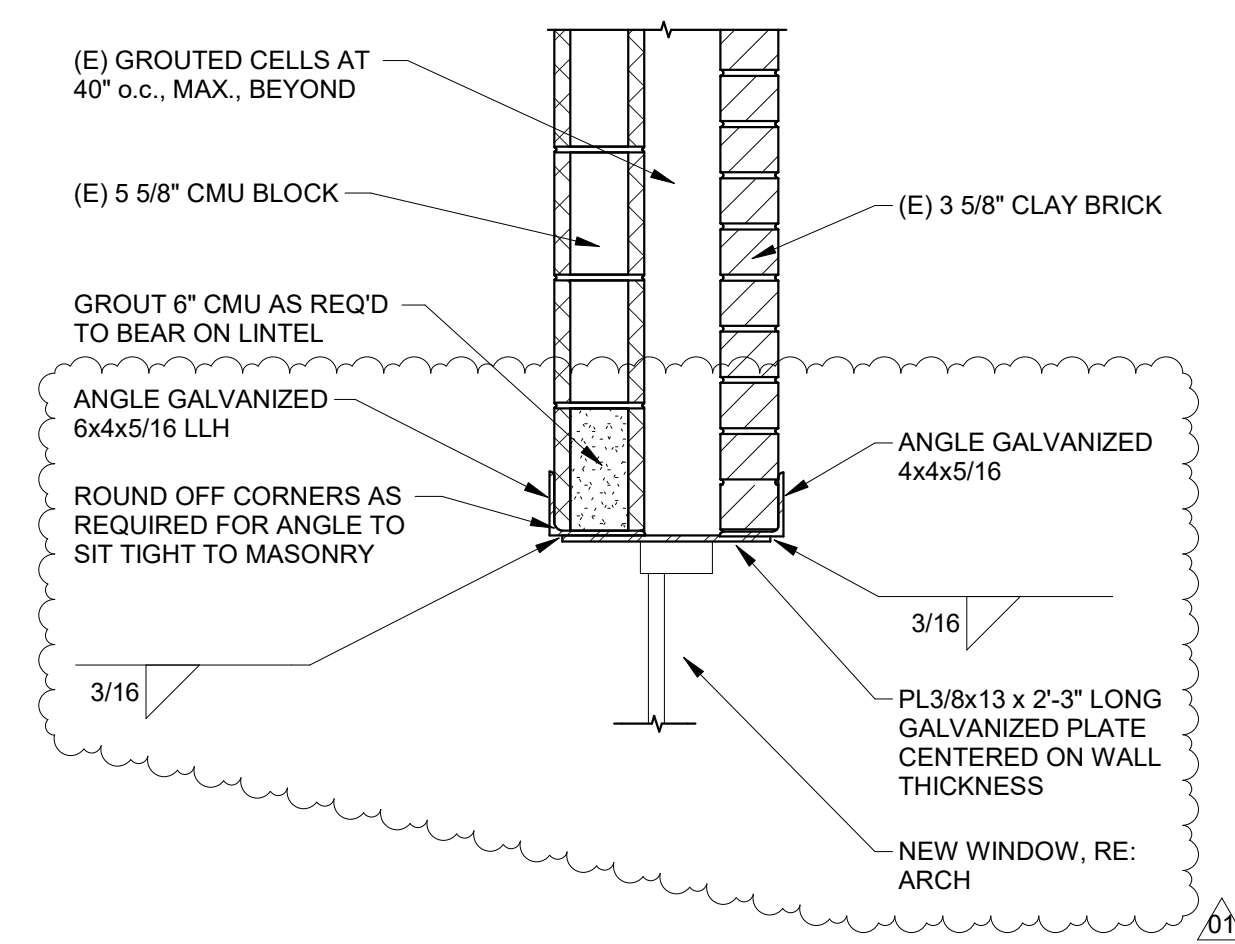

3 W6 LINTEL DETAIL
S-100 1" = 1'-0"

