



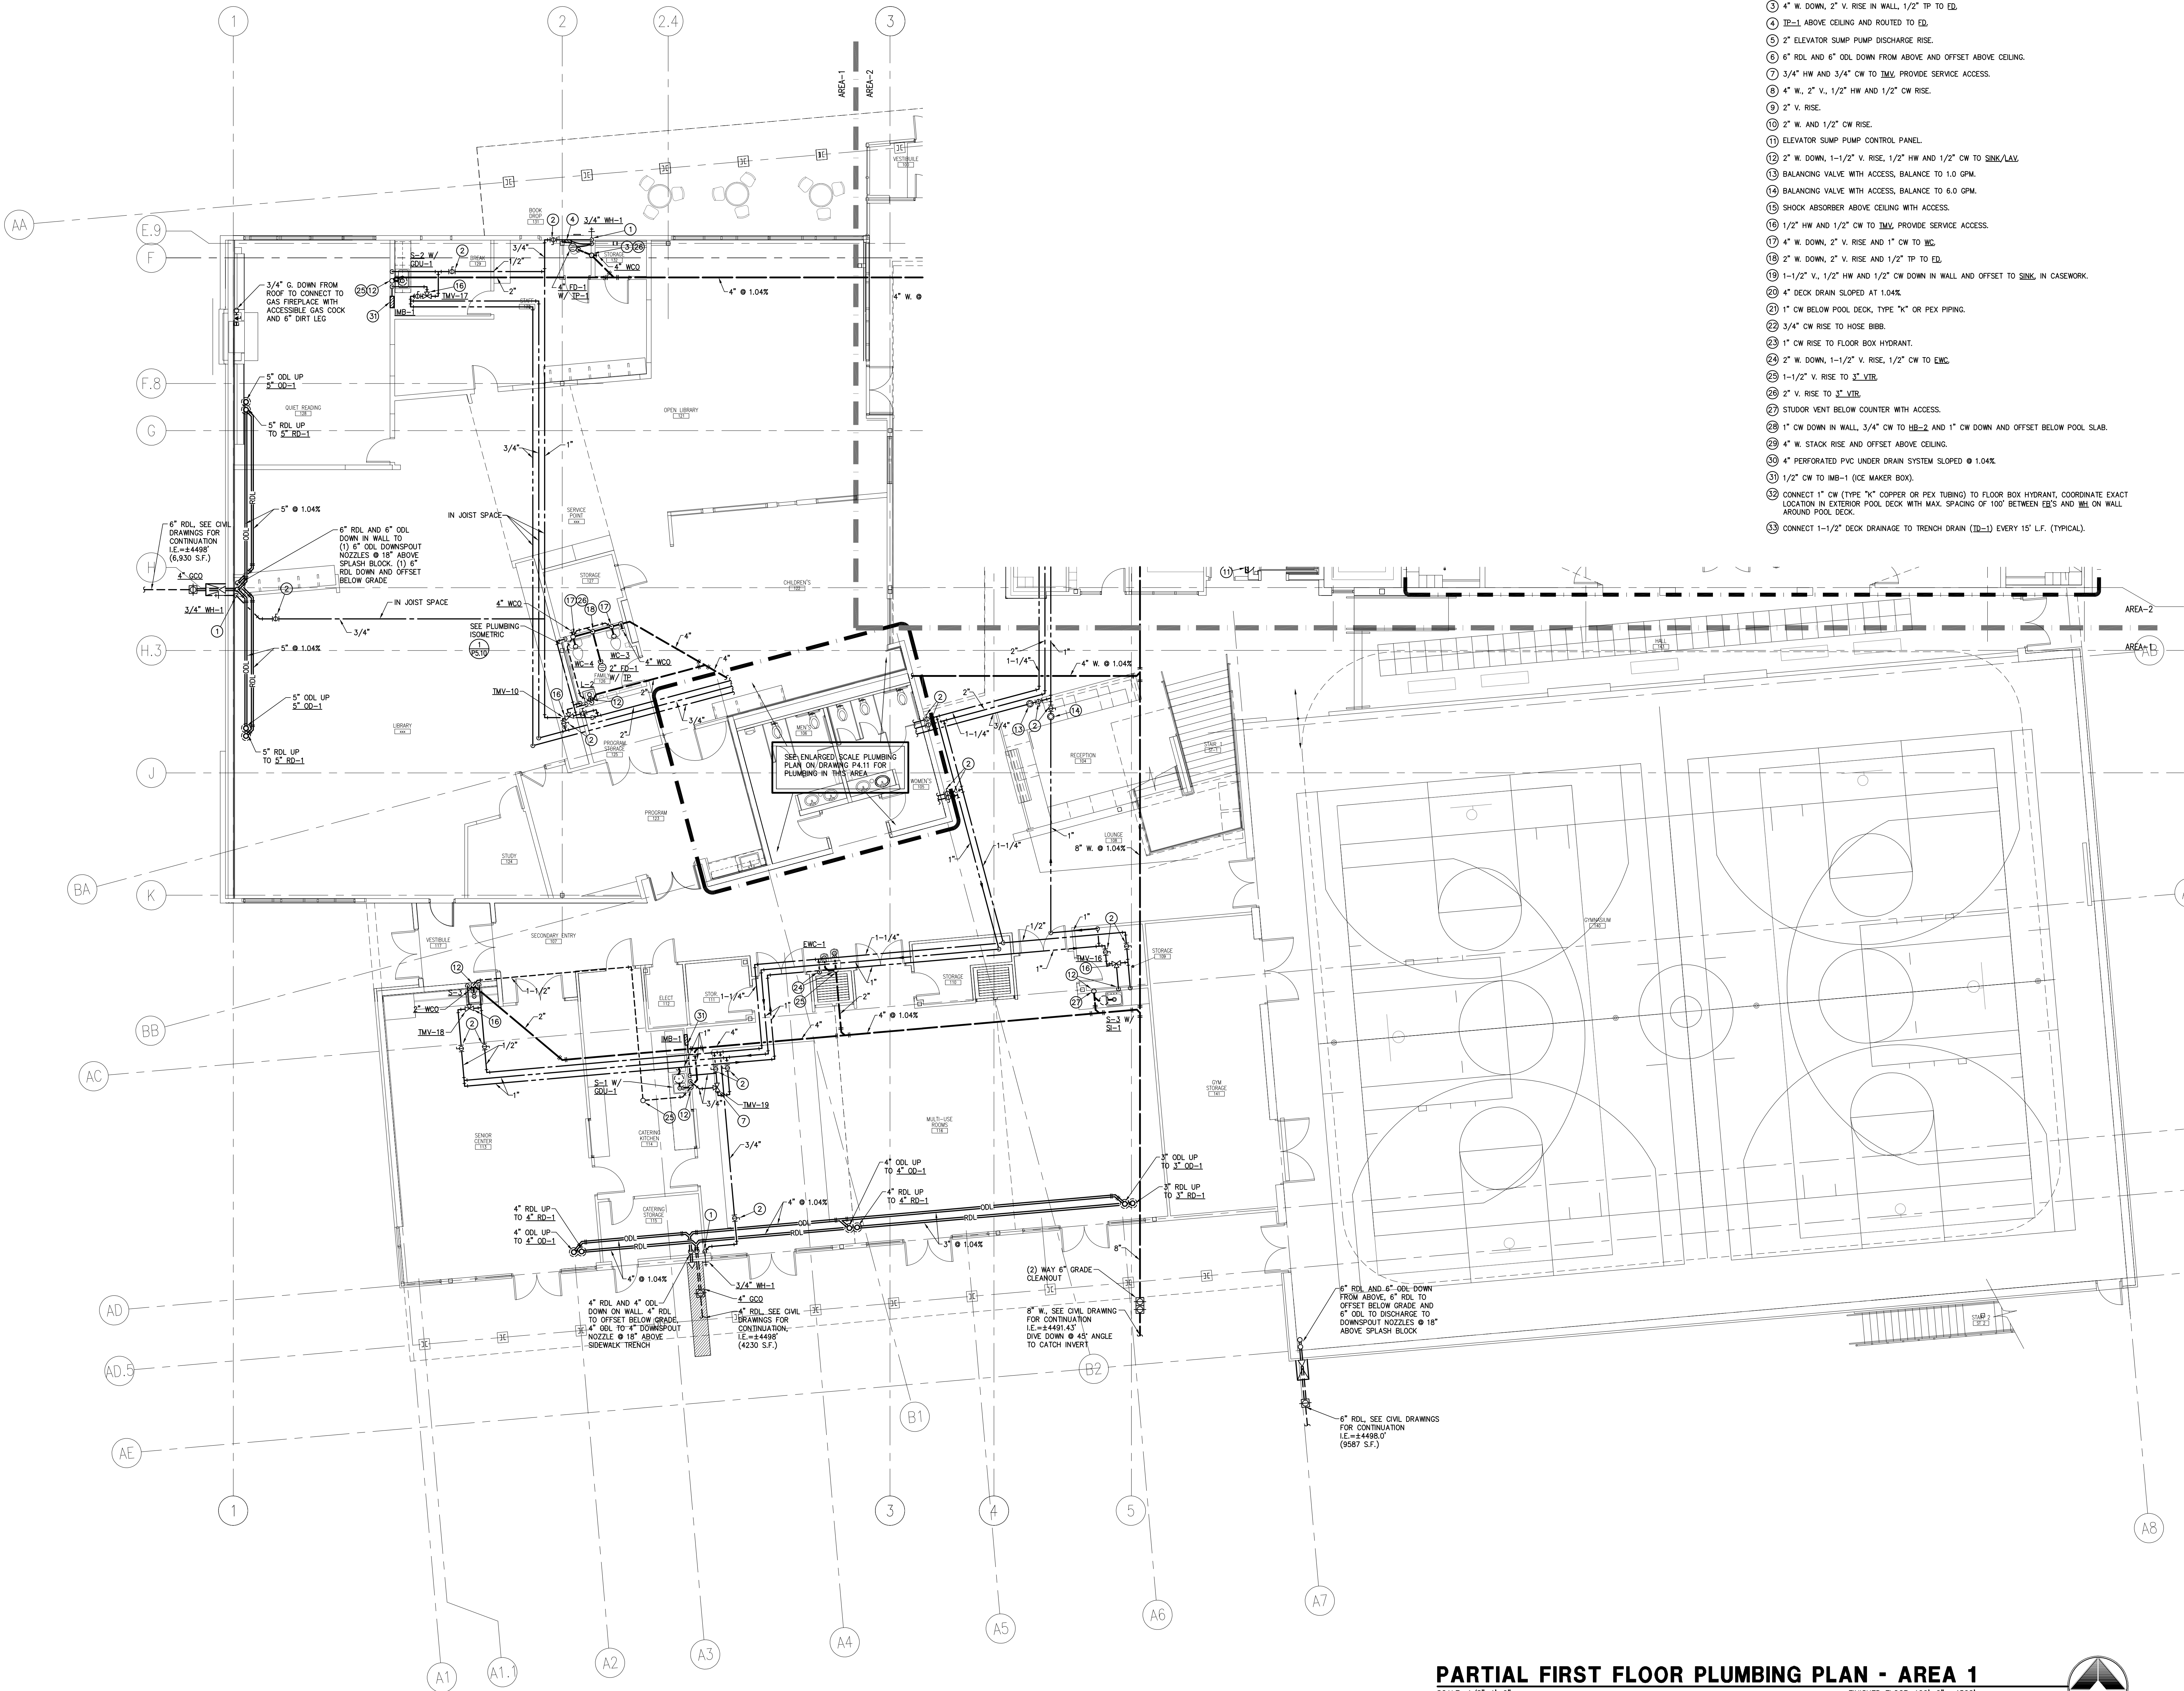

PARTIAL FIRST FLOOR PLUMBING PLAN - AREA 1

SCALE: 1/8"=1'-0" FINISHED FLOOR=100'-0" -4502'

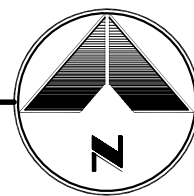

- PLUMBING KEYNOTES:
- 3/4" CW DOWN IN WALL TO 3/4" WH-1.
 - BALL VALVE (FULL SIZE) WITH SERVICE ACCESS.
 - 4" W. DOWN, 2" V. RISE IN WALL, 1/2" TP TO ED.
 - TP-1 ABOVE CEILING AND ROUTED TO ED.
 - 2" ELEVATOR SUMP PUMP DISCHARGE RISE.
 - 6" RDL AND 6" ODL DOWN FROM ABOVE AND OFFSET ABOVE CEILING.
 - 3/4" HW AND 3/4" CW TO TMV, PROVIDE SERVICE ACCESS.
 - 4" W., 2" V., 1/2" HW AND 1/2" CW RISE.
 - 2" V. RISE.
 - 2" W. AND 1/2" CW RISE.
 - ELEVATOR SUMP PUMP CONTROL PANEL.
 - 2" W. DOWN, 1-1/2" V. RISE, 1/2" HW AND 1/2" CW TO SINK/LAV.
 - BALANCING VALVE WITH ACCESS, BALANCE TO 1.0 GPM.
 - BALANCING VALVE WITH ACCESS, BALANCE TO 6.0 GPM.
 - SHOCK ABSORBER ABOVE CEILING WITH ACCESS.
 - 1/2" HW AND 1/2" CW TO TMV, PROVIDE SERVICE ACCESS.
 - 4" W. DOWN, 2" V. RISE AND 1" CW TO WC.
 - 2" W. DOWN, 2" V. RISE AND 1/2" TP TO ED.
 - 1-1/2" V., 1/2" HW AND 1/2" CW DOWN IN WALL AND OFFSET TO SINK, IN CASEWORK.
 - 4" DECK DRAIN SLOPED AT 1.04%.
 - 1" CW BELOW POOL DECK, TYPE "K" OR PEX PIPING.
 - 3/4" CW RISE TO HOSE BIBB.
 - 1" CW RISE TO FLOOR BOX HYDRANT.
 - 2" W. DOWN, 1-1/2" V. RISE, 1/2" CW TO EWC.
 - 1-1/2" V. RISE TO 3" VTB.
 - 2" V. RISE TO 3" VTB.
 - STUDOR VENT BELOW COUNTER WITH ACCESS.
 - 1" CW DOWN IN WALL, 3/4" CW TO HB-2 AND 1" CW DOWN AND OFFSET BELOW POOL SLAB.
 - 4" W. STACK RISE AND OFFSET ABOVE CEILING.
 - 4" PERFORATED PVC UNDER DRAIN SYSTEM SLOPED @ 1.04%.
 - 1/2" CW TO IMB-1 (ICE MAKER BOX).
 - CONNECT 1" CW (TYPE "K" COPPER OR PEX TUBING) TO FLOOR BOX HYDRANT, COORDINATE EXACT LOCATION IN EXTERIOR POOL DECK WITH MAX. SPACING OF 100' BETWEEN EDS AND WEL ON WALL AROUND POOL DECK.
 - CONNECT 1-1/2" DECK DRAINAGE TO TRENCH DRAIN (TD-1) EVERY 15' LF. (TYPICAL).

All information appearing herein shall not be duplicated, discharged or otherwise used without the written consent of Sink Combs Dethlefs.




SINK COMBS DETHLEFS

A Professional Corporation 475 Lincoln Street, Suite 100, 303 388 0200
For Architecture Denver, Colorado 80203 FAX 388 0222

The Ballard Group, Inc.
Mechanical Consulting Engineers
(303) 988-4514

KEY PLAN

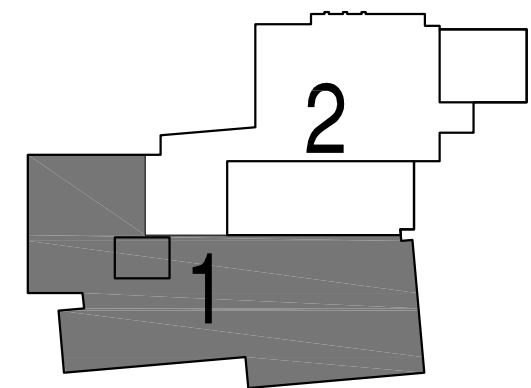

Issues/Revisions:	Date:
SCHEMATIC DESIGN	04-13-04
DESIGN DEVELOPMENT	07-10-04
80% CD COORDINATION	04-01-04
CONSTRUCTION DOCUMENTS	04-22-04

FRUITA COMMUNITY CENTER
& MESA COUNTY LIBRARIES/
FRUITA BRANCH

FRUITA COLORADO

SCD Project No.: 0401

PARTIAL FIRST FLOOR
PLUMBING PLAN - AREA 1

Drawn by: TRH
Checked by: TRH

P2.10