



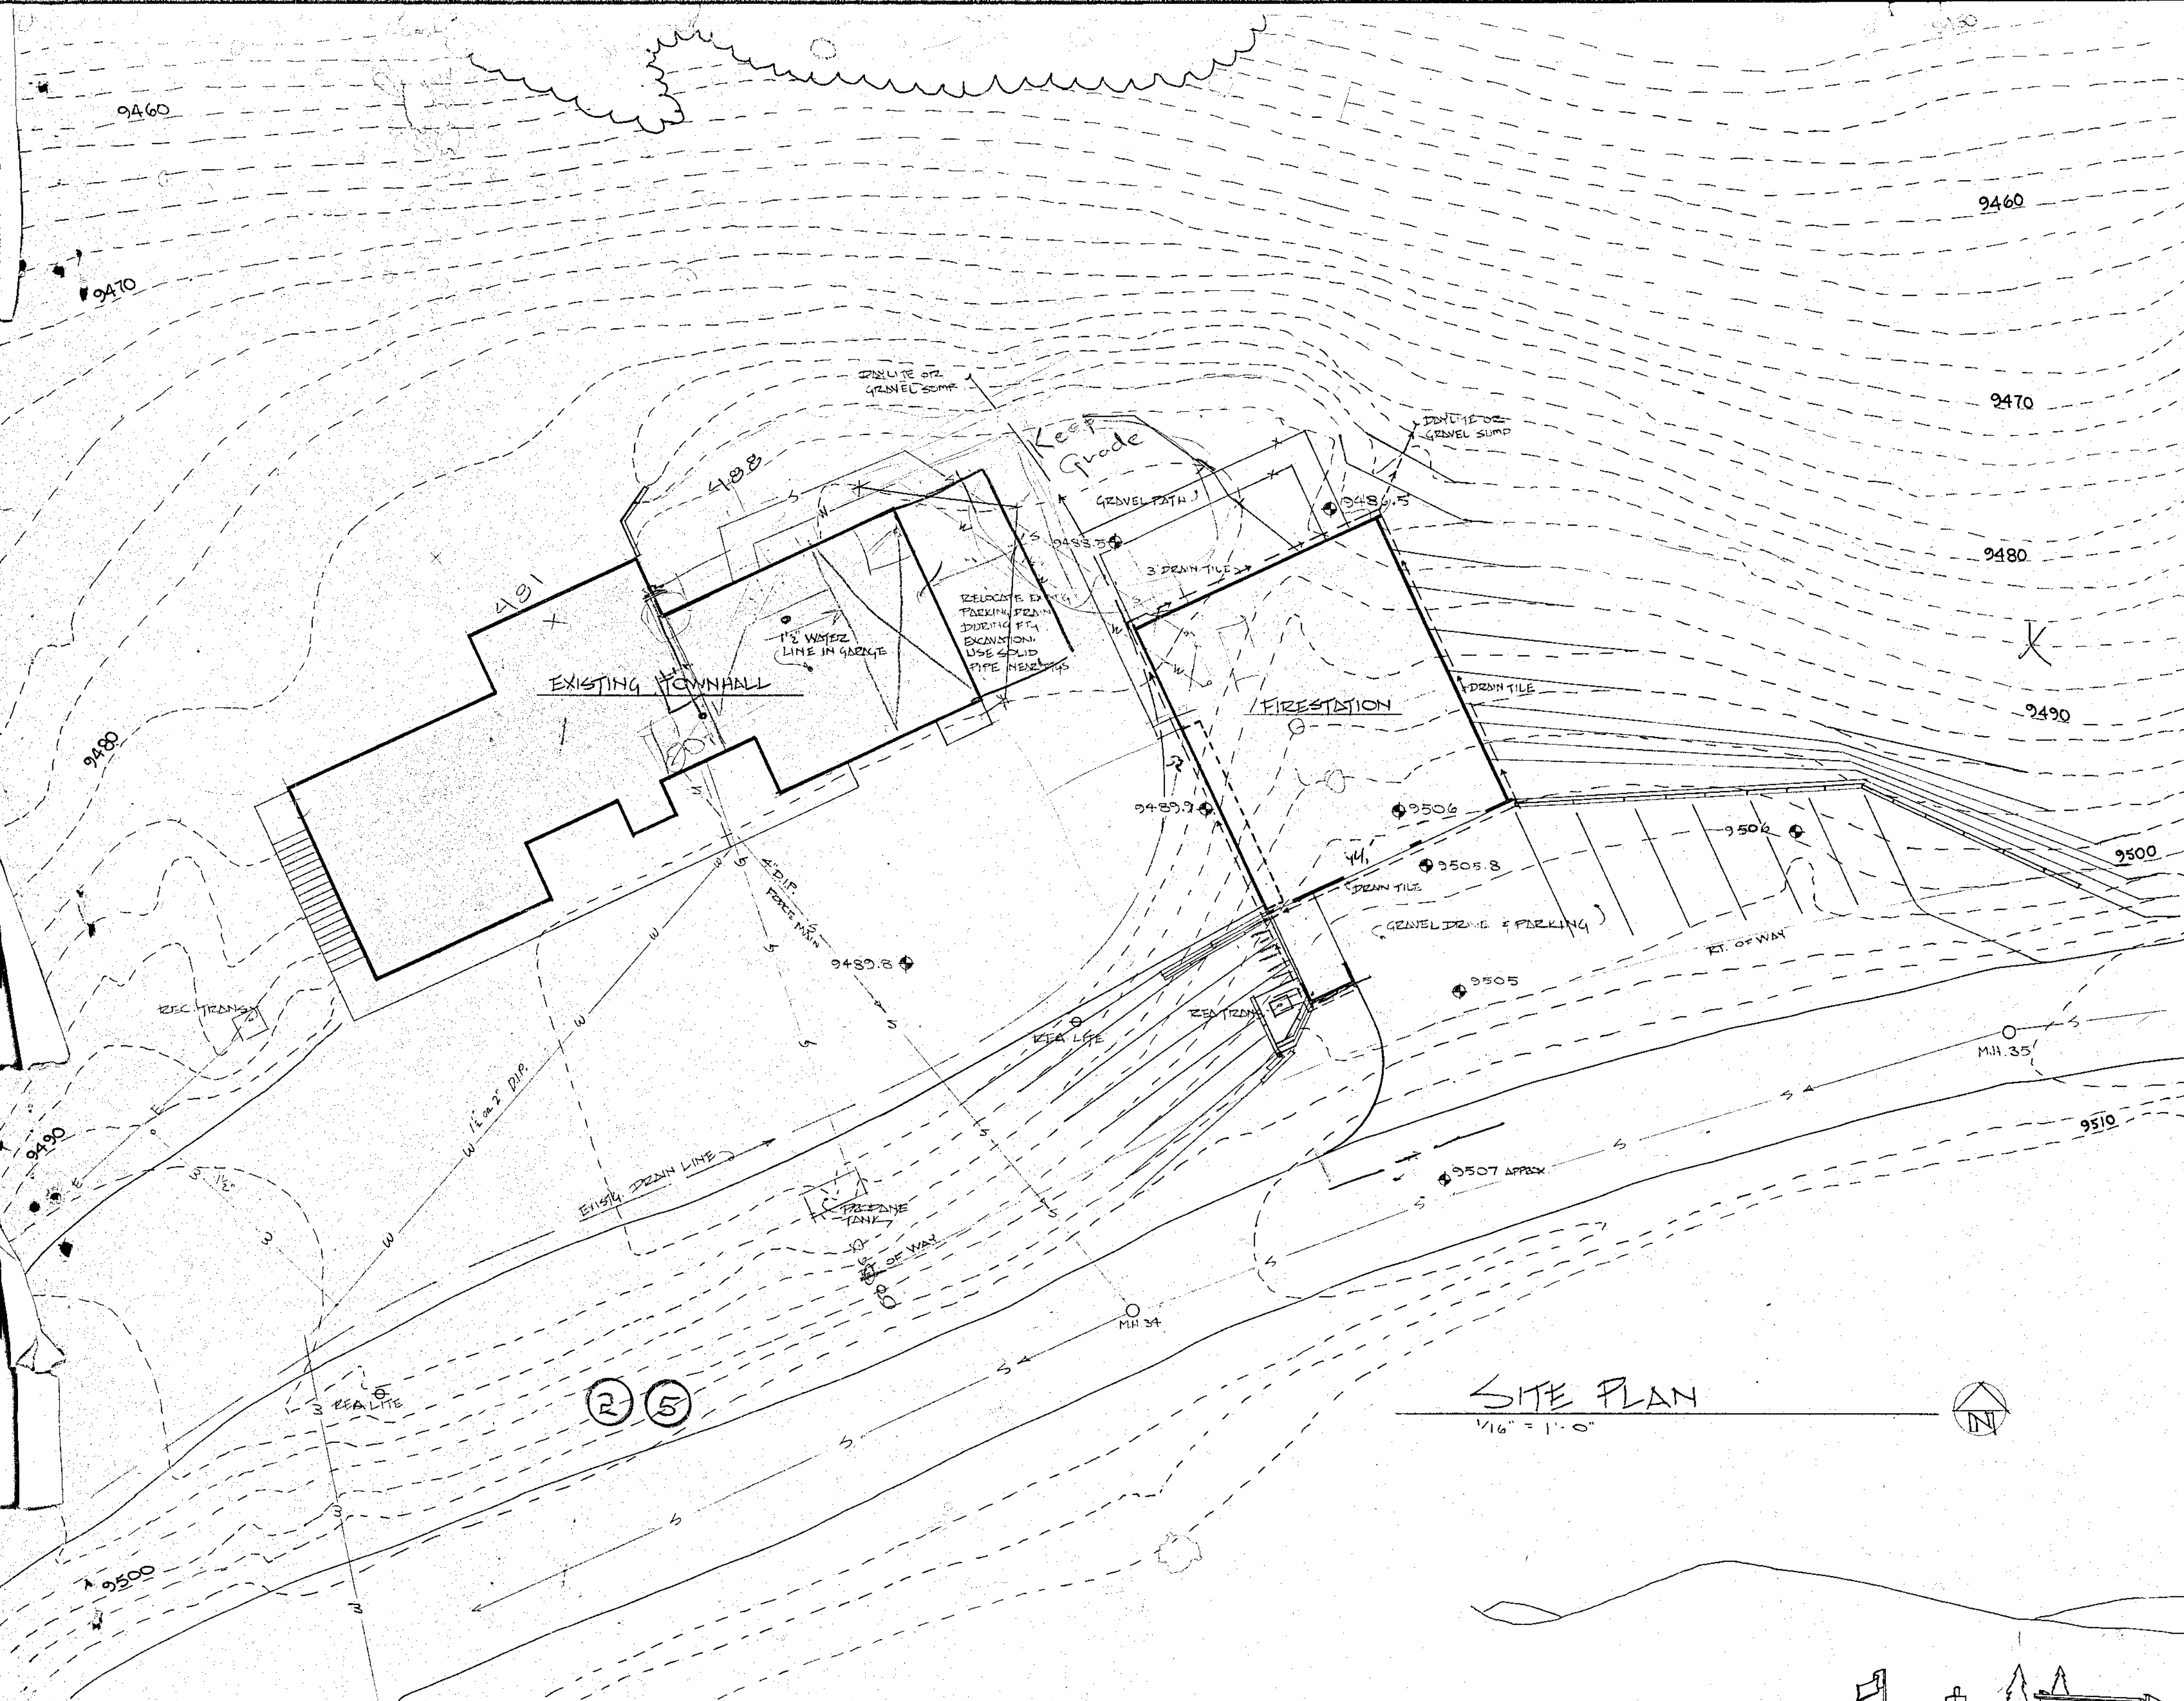

SITE PLAN
1/16" = 1'-0"

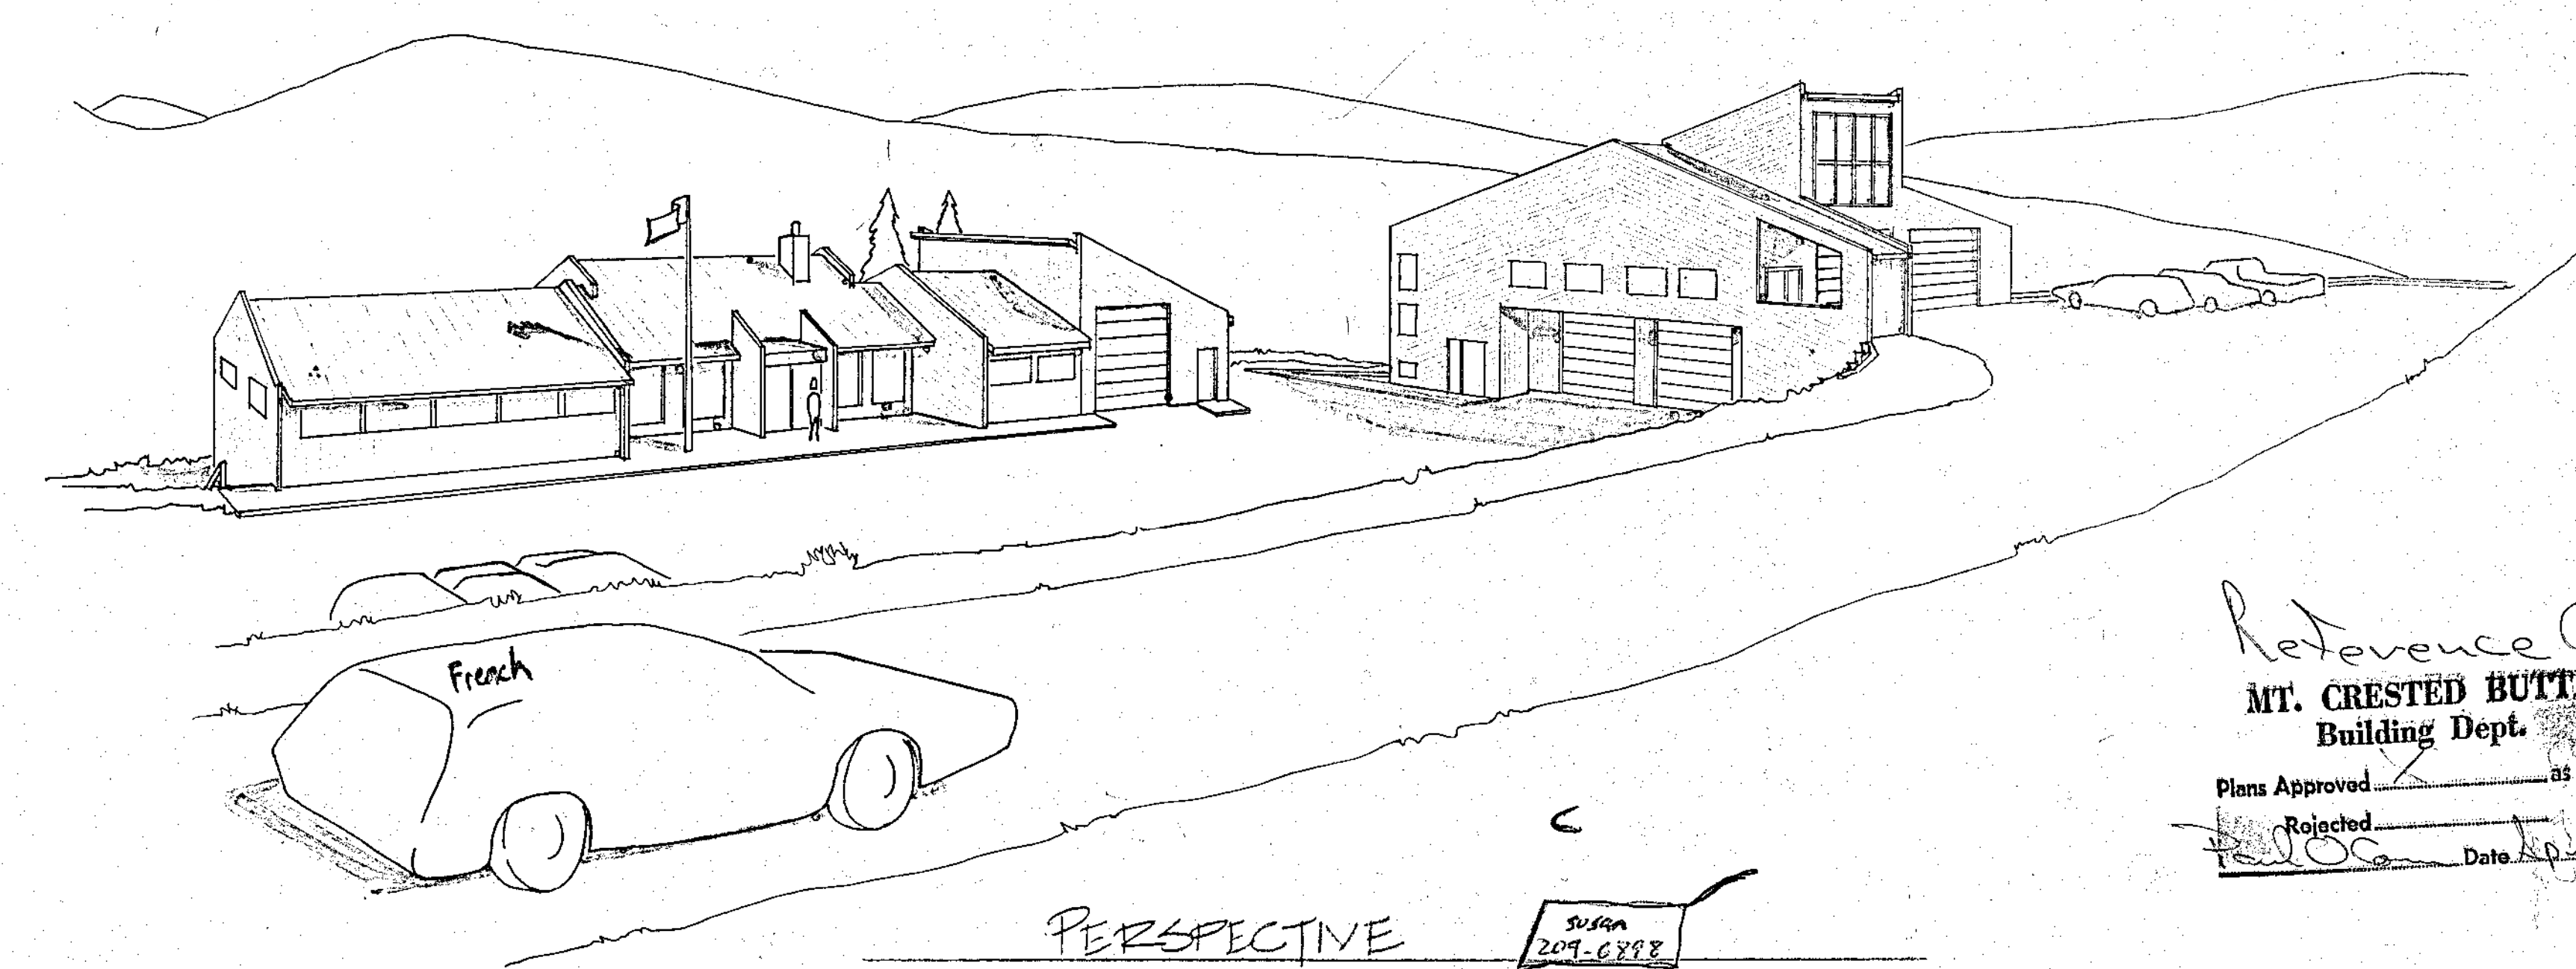

INDEX

A1	SITE PLAN & INDEX
A2	FLOOR PLANS
A3	SOUTH & WEST EXTERIOR ELEVATIONS
A4	NORTH & EAST EXTERIOR ELEVATIONS
A5	BLDG. SECTIONS
A6	WALL SECTIONS & DETAILS
S1	FOUNDATION PLAN
S2	MIDDLE & UPPER LEVEL FRAMING PLAN
S3	ROOF FRAMING PLAN & DETAILS
S4	DETAILS
M1	MECHANICAL
E1	ELECTRICAL

Reference Copy
MT. CRESTED BUTTE
 Building Dept.
 Plans Approved _____ as noted
 Rejected _____
 Date 1/19/82

SUNLIT DESIGN
 ARCHITECTURE
 1000 1/2 CRESTED BUTTE BLVD. #100
 BUTTE, MT. 59701



DATE 1/14/82
 DRAWN BY BZ
 CHECKED BY

REV. D. _____


C.B.F.P.D. FIRE STATION

SITE PLAN & INDEX


A1

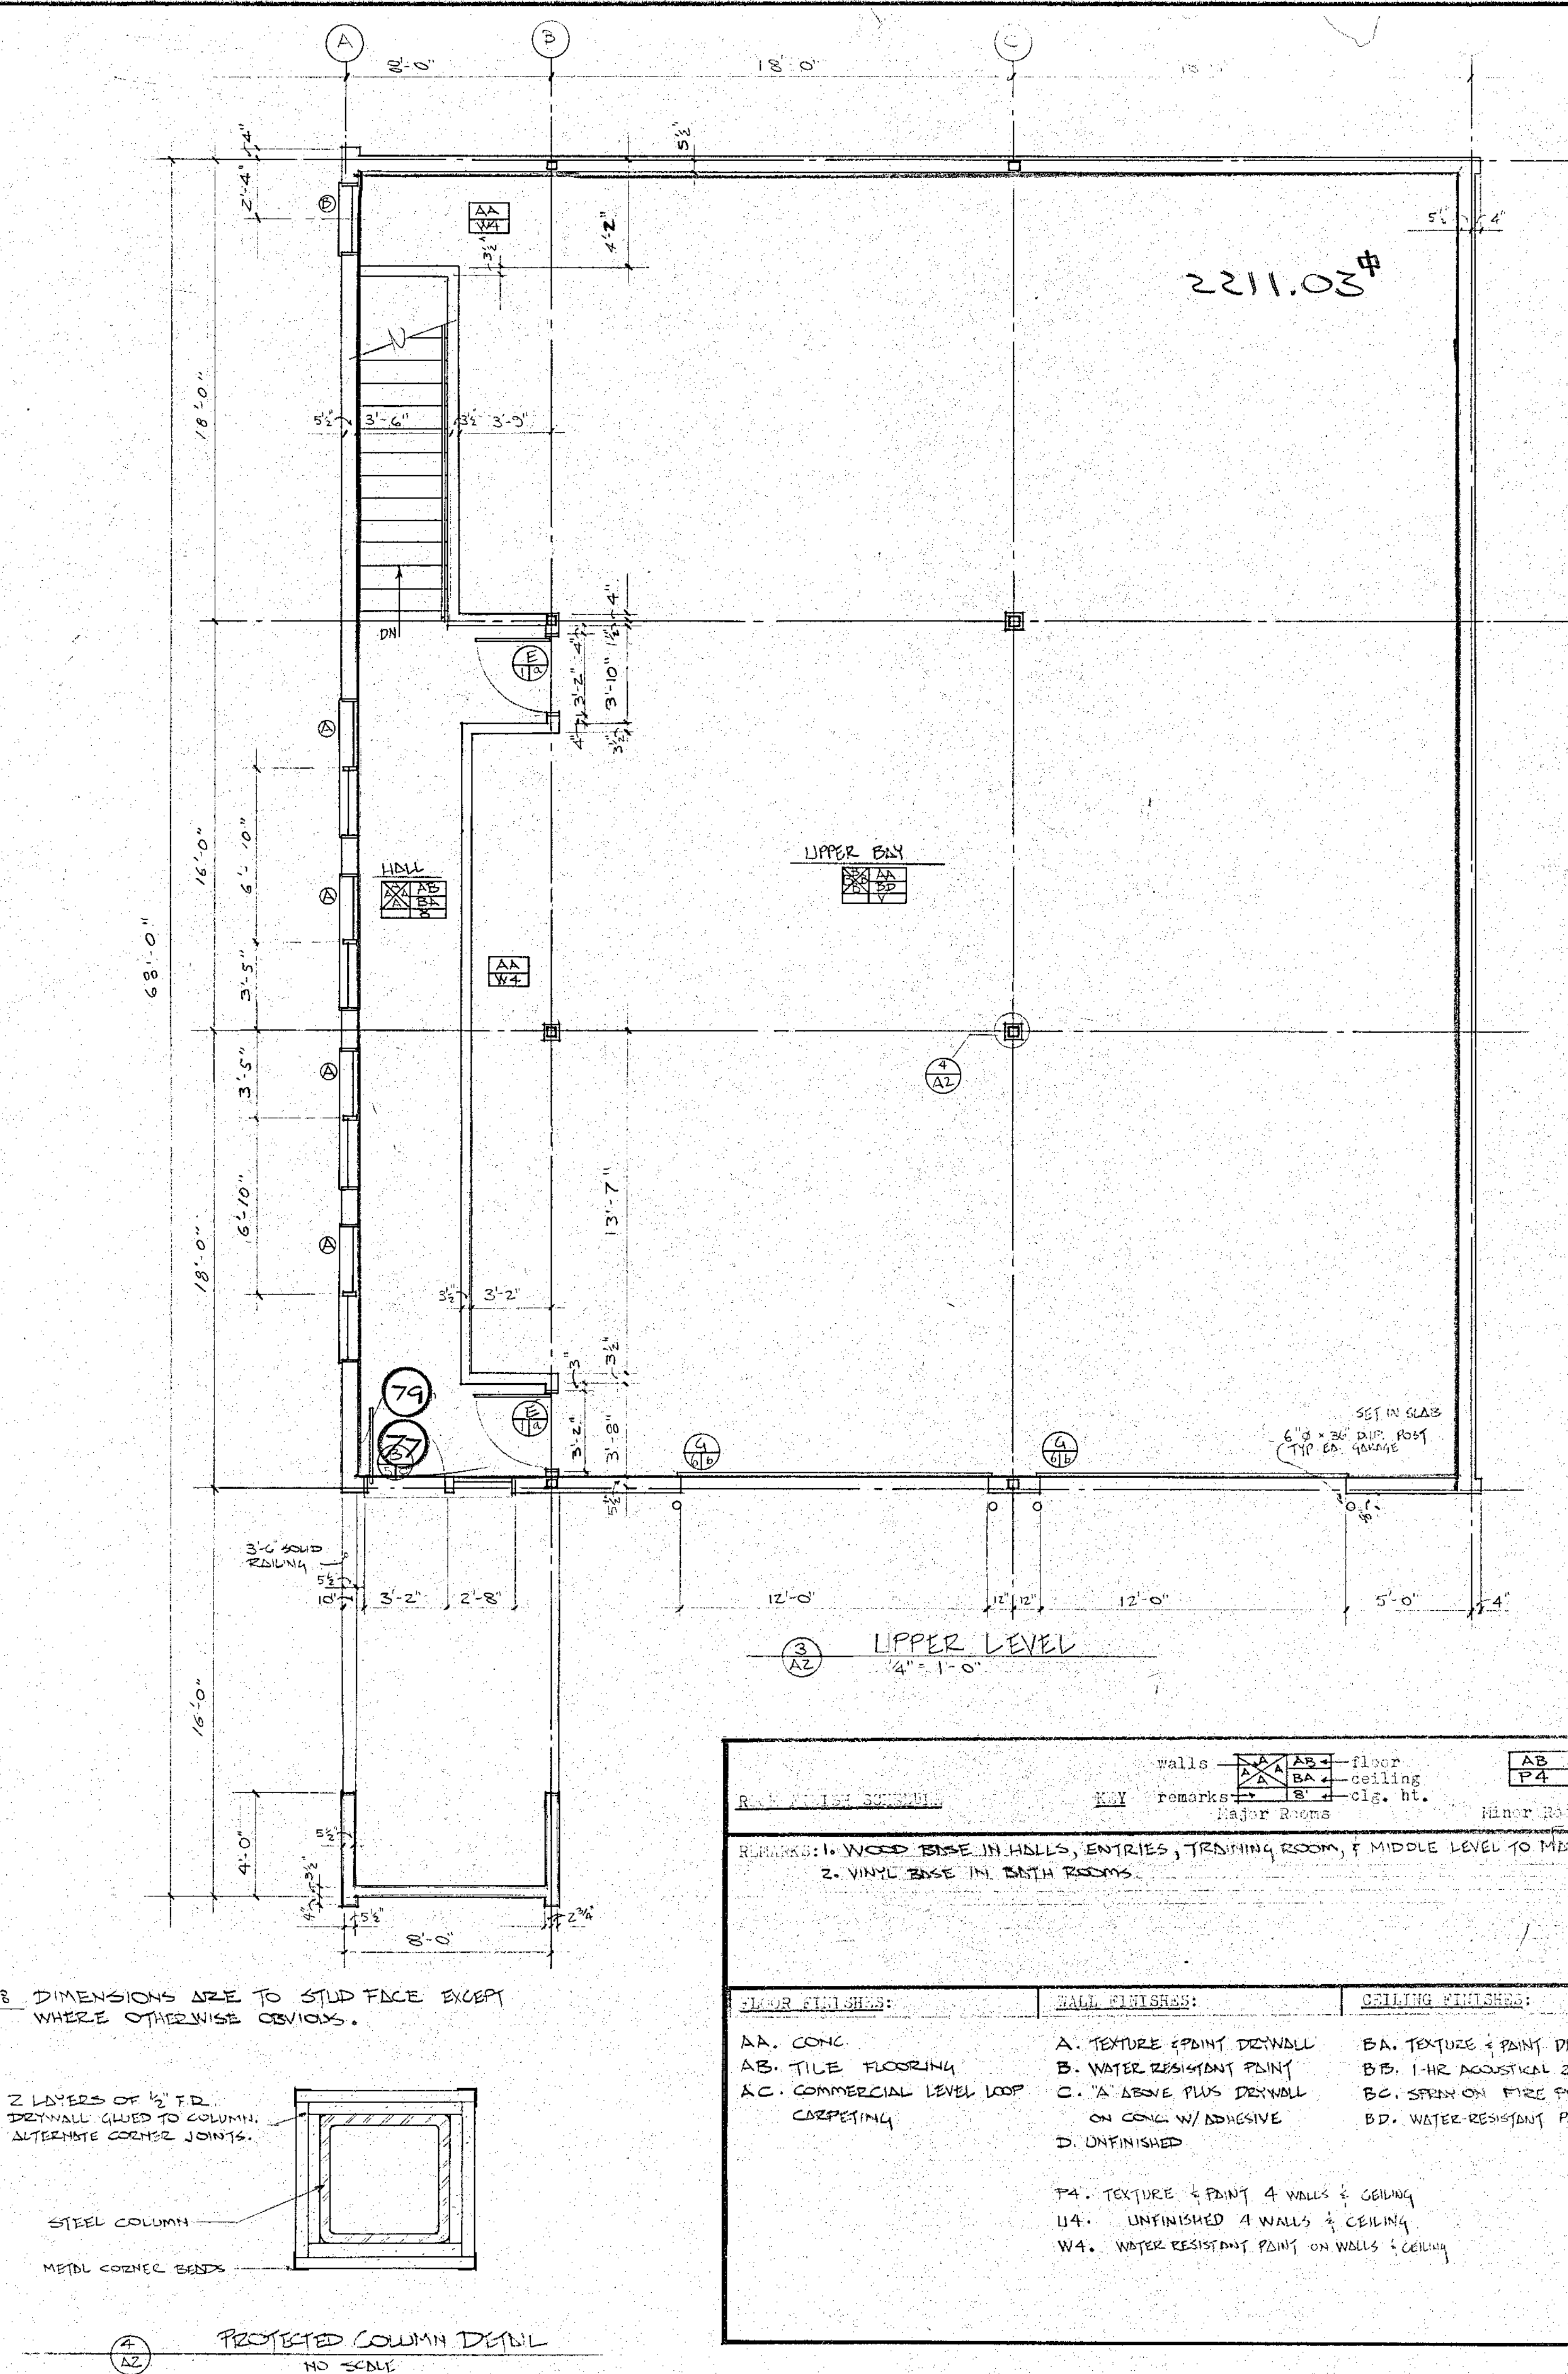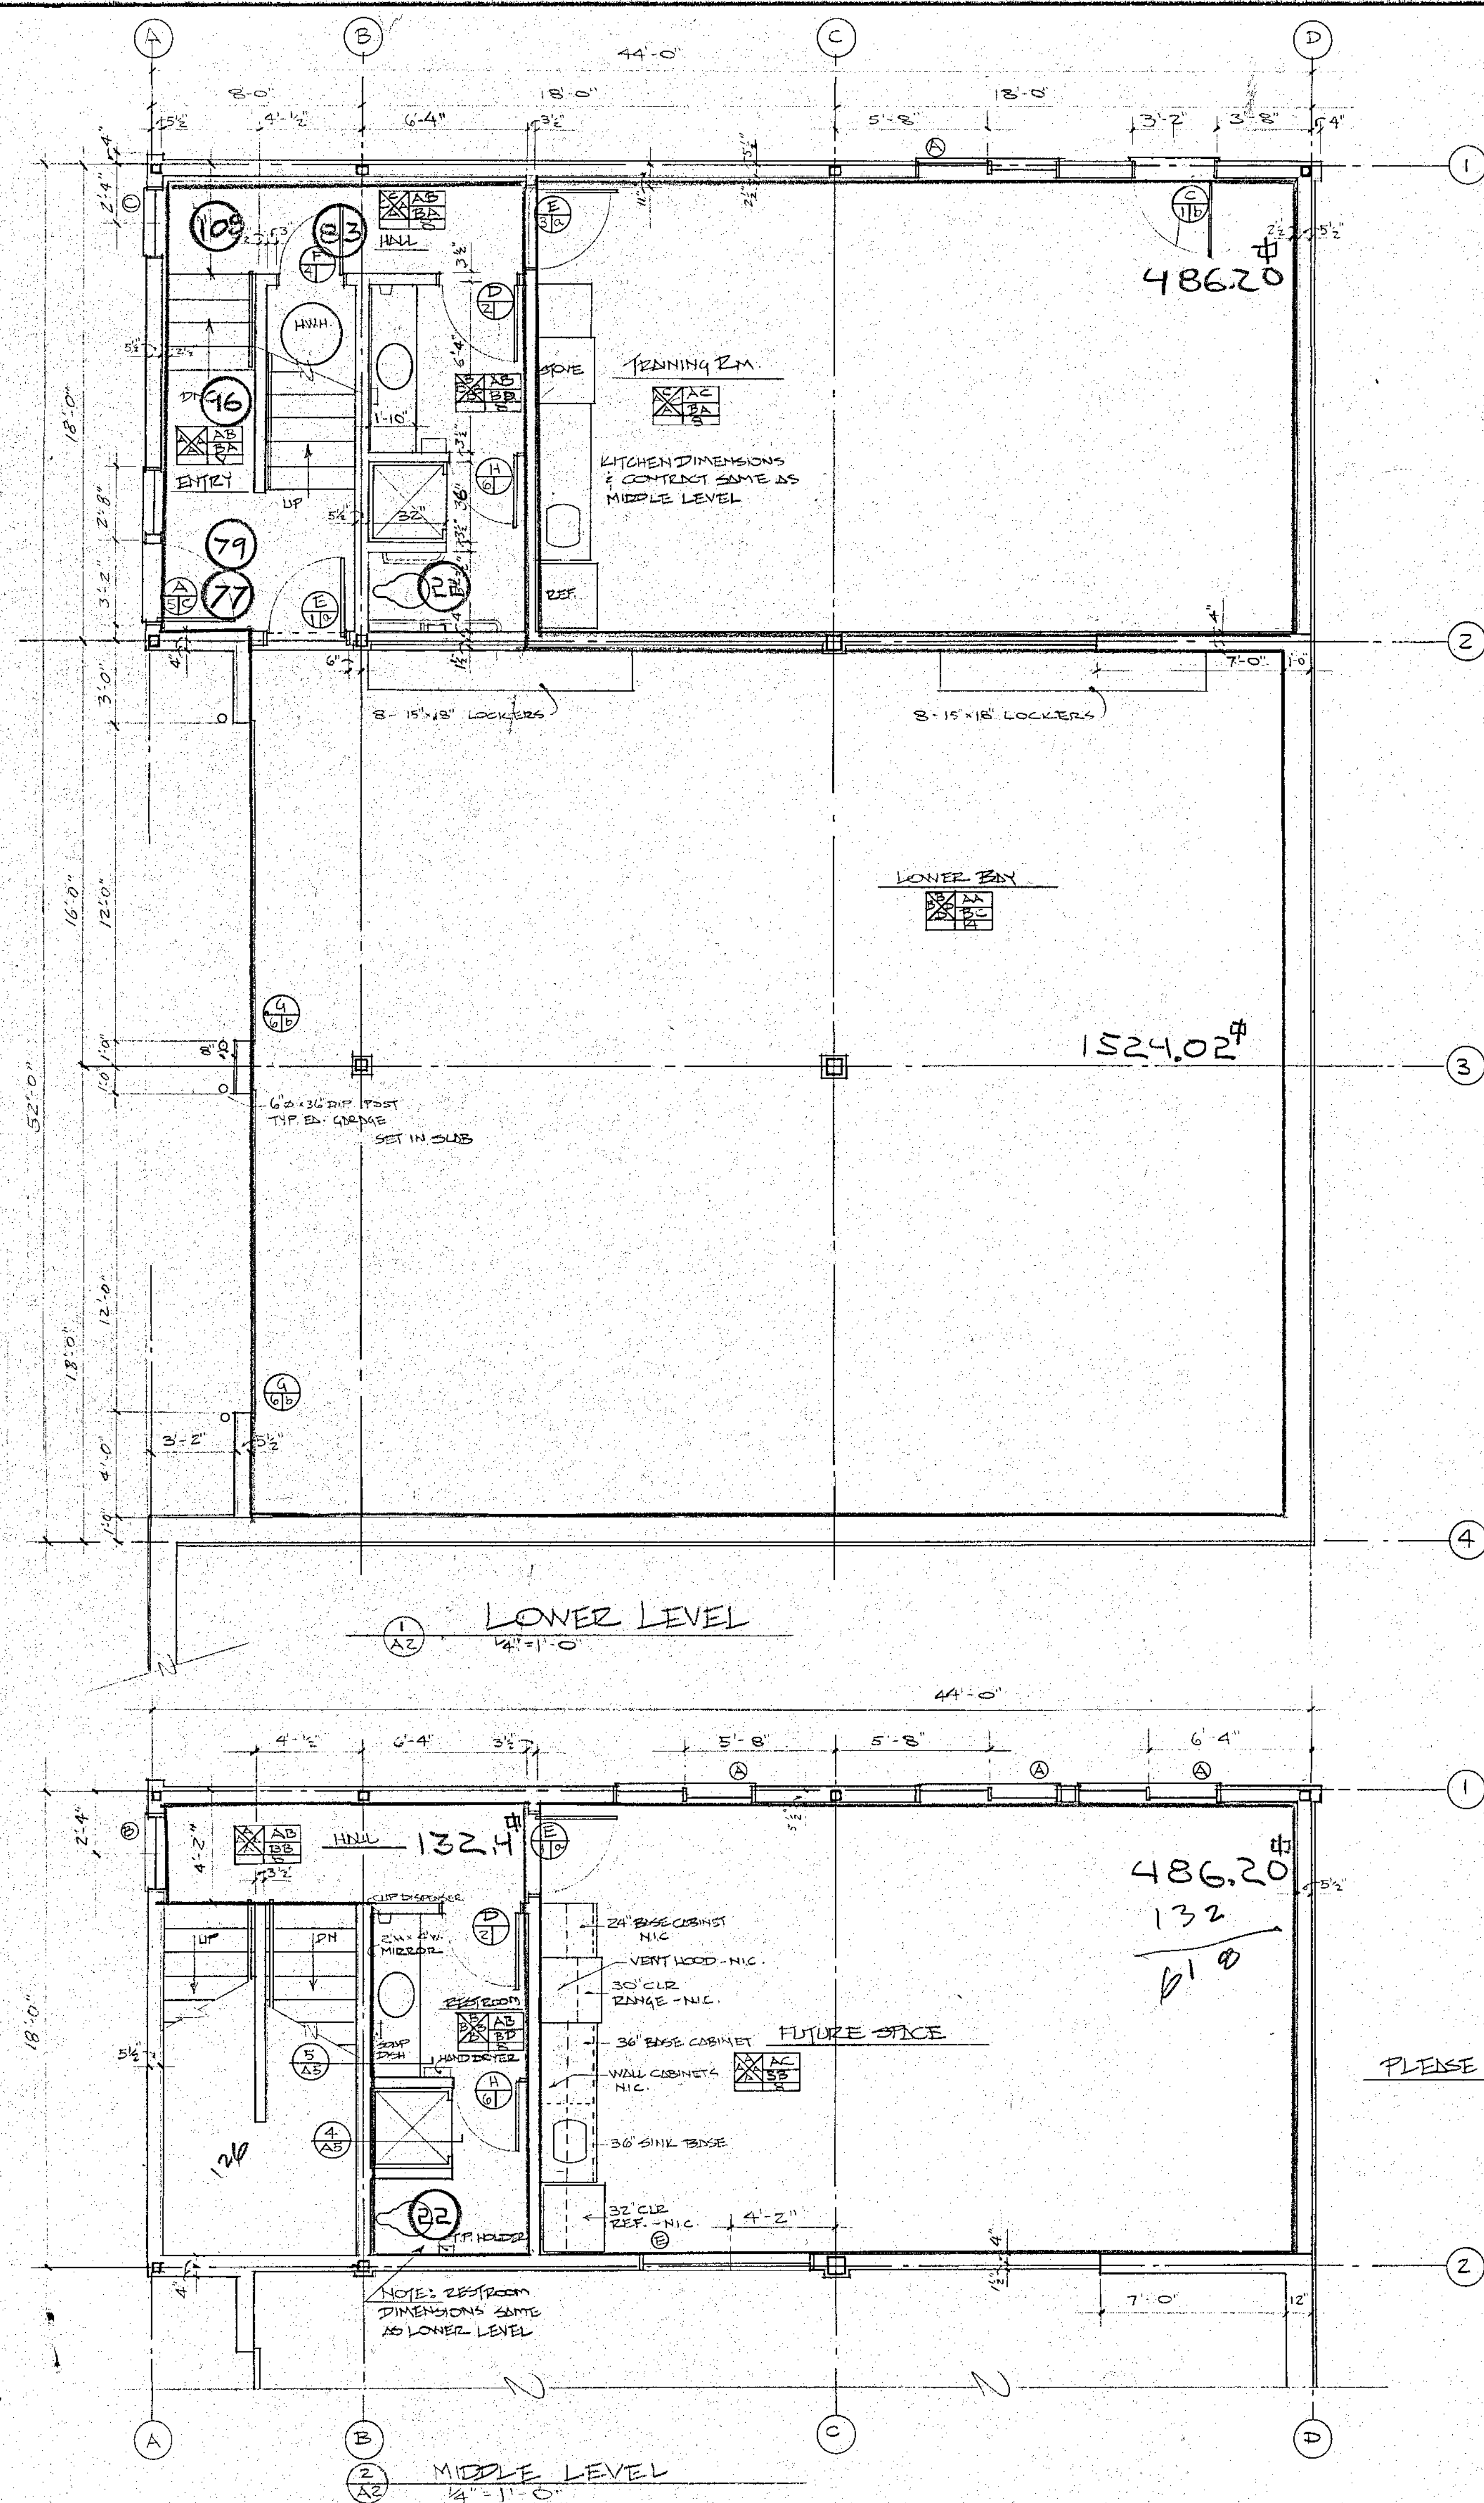


FLOOR FINISHES:		WALL FINISHES:		CEILING FINISHES:		CEILING HT.
AA. CONC.		A. TEXTURE & PAINT DRYWALL		BA. TEXTURE & PAINT DRYWALL	AS LISTED;	
AB. TILE FLOORING		B. WATER RESISTANT PAINT		BB. 1 HR. ACoustical 2x4 PANELS "V" INDICATES		
AC. COMMERCIAL LEVEL LOOP CARPETING		C. "A" ABOVE PLUS DRYWALL ON CONC. W/ ADHESIVE		BC. SPRINKLER FIRE PROTECTING CEILING VARIES.		
		D. UNFINISHED		BD. WATER RESISTANT PAINT		
				PA. TEXTURE & PAINT 4 WALLS & CEILING		
				UA. UNFINISHED 4 WALLS & CEILING		
				WA. WATER RESISTANT PAINT ON WALLS & CEILING		

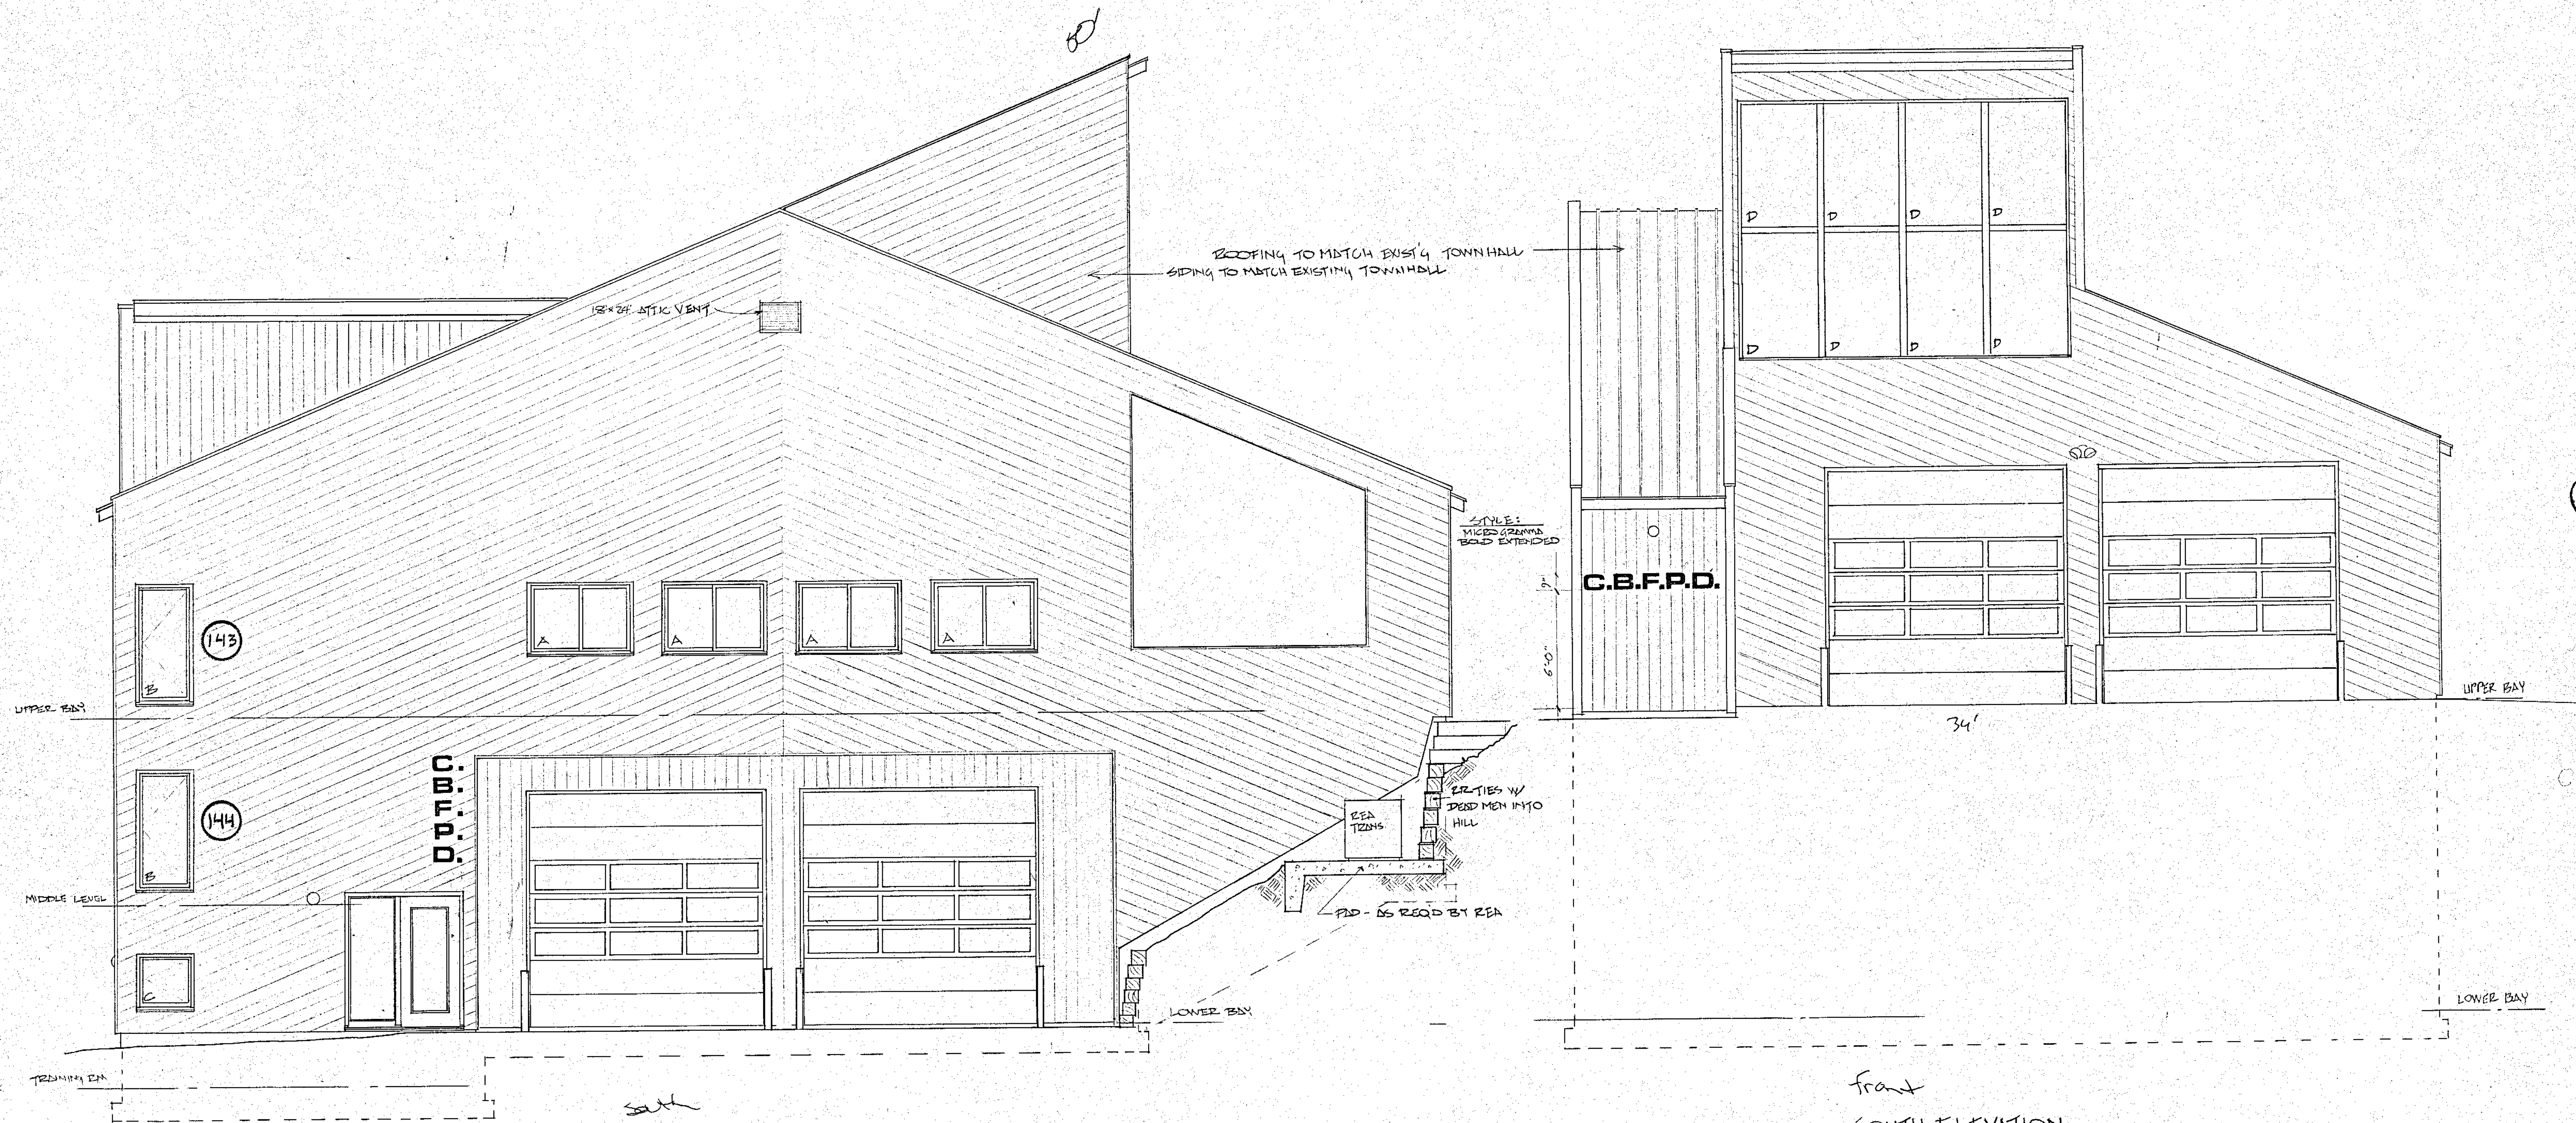


WINDOW SCHEDULE				
	BRAND	MODEL	RO. HD. HT.	R.O. W x HT.
A	WEATHER SHIELD	SLIDER 28x36	6'-10 1/2"	5'-3 3/4" x 3'-6 3/4"
B	"	CASMT C11-28x36	"	2'-9" x 6'-1 1/2"
C	"	CASMT C11-28x36	"	2'-9" x 2'-5 1/2"
D	"	46x76 P110 DOOR UNITS	"	46" x 78"
E	"	34x76 P110 DOOR UNITS	"	36" x 78"

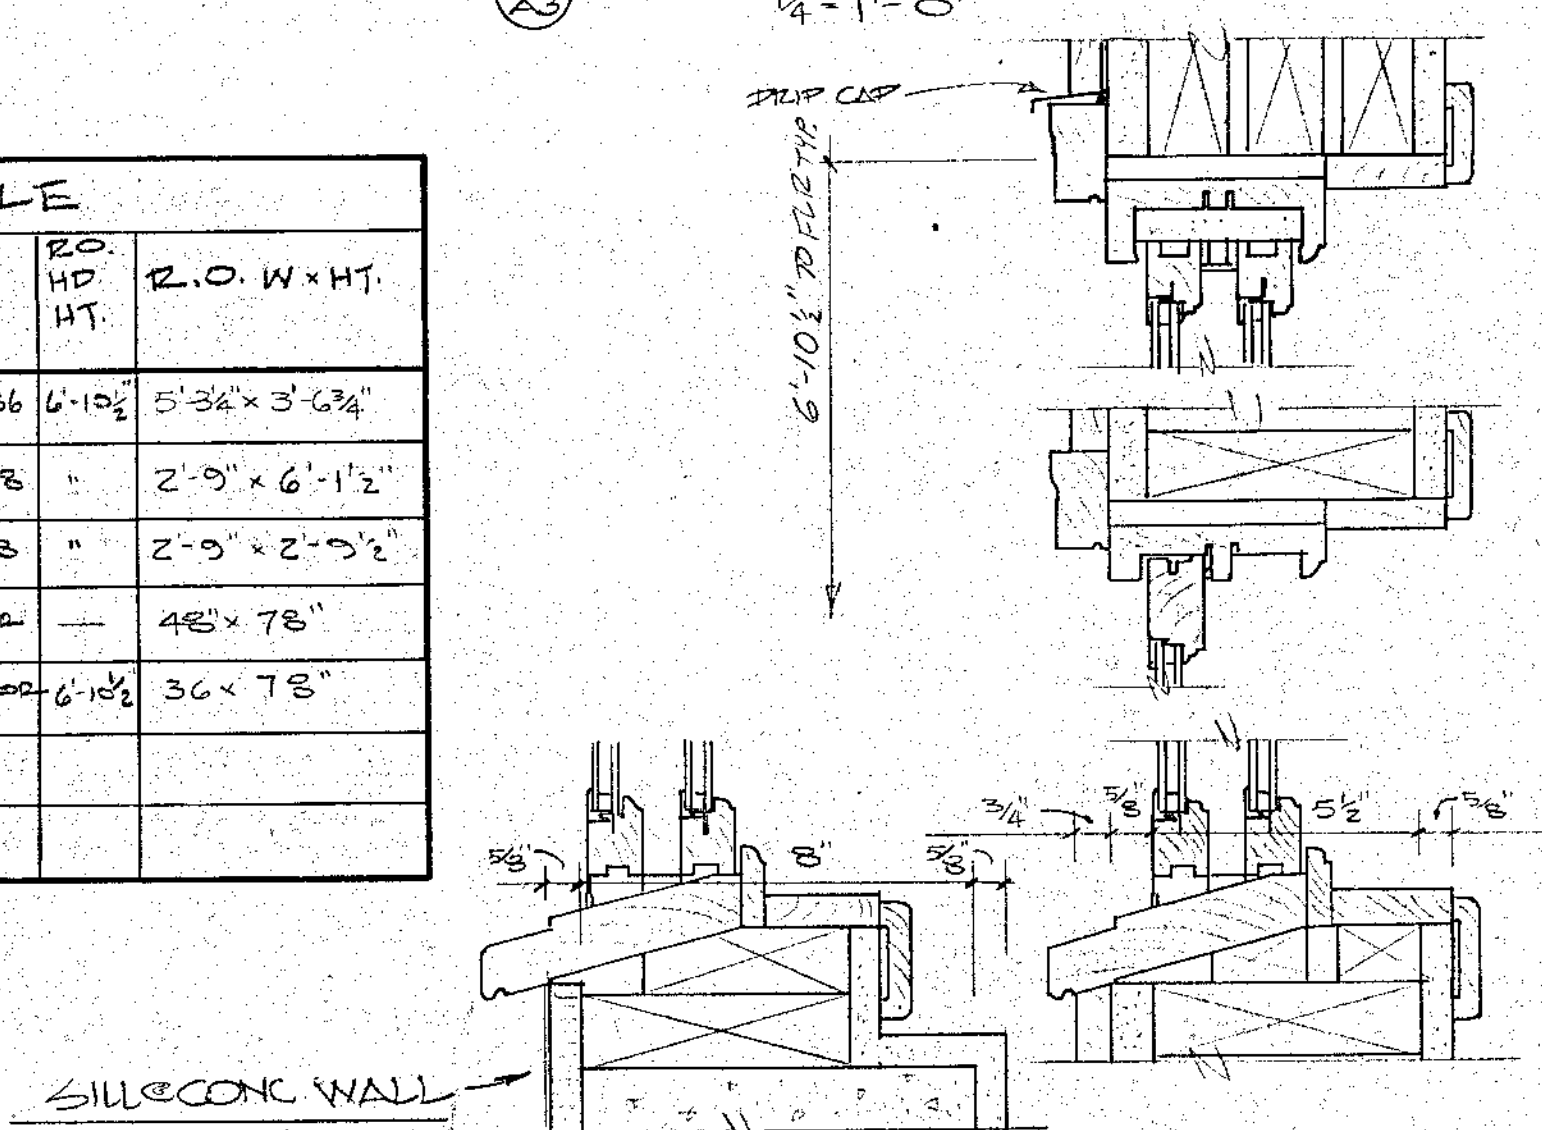



3 A3 SLIDER WINDOW DETAIL

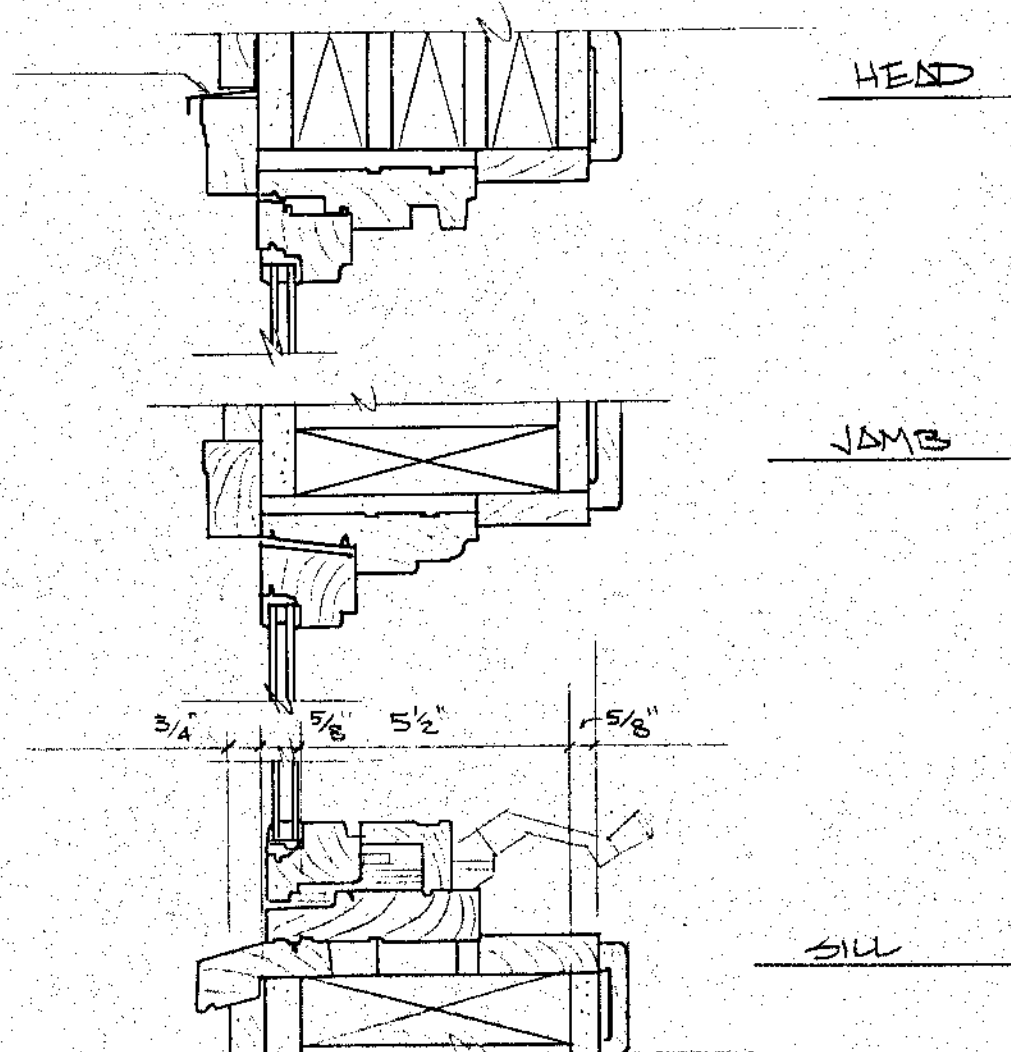


4 A3 CASEMENT DETAIL

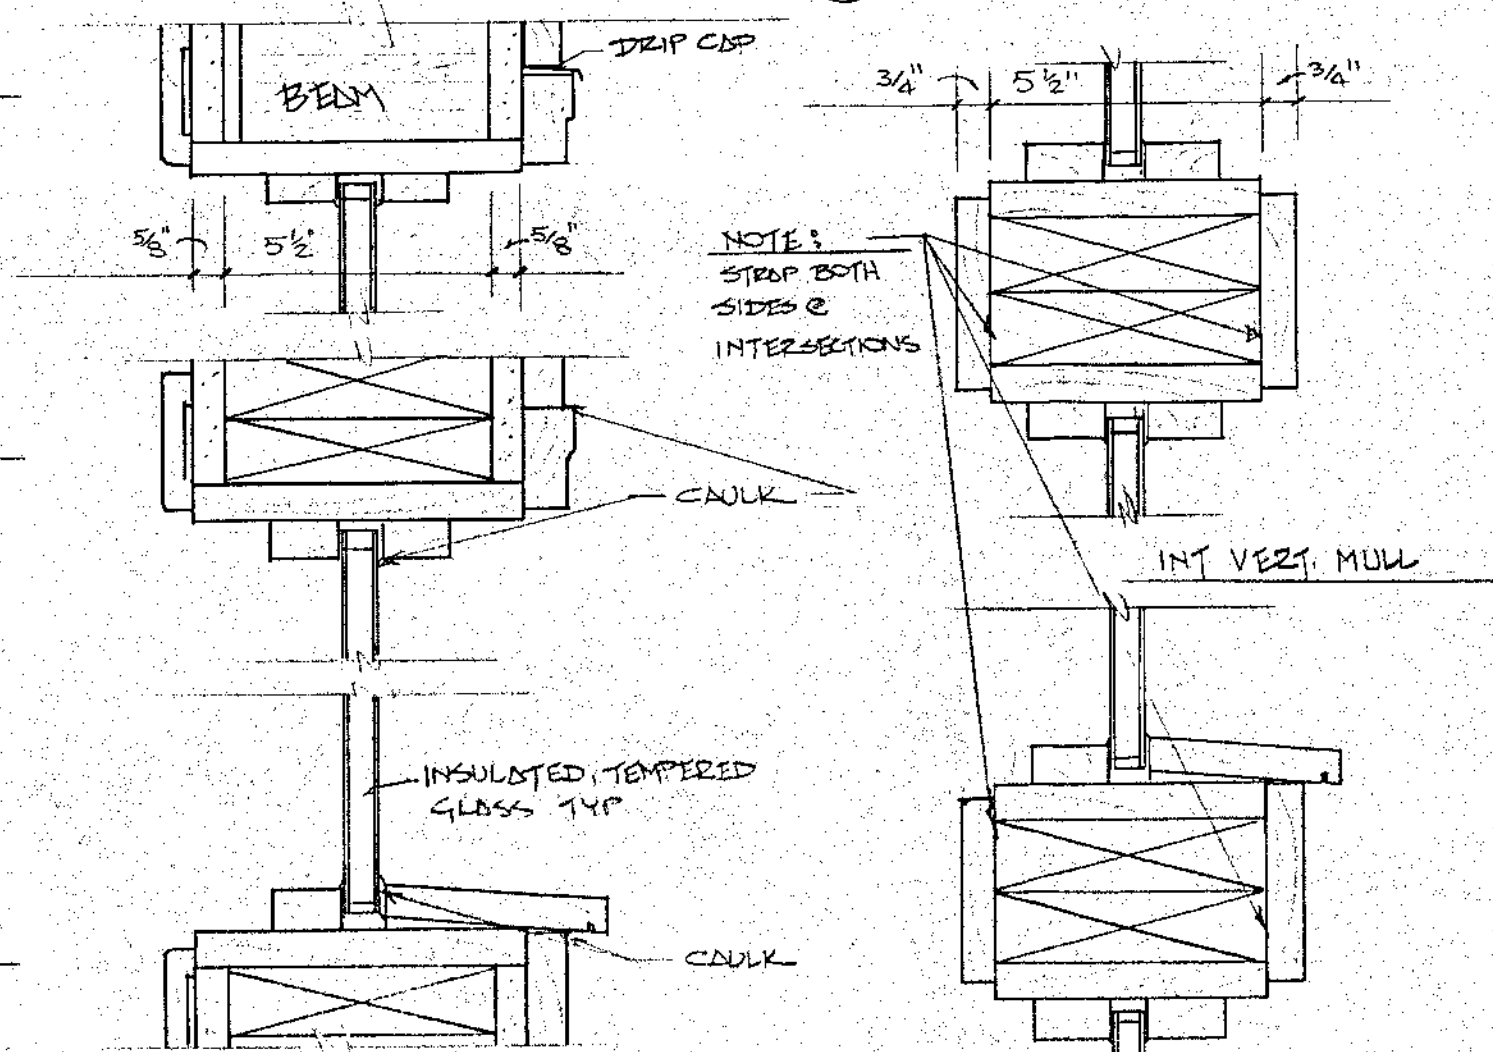






5 A3 FIXED GLASS DETAILS

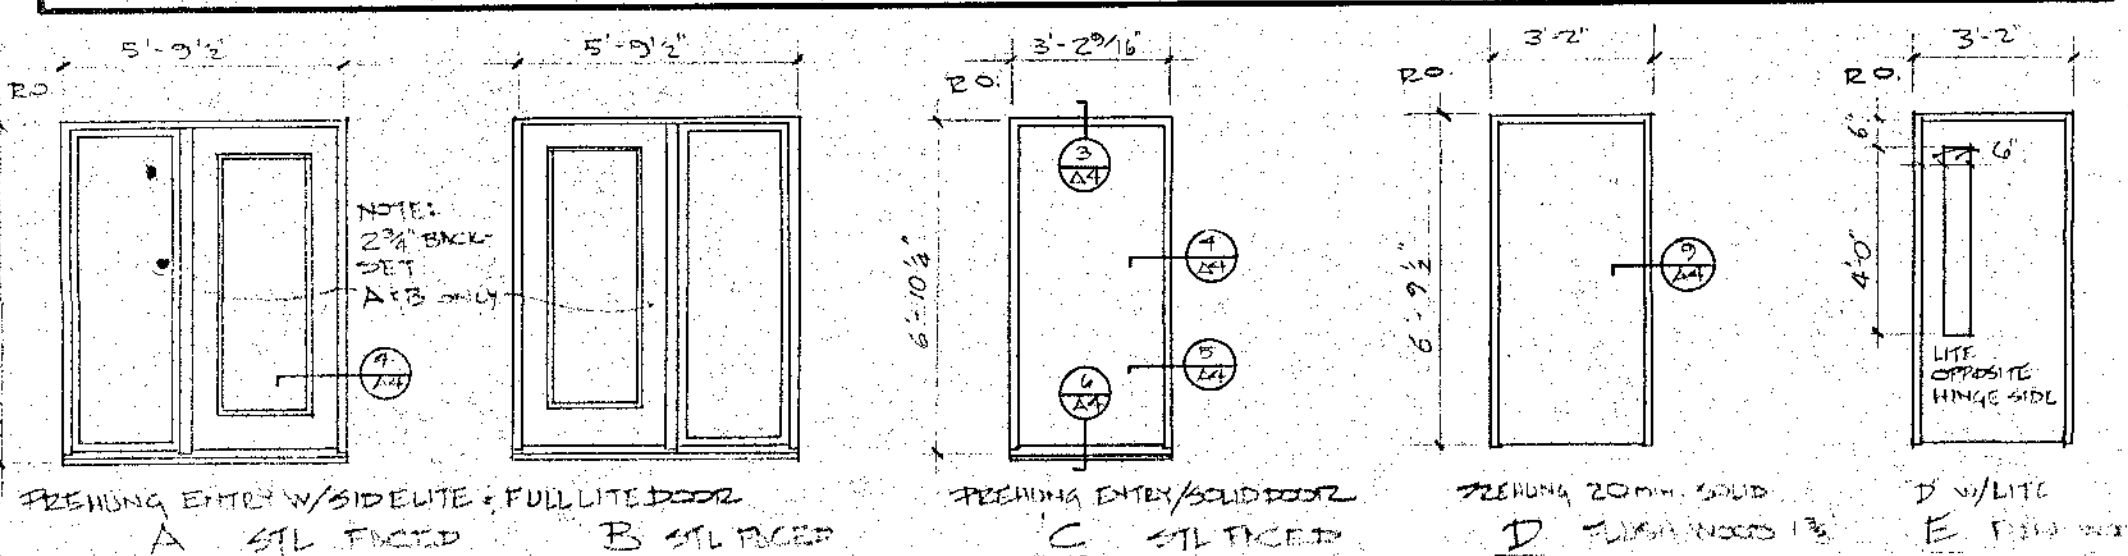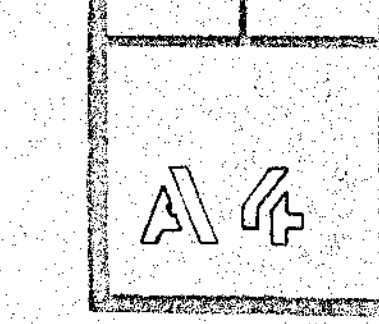





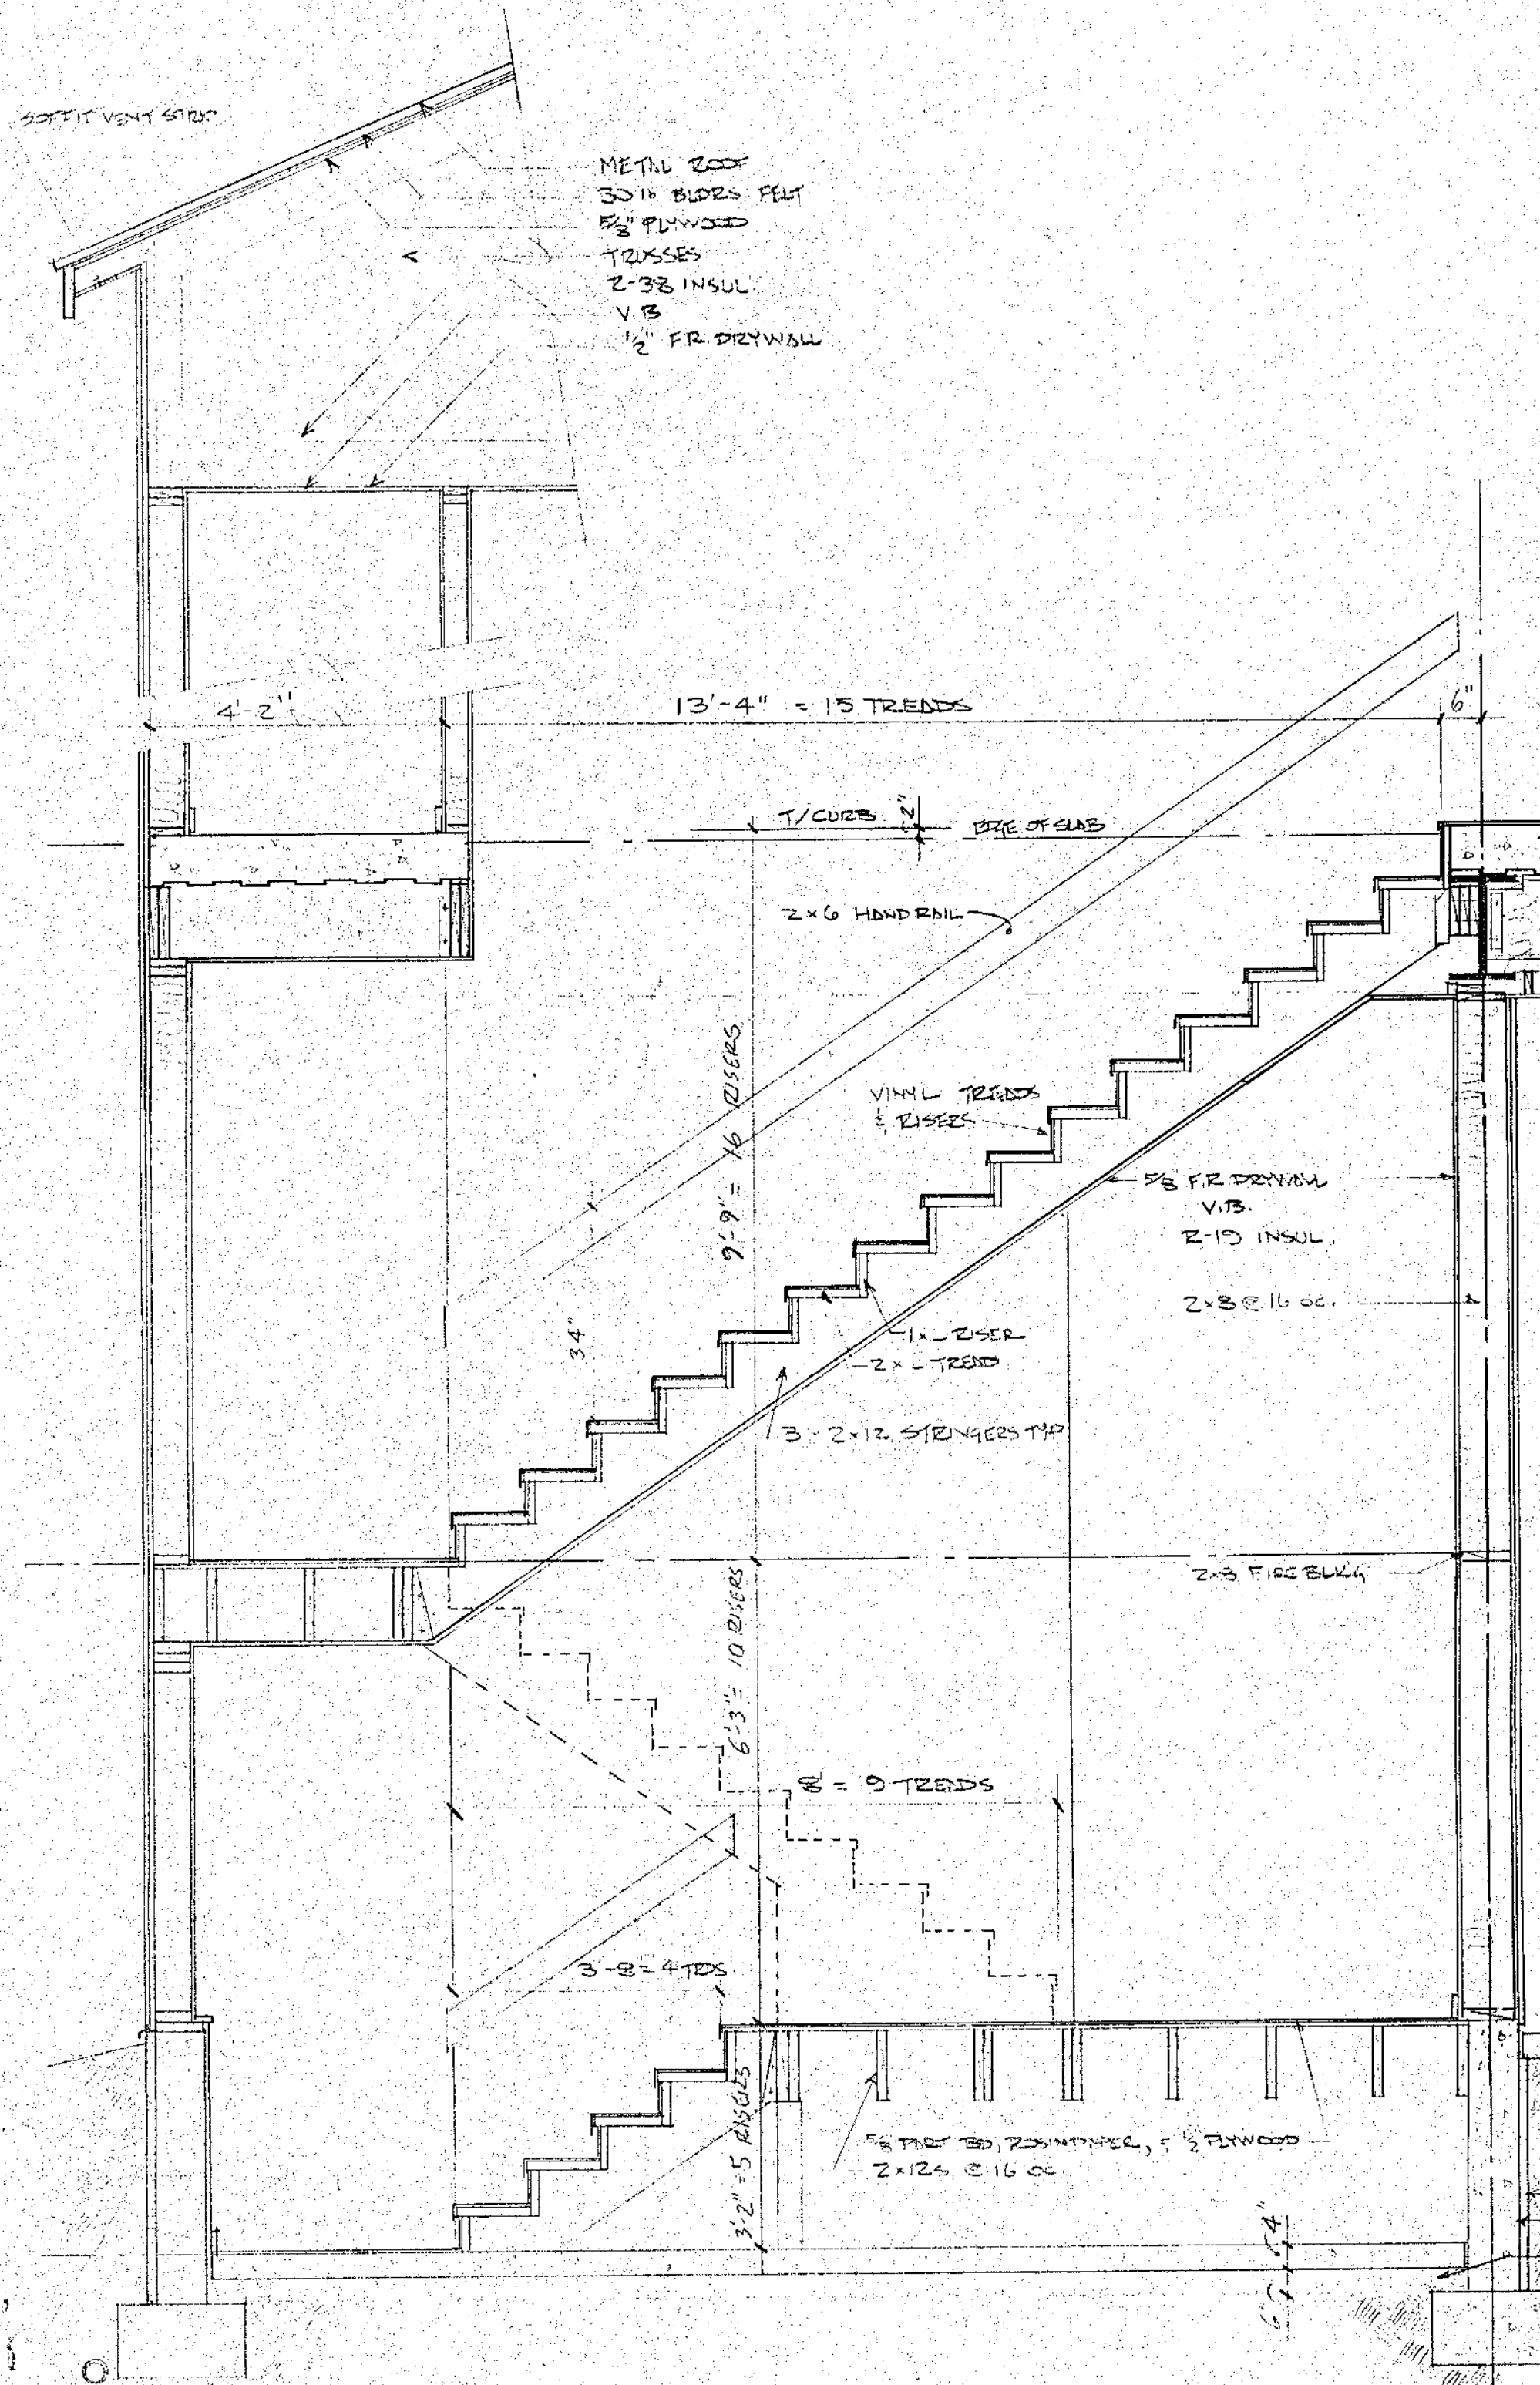


STAIR DETAIL
1/2" = 1'-0"



NOTE: REFER TO STRUCTURAL SHITS FOR
FND & F14 SIZES.

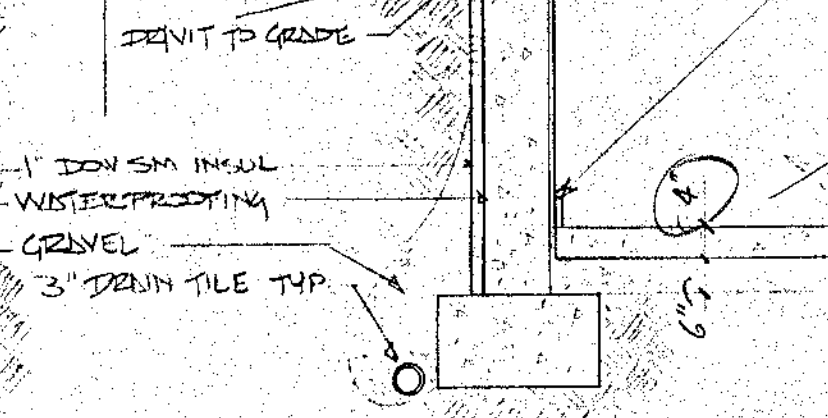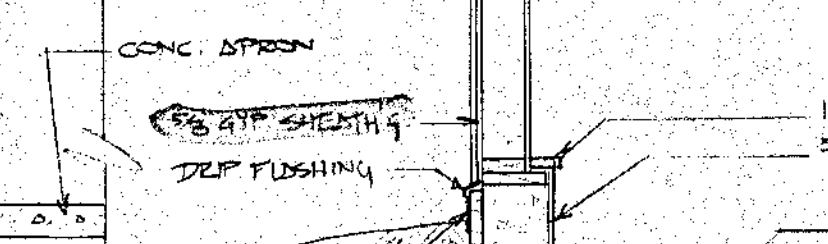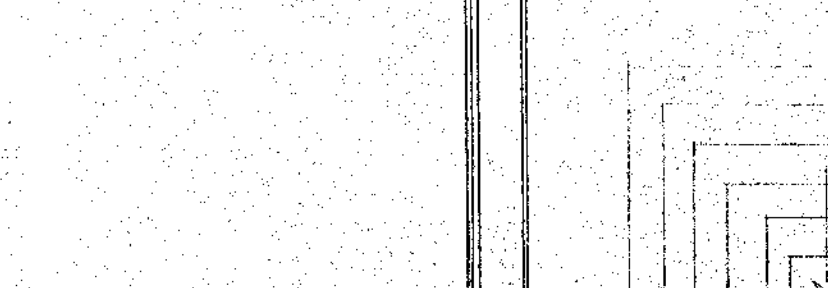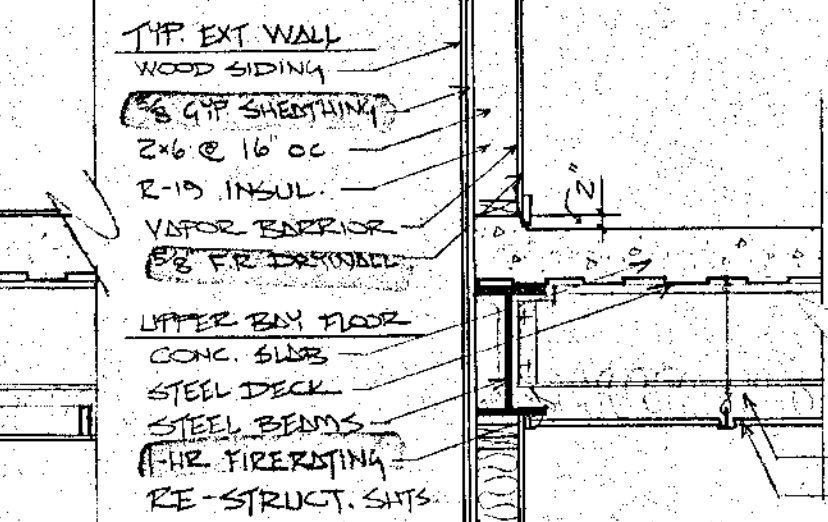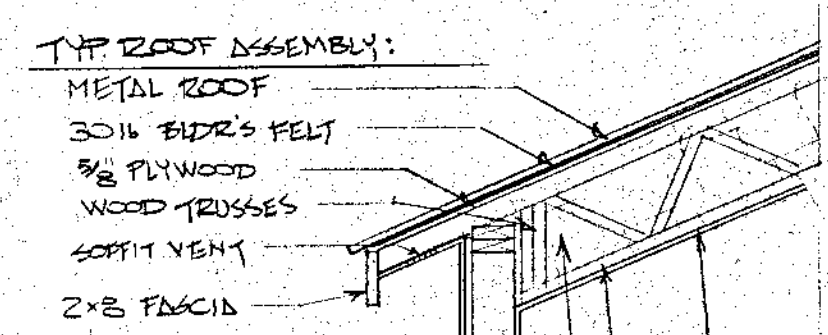



WALL SECTION
1/2" = 1'-0"

 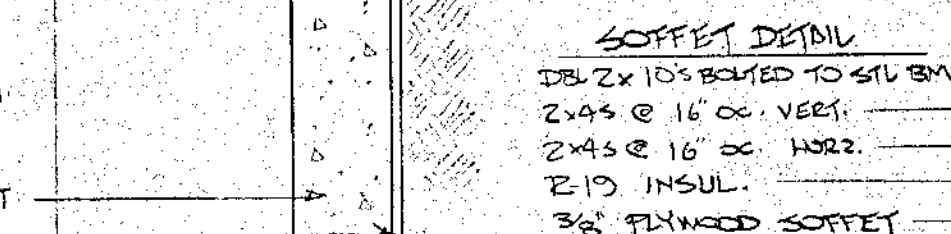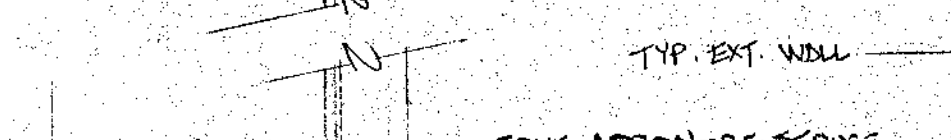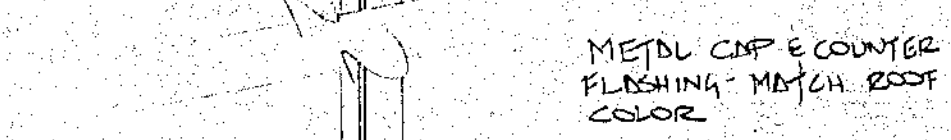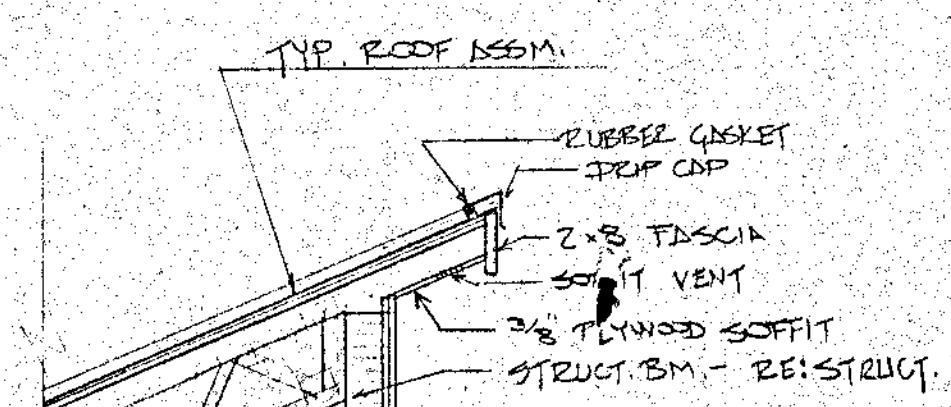










WALL SECTION
1/2" = 1'-0"

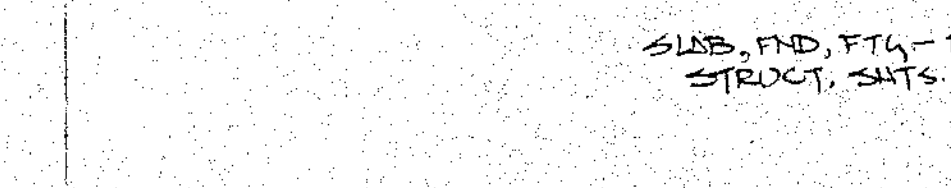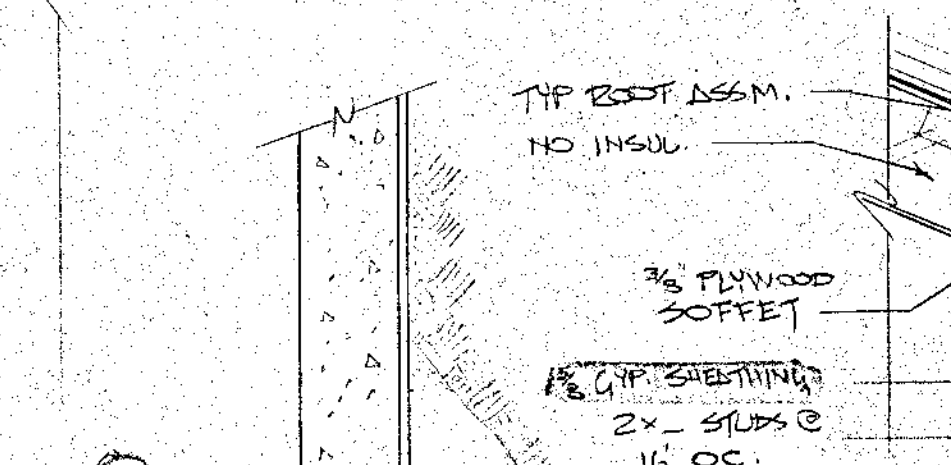




WALL SECTION
1/2" = 1'-0"

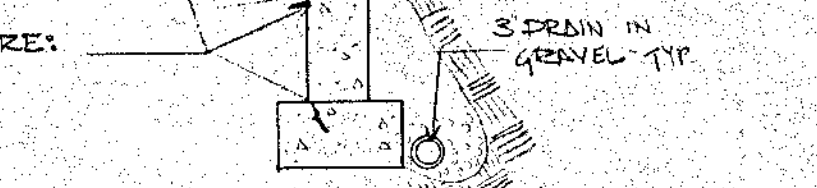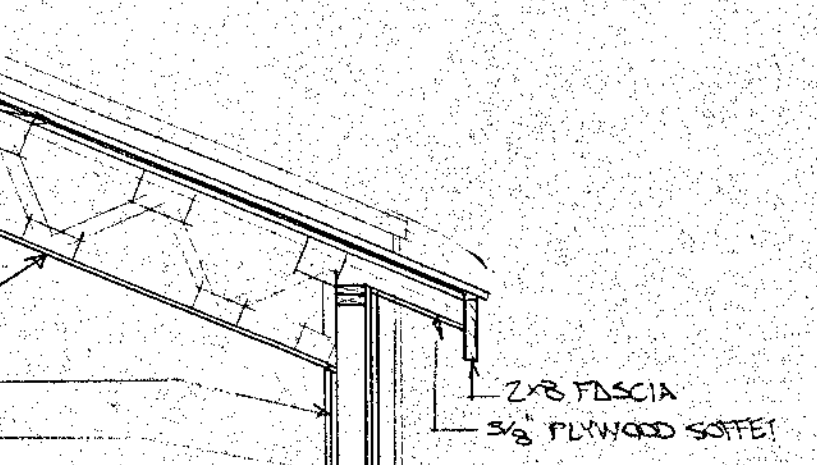








ENTRY SECTION
1/2" = 1'-0"

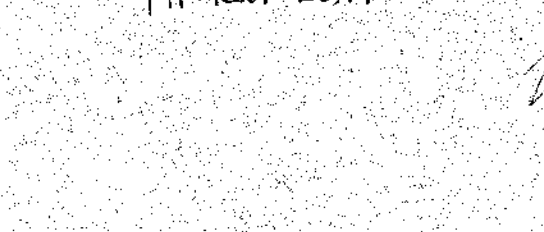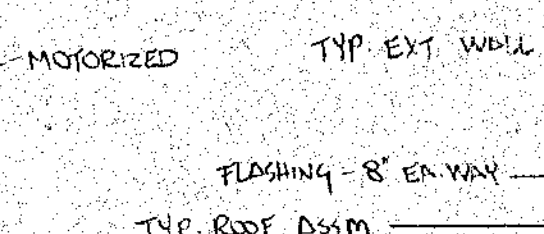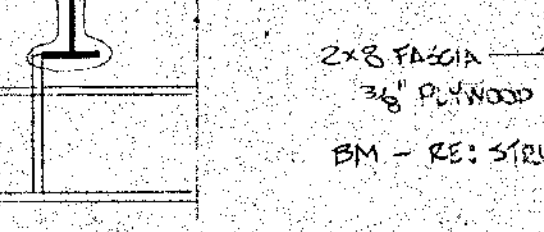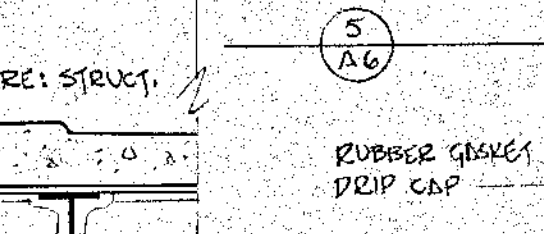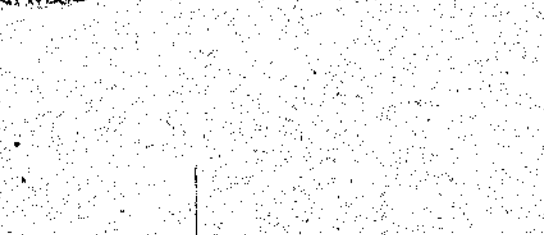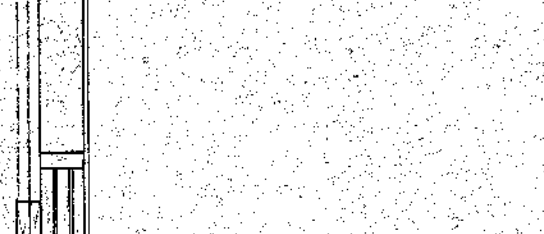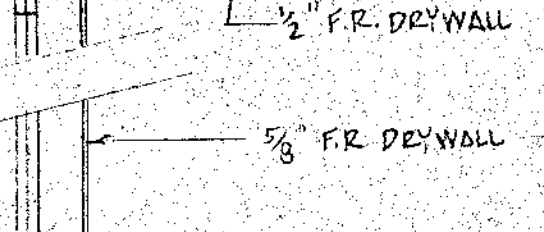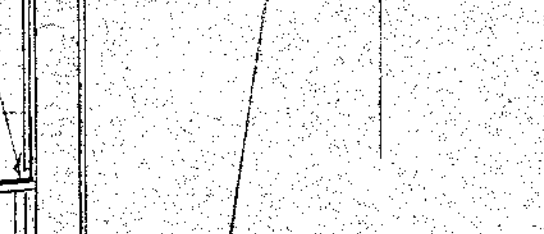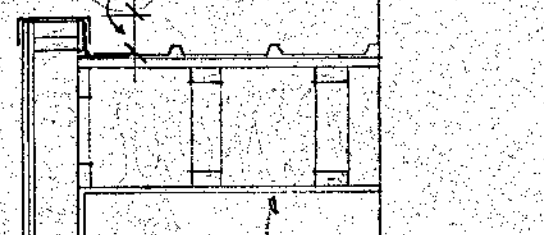



WALL SECTION
1/2" = 1'-0"

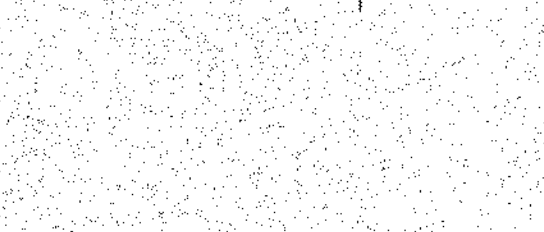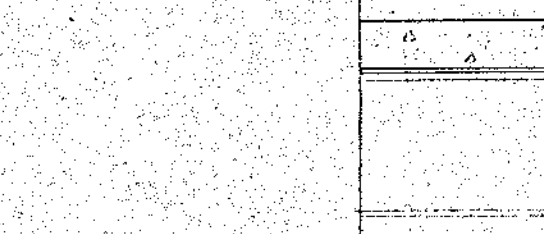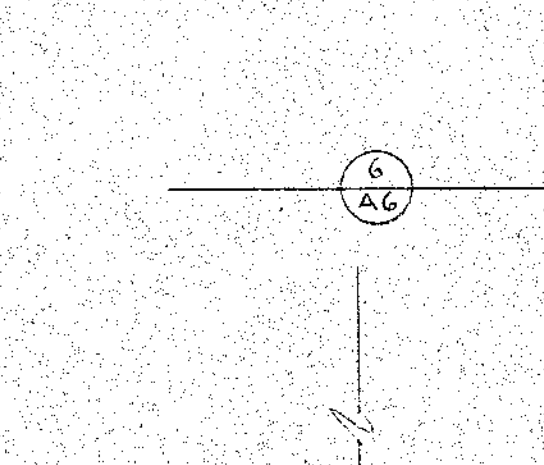

WALL DETAIL @ GRADE
1/2" = 1'-0"

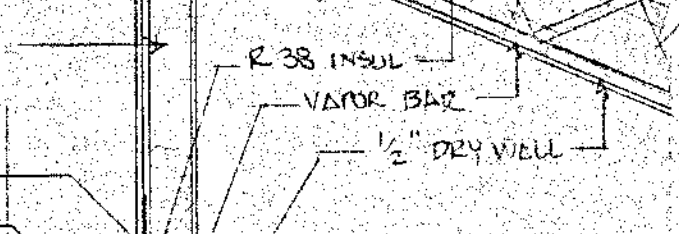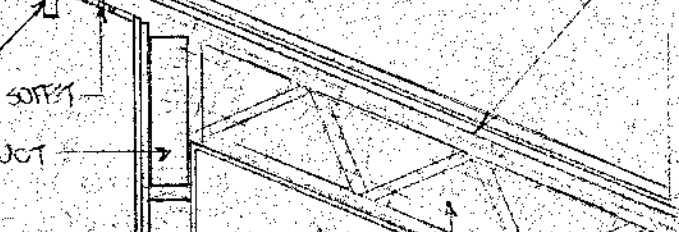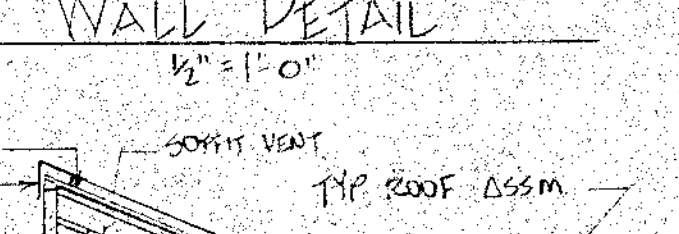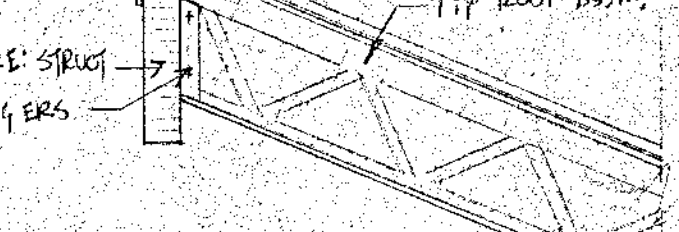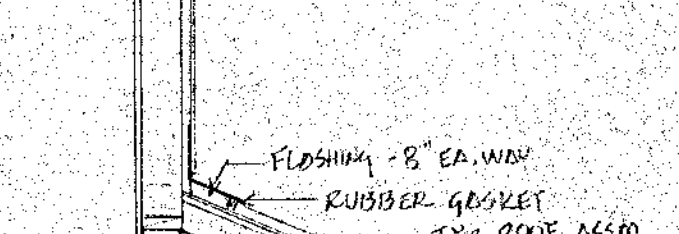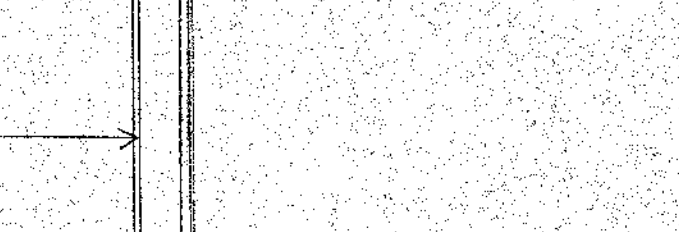
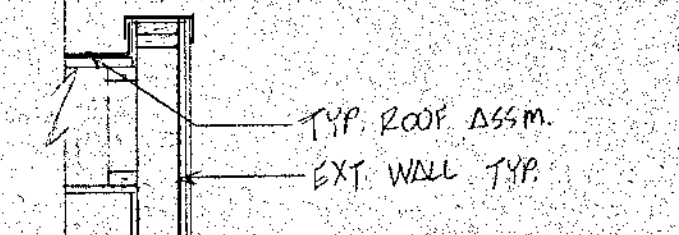


WALL SECTION
1/2" = 1'-0"

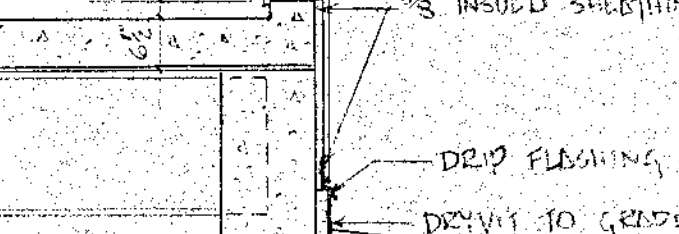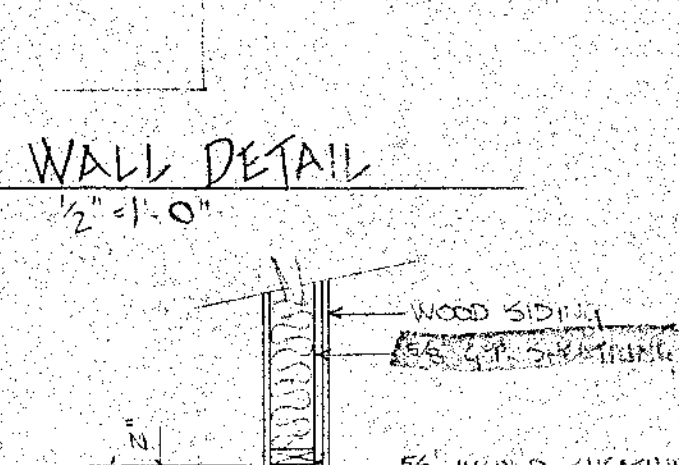

WALL DETAIL @ GRADE
1/2" = 1'-0"

5
C.B.I.F.I.D. RECREATION
FOUNDATION

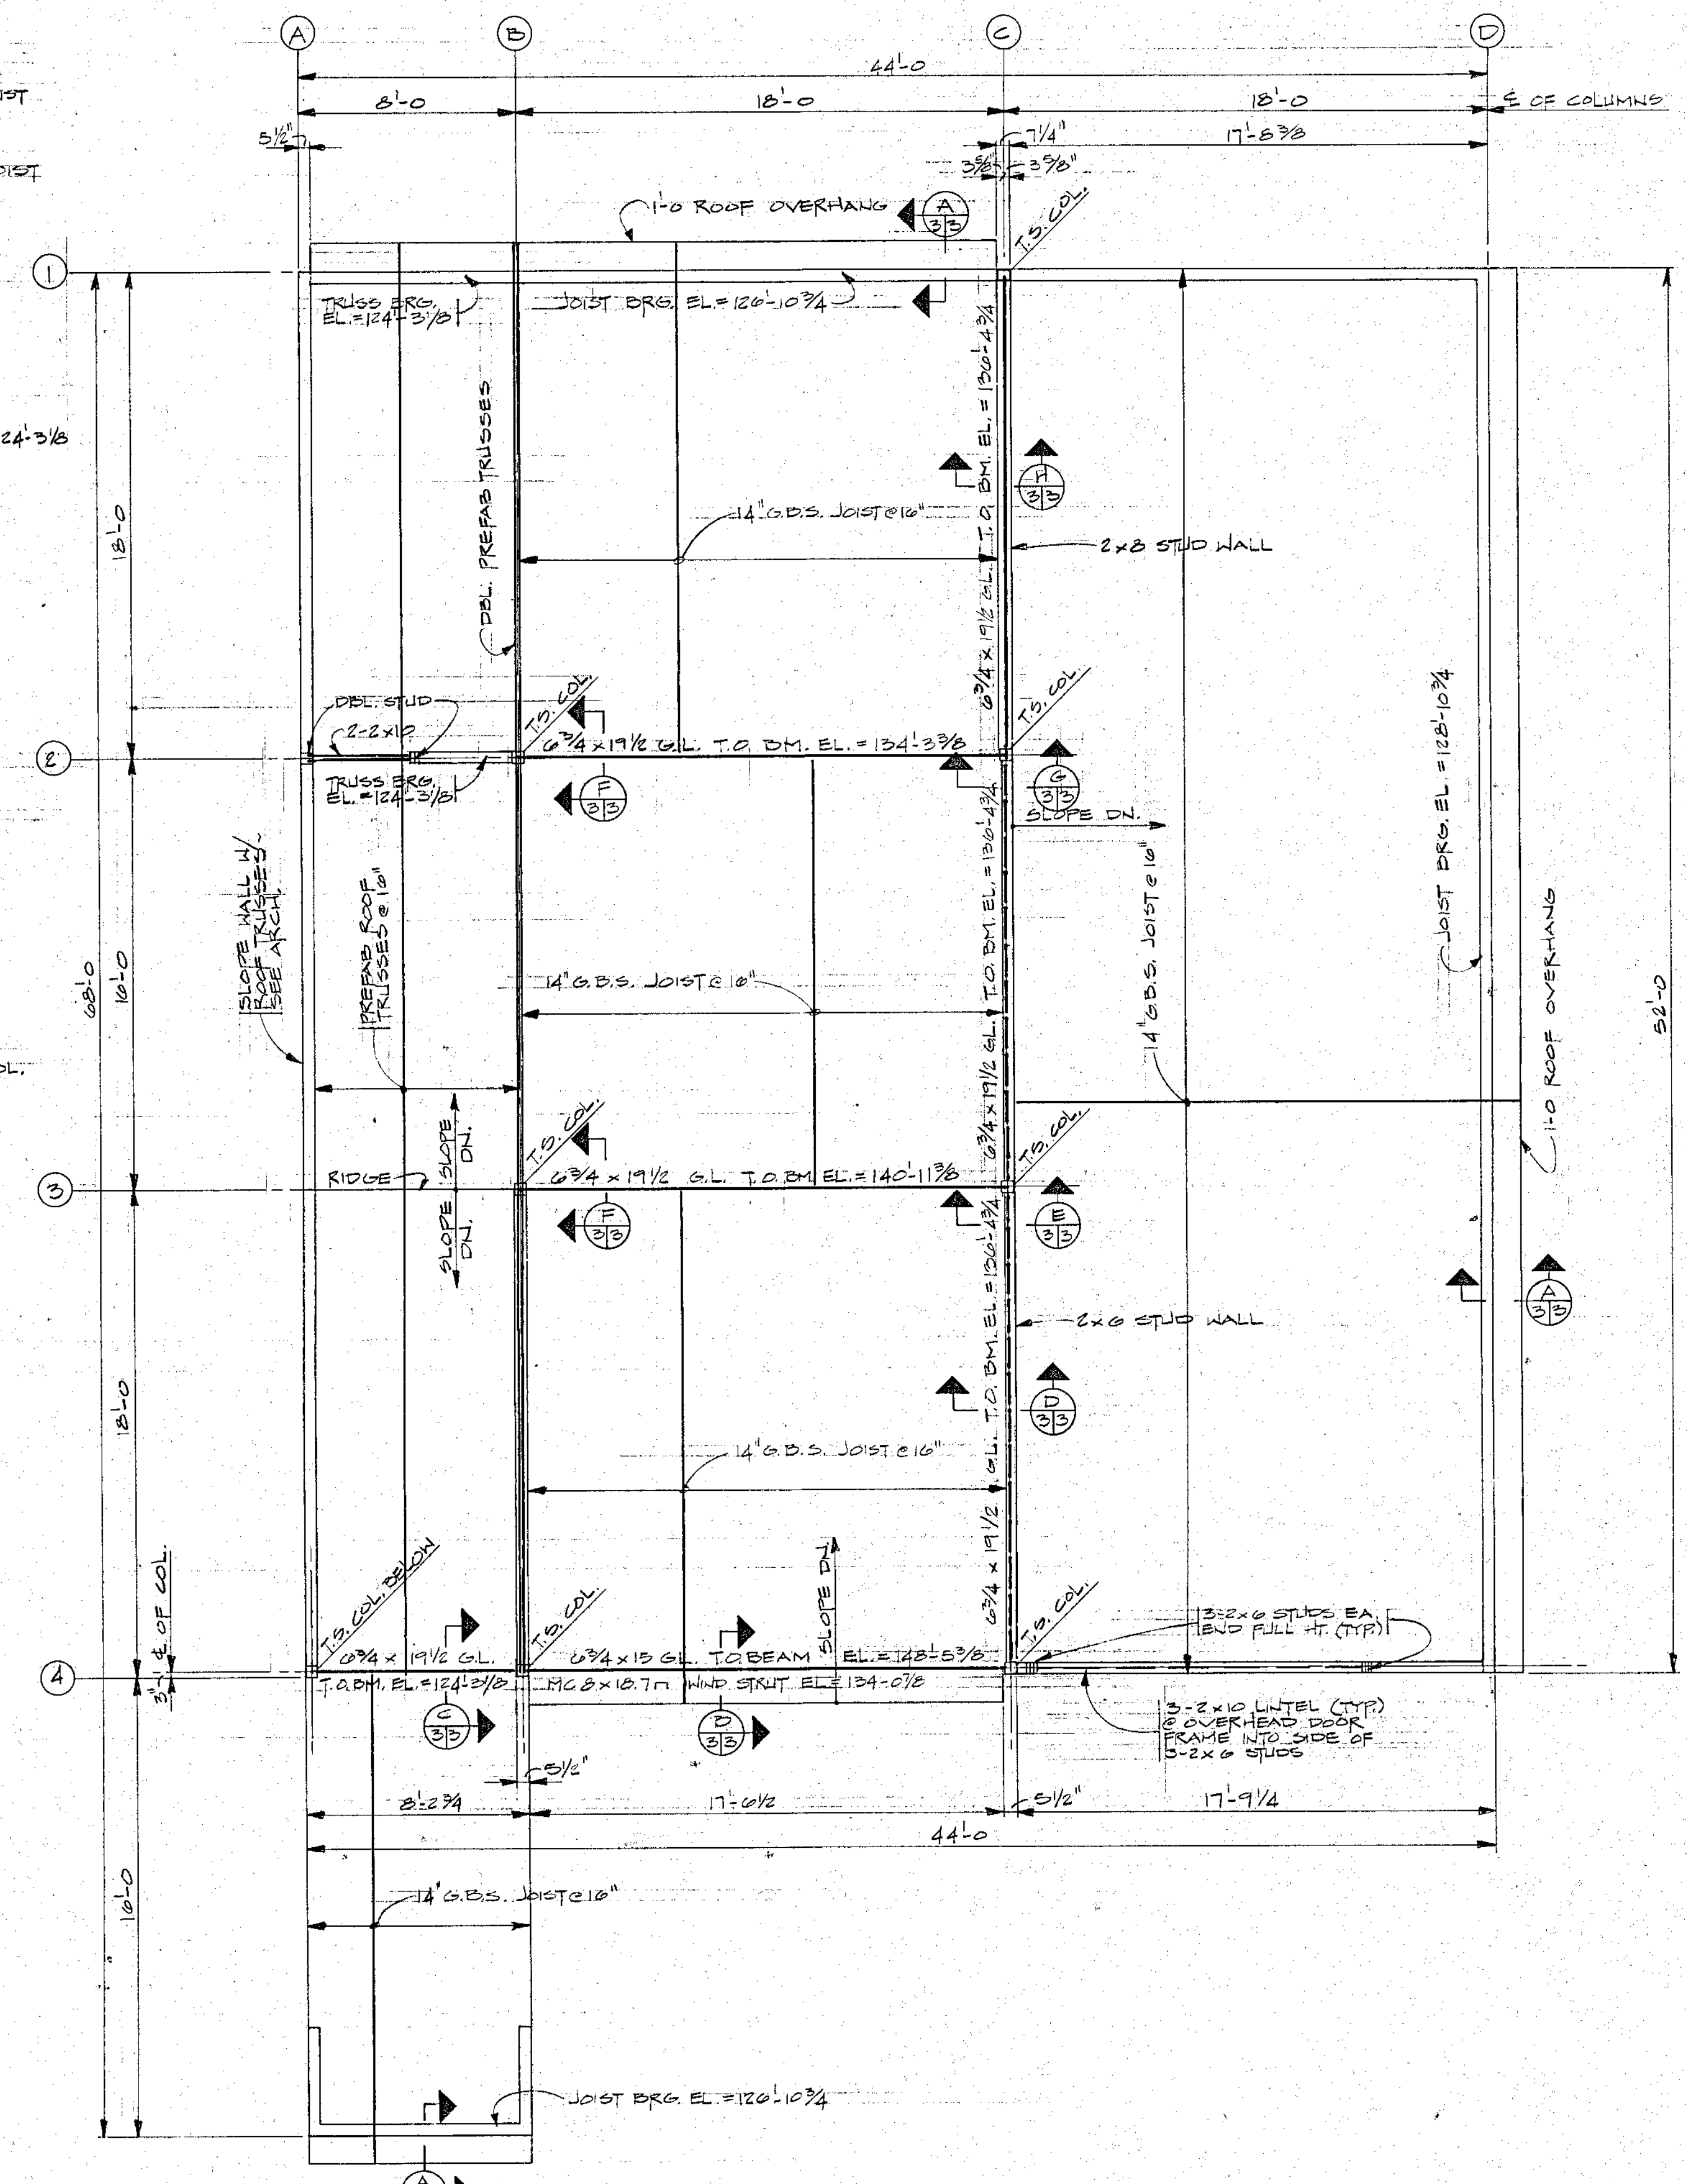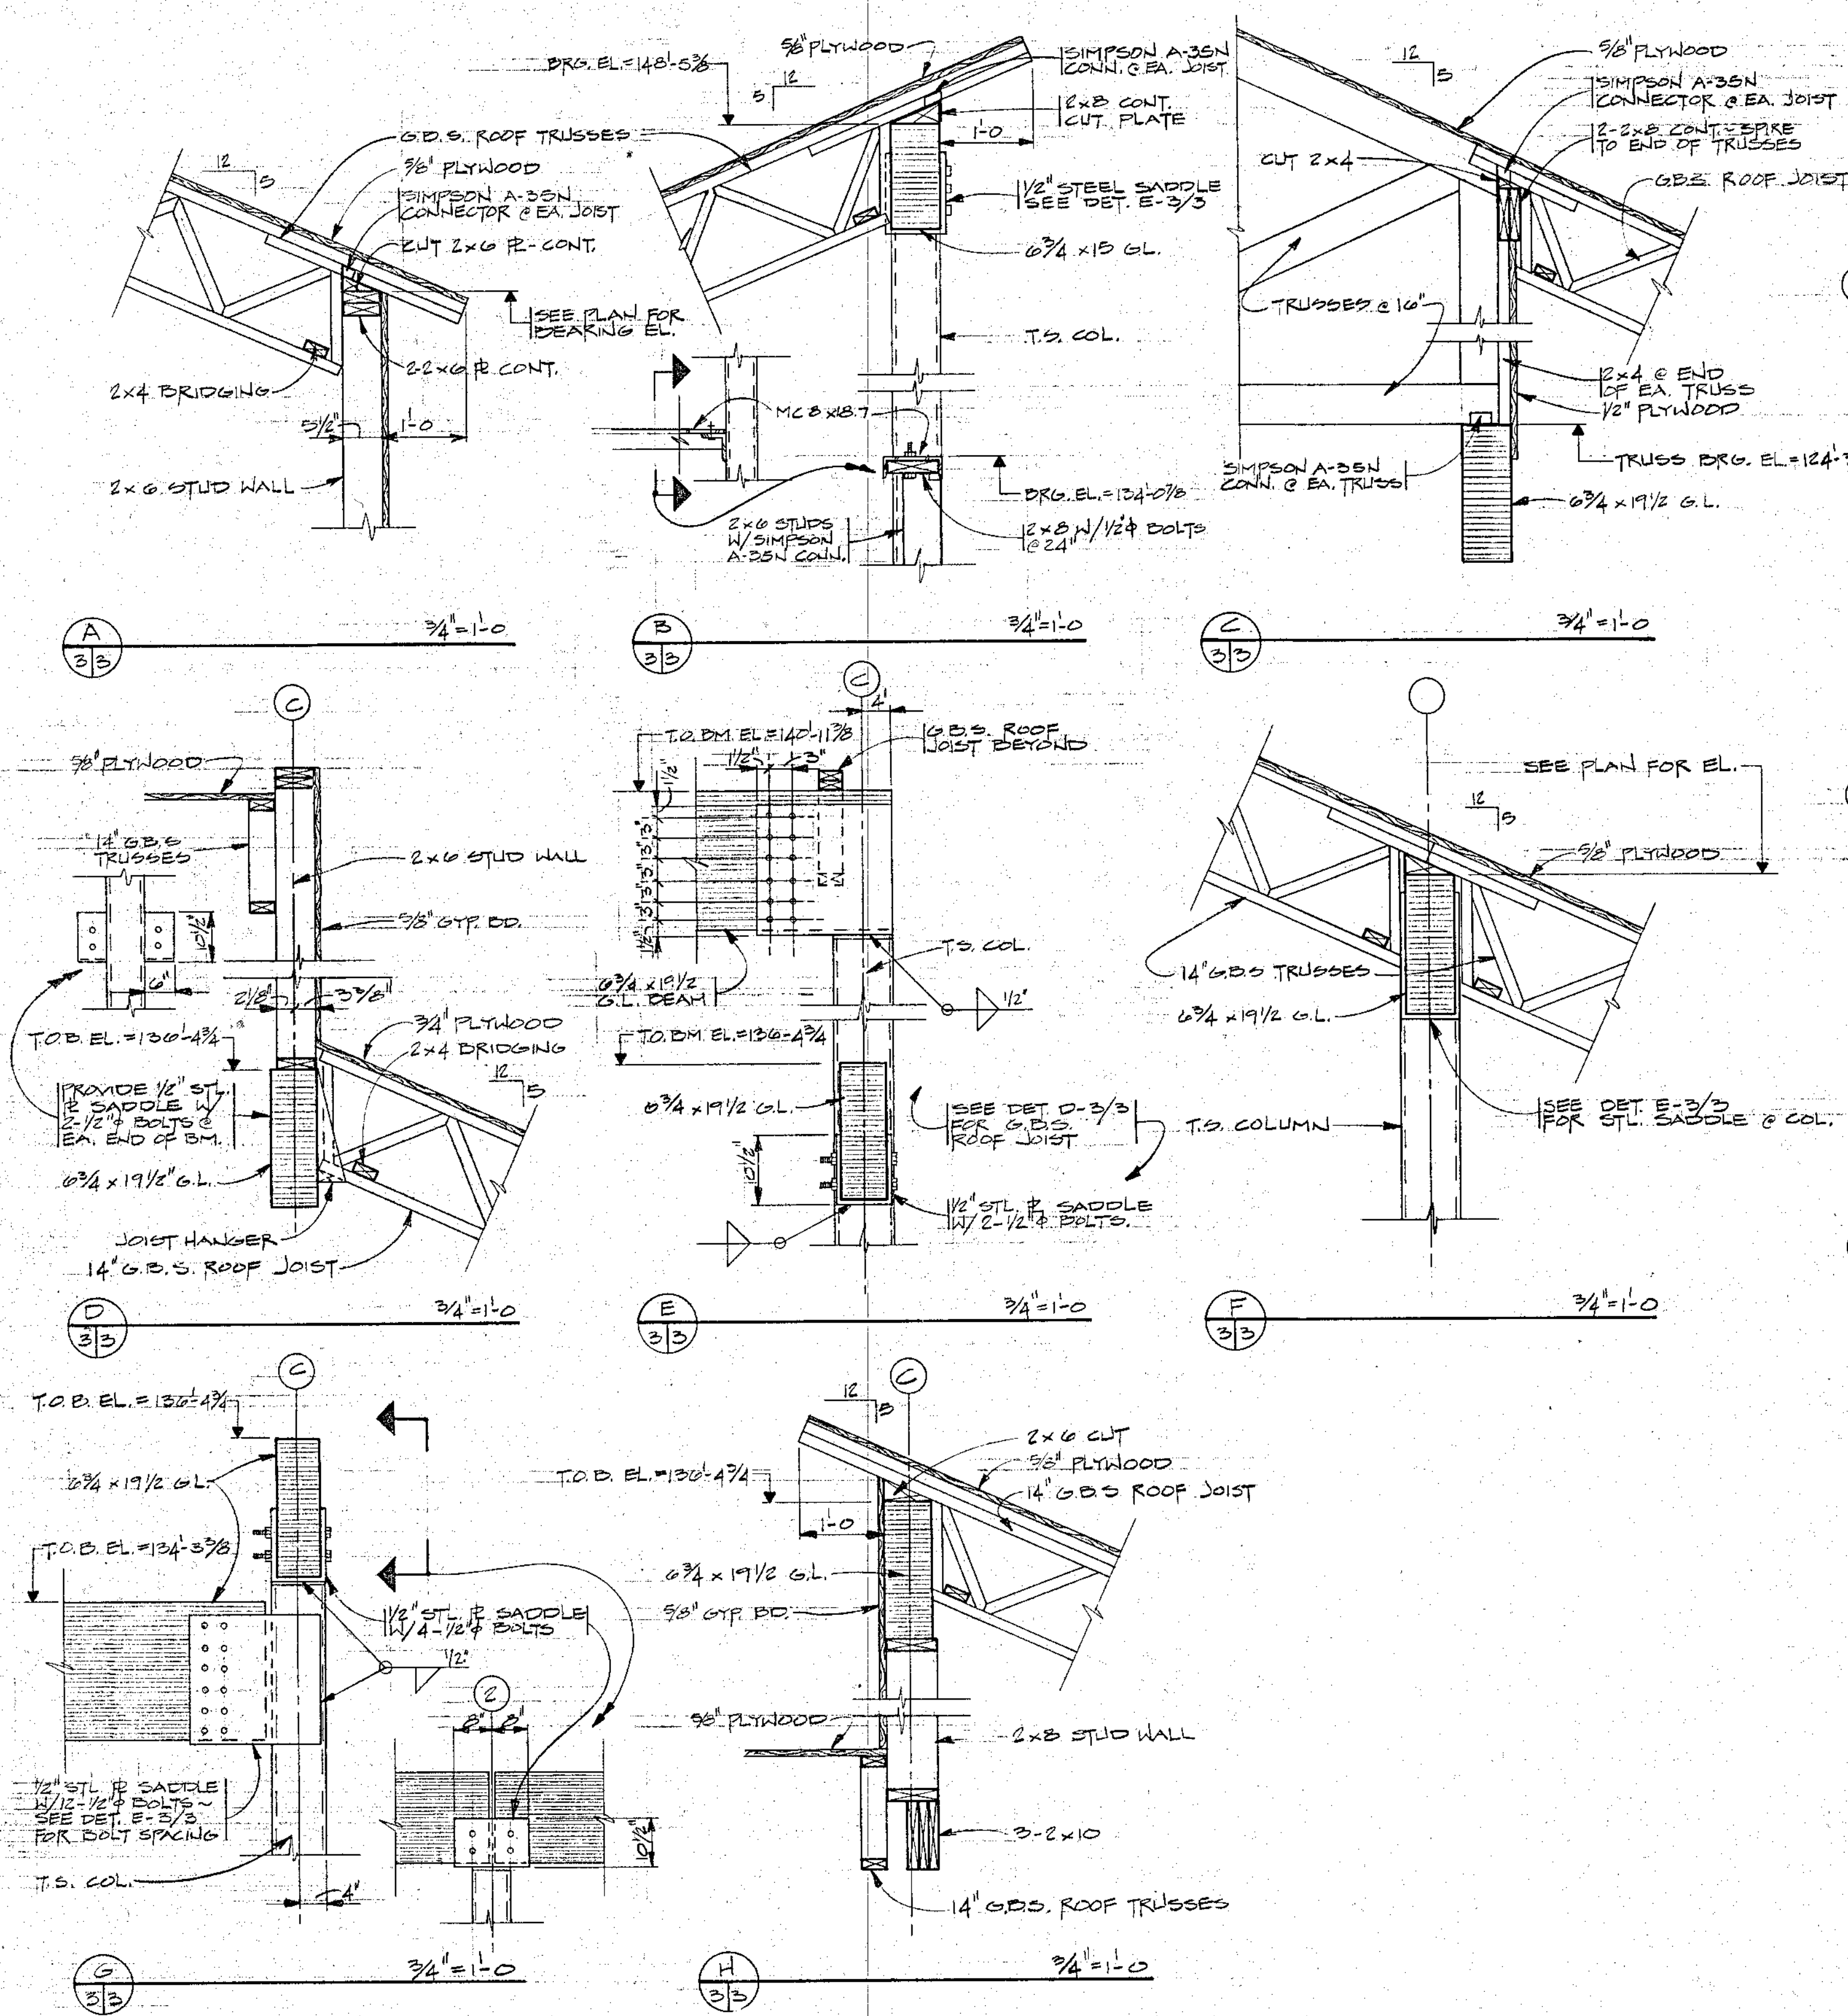

ROOF FRAMING PLAN 1/4" = 1'-0"

1. Provide Simpson A-35N Connector (or approved equal) at end of all joists and trusses.
2. GBS roof joists to be lumber grade 2400 F-2 OE or better.

SUNLIT DESIGN
ARCHITECTURE
BOX 877 CRESTED BUTTE, COLORADO 81224


DATE: 3-10-82
DRAWN BY: P. SORBER

REV'D. _____




G.B.F. 1213. FIRE STATION

ROOF FRAMING PLAN & DETAILS

53

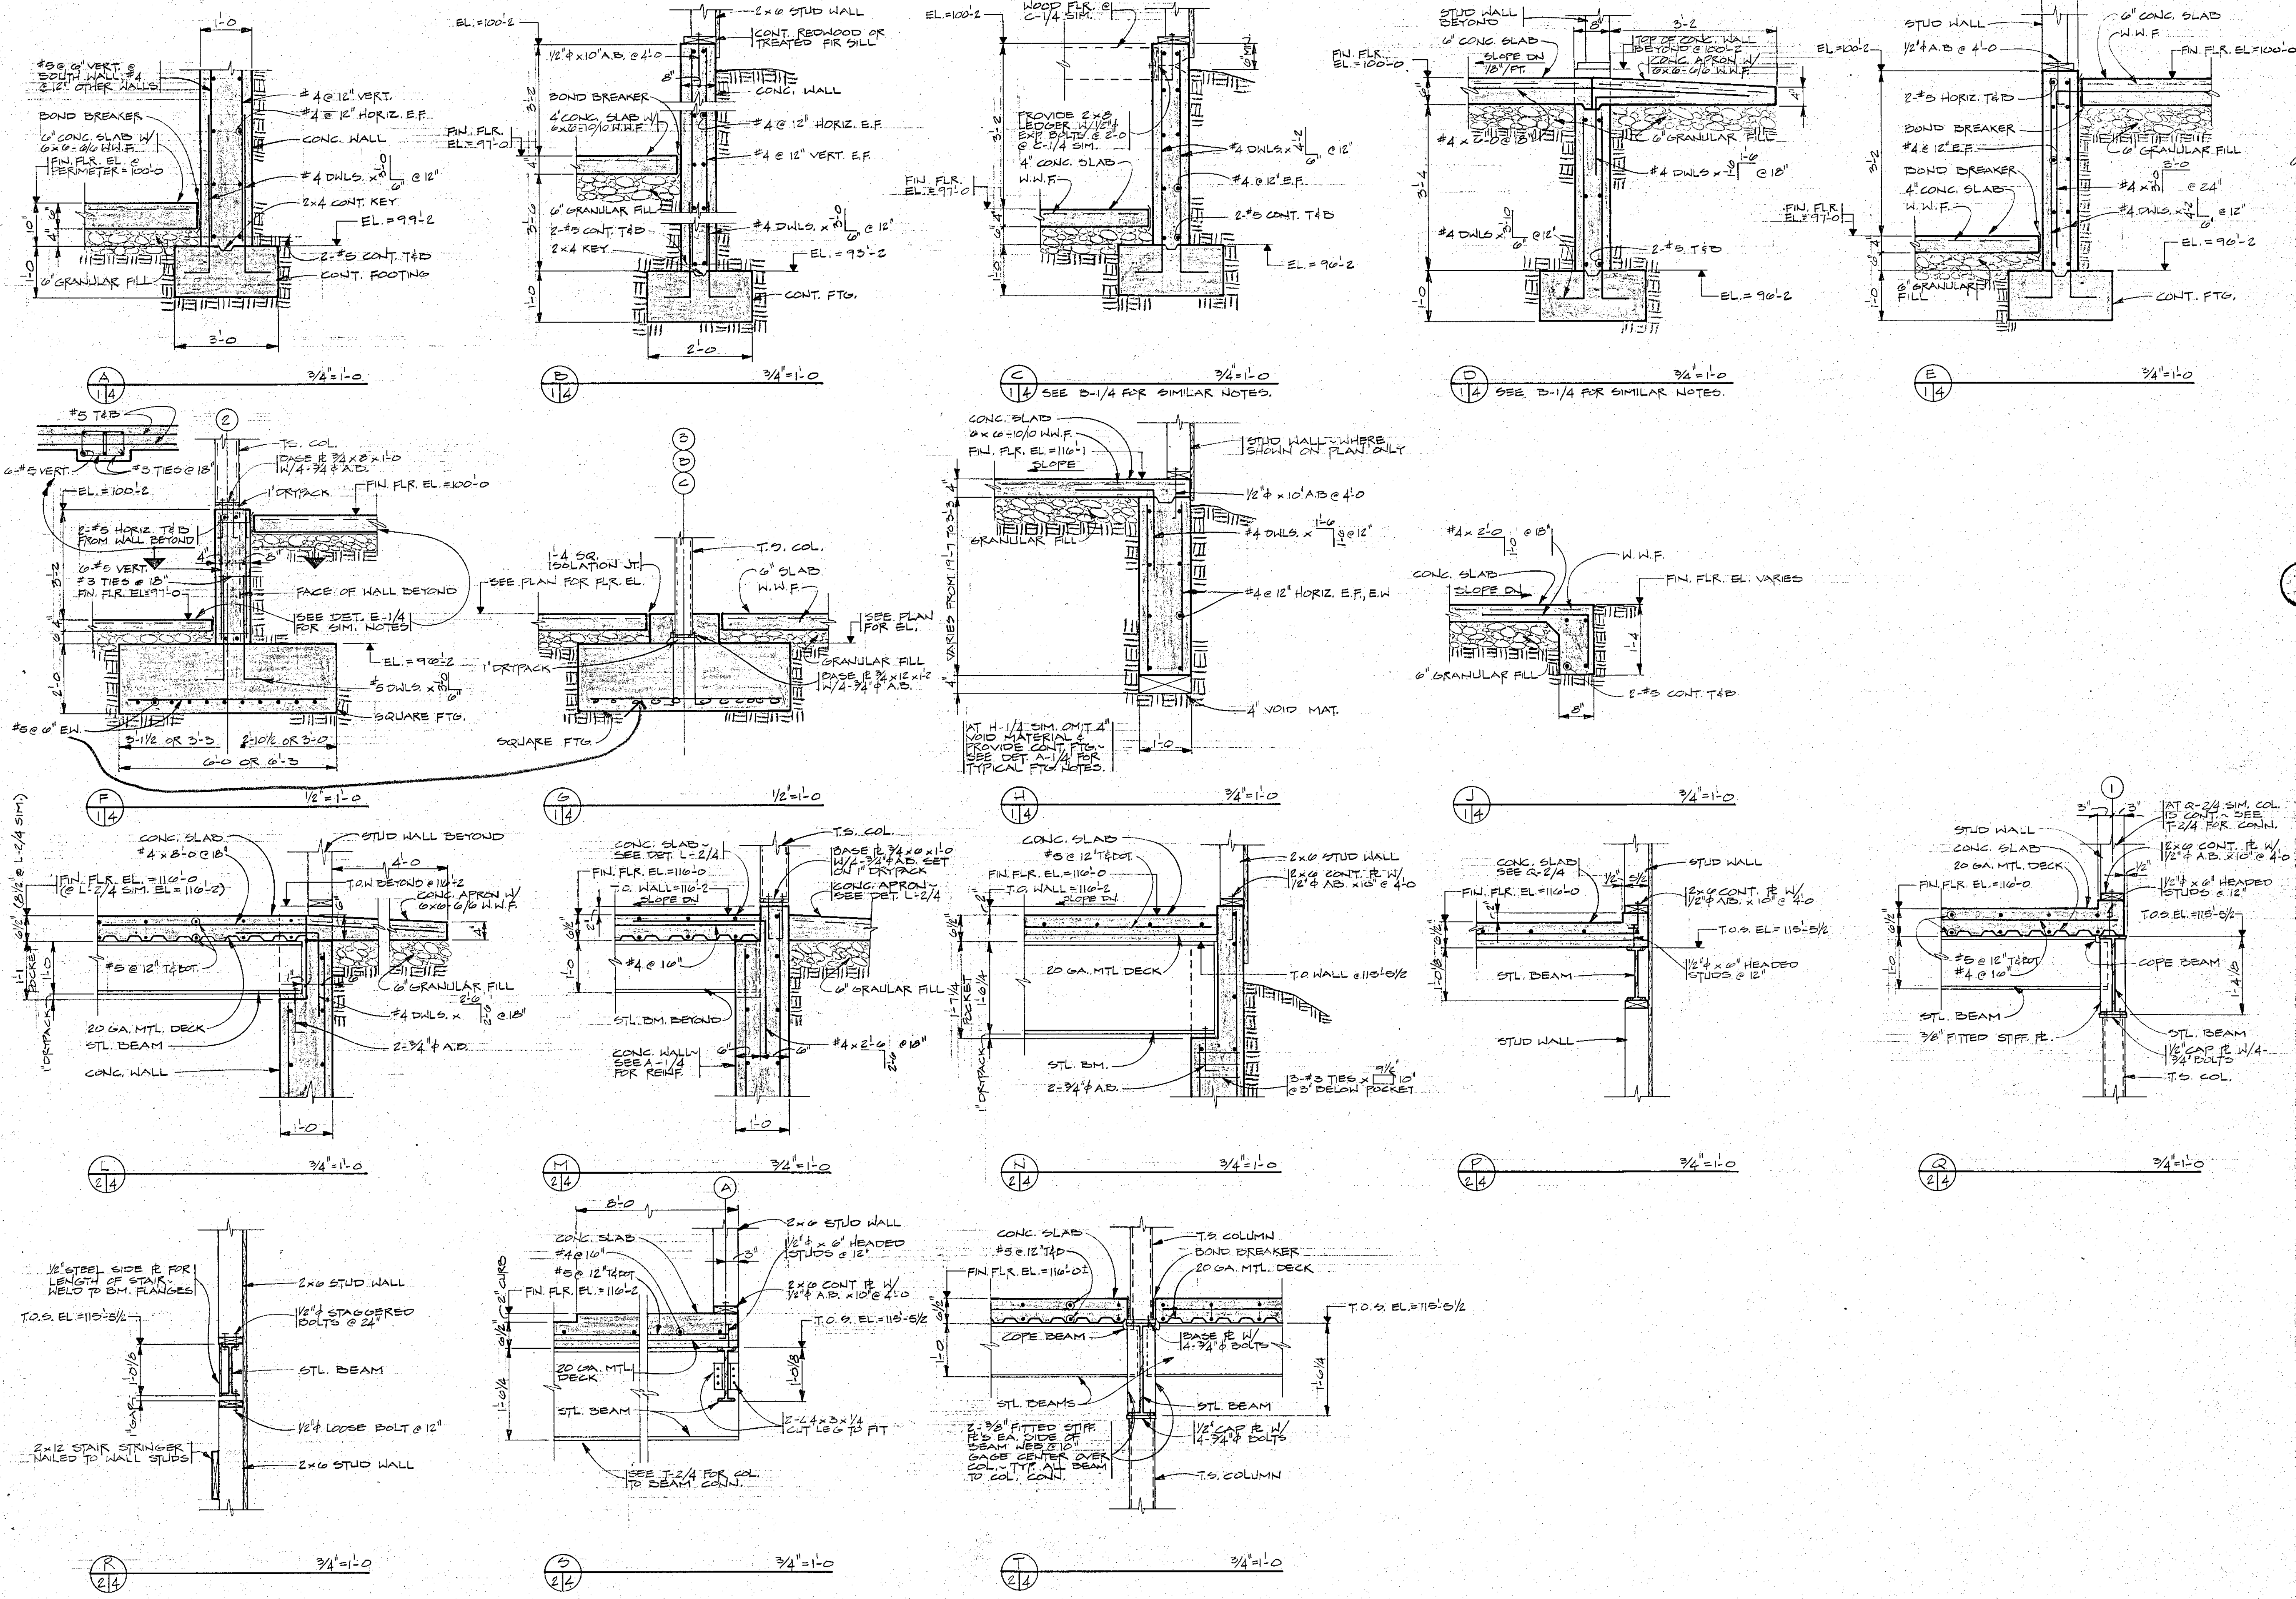


SUNLIT DESIGN ARCHITECTURE, ENGINEERING 800 277 CRESTED BUTTE COLORADO 81224	DATE: 3-10-82 DWN BY: P. BORDEN
	REV. NO. _____ REVISIONS: _____
C.B.F.P.D. FIRE STATION DETAILS	

 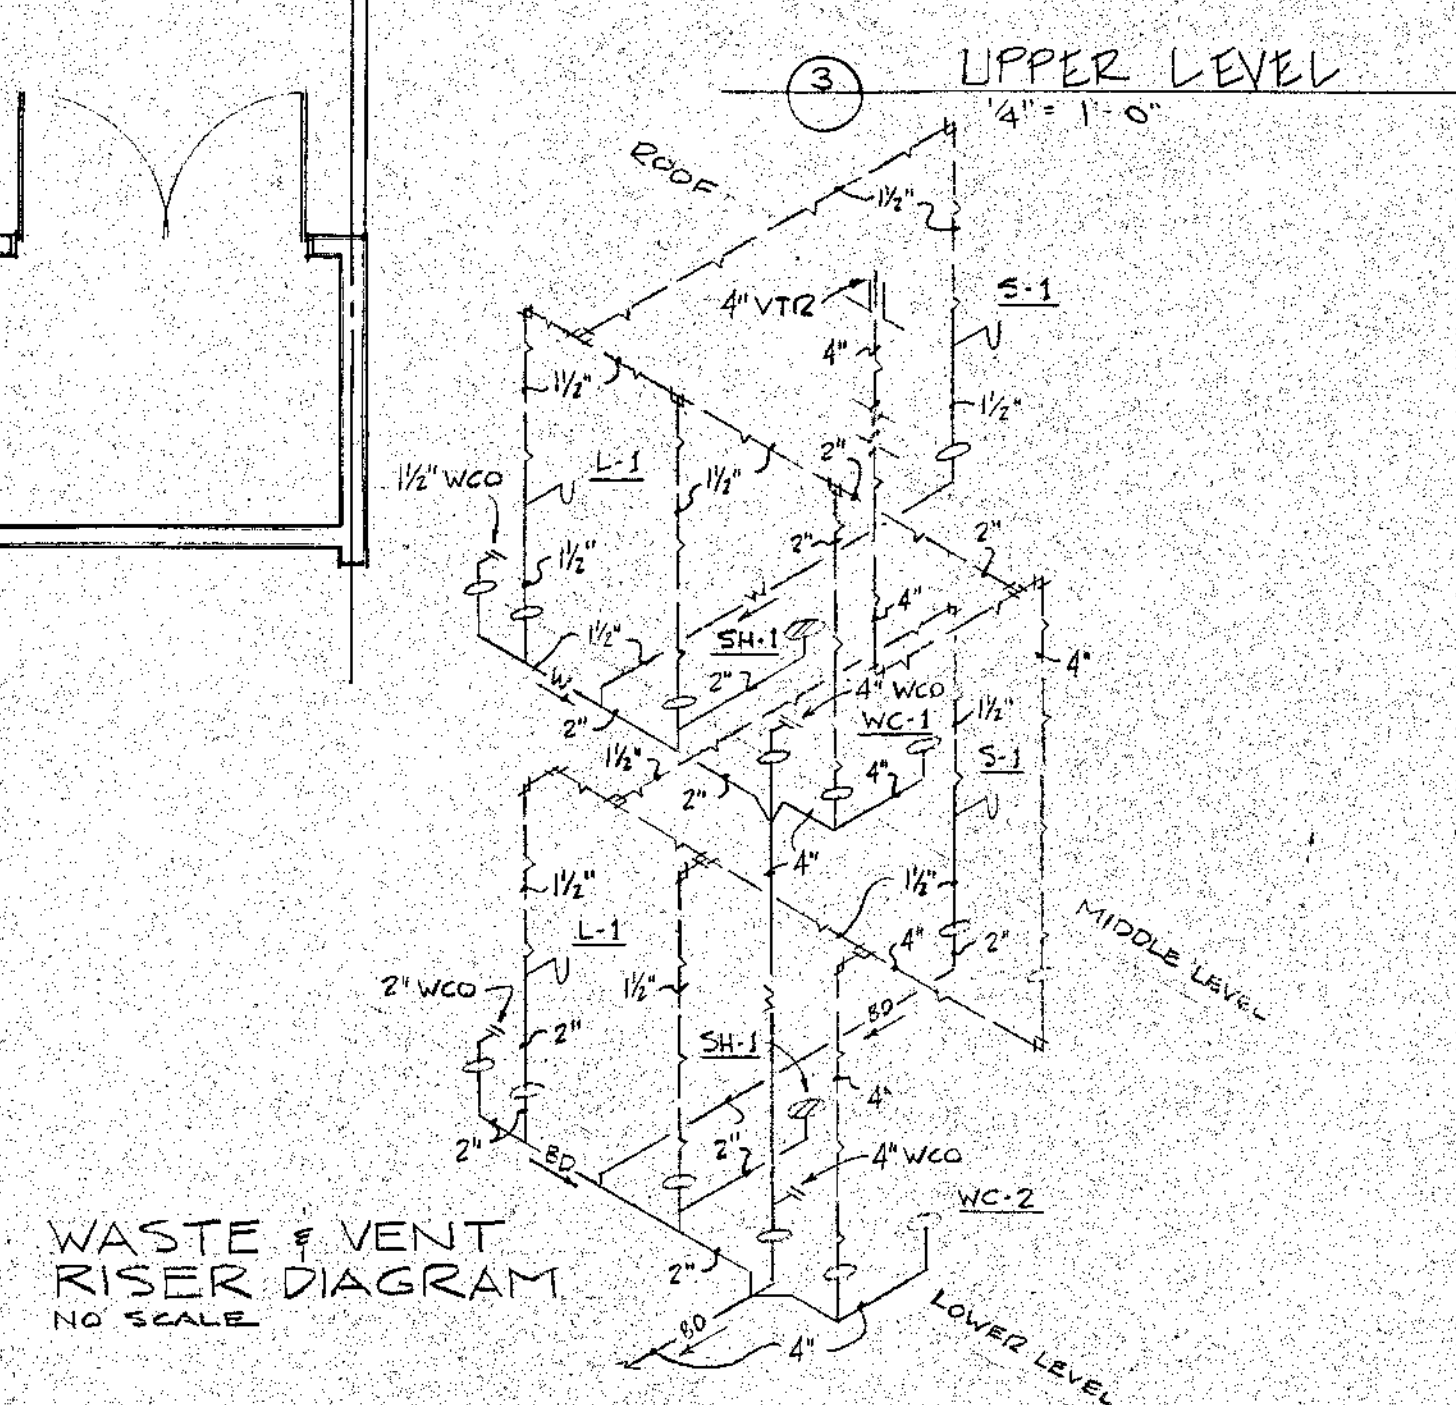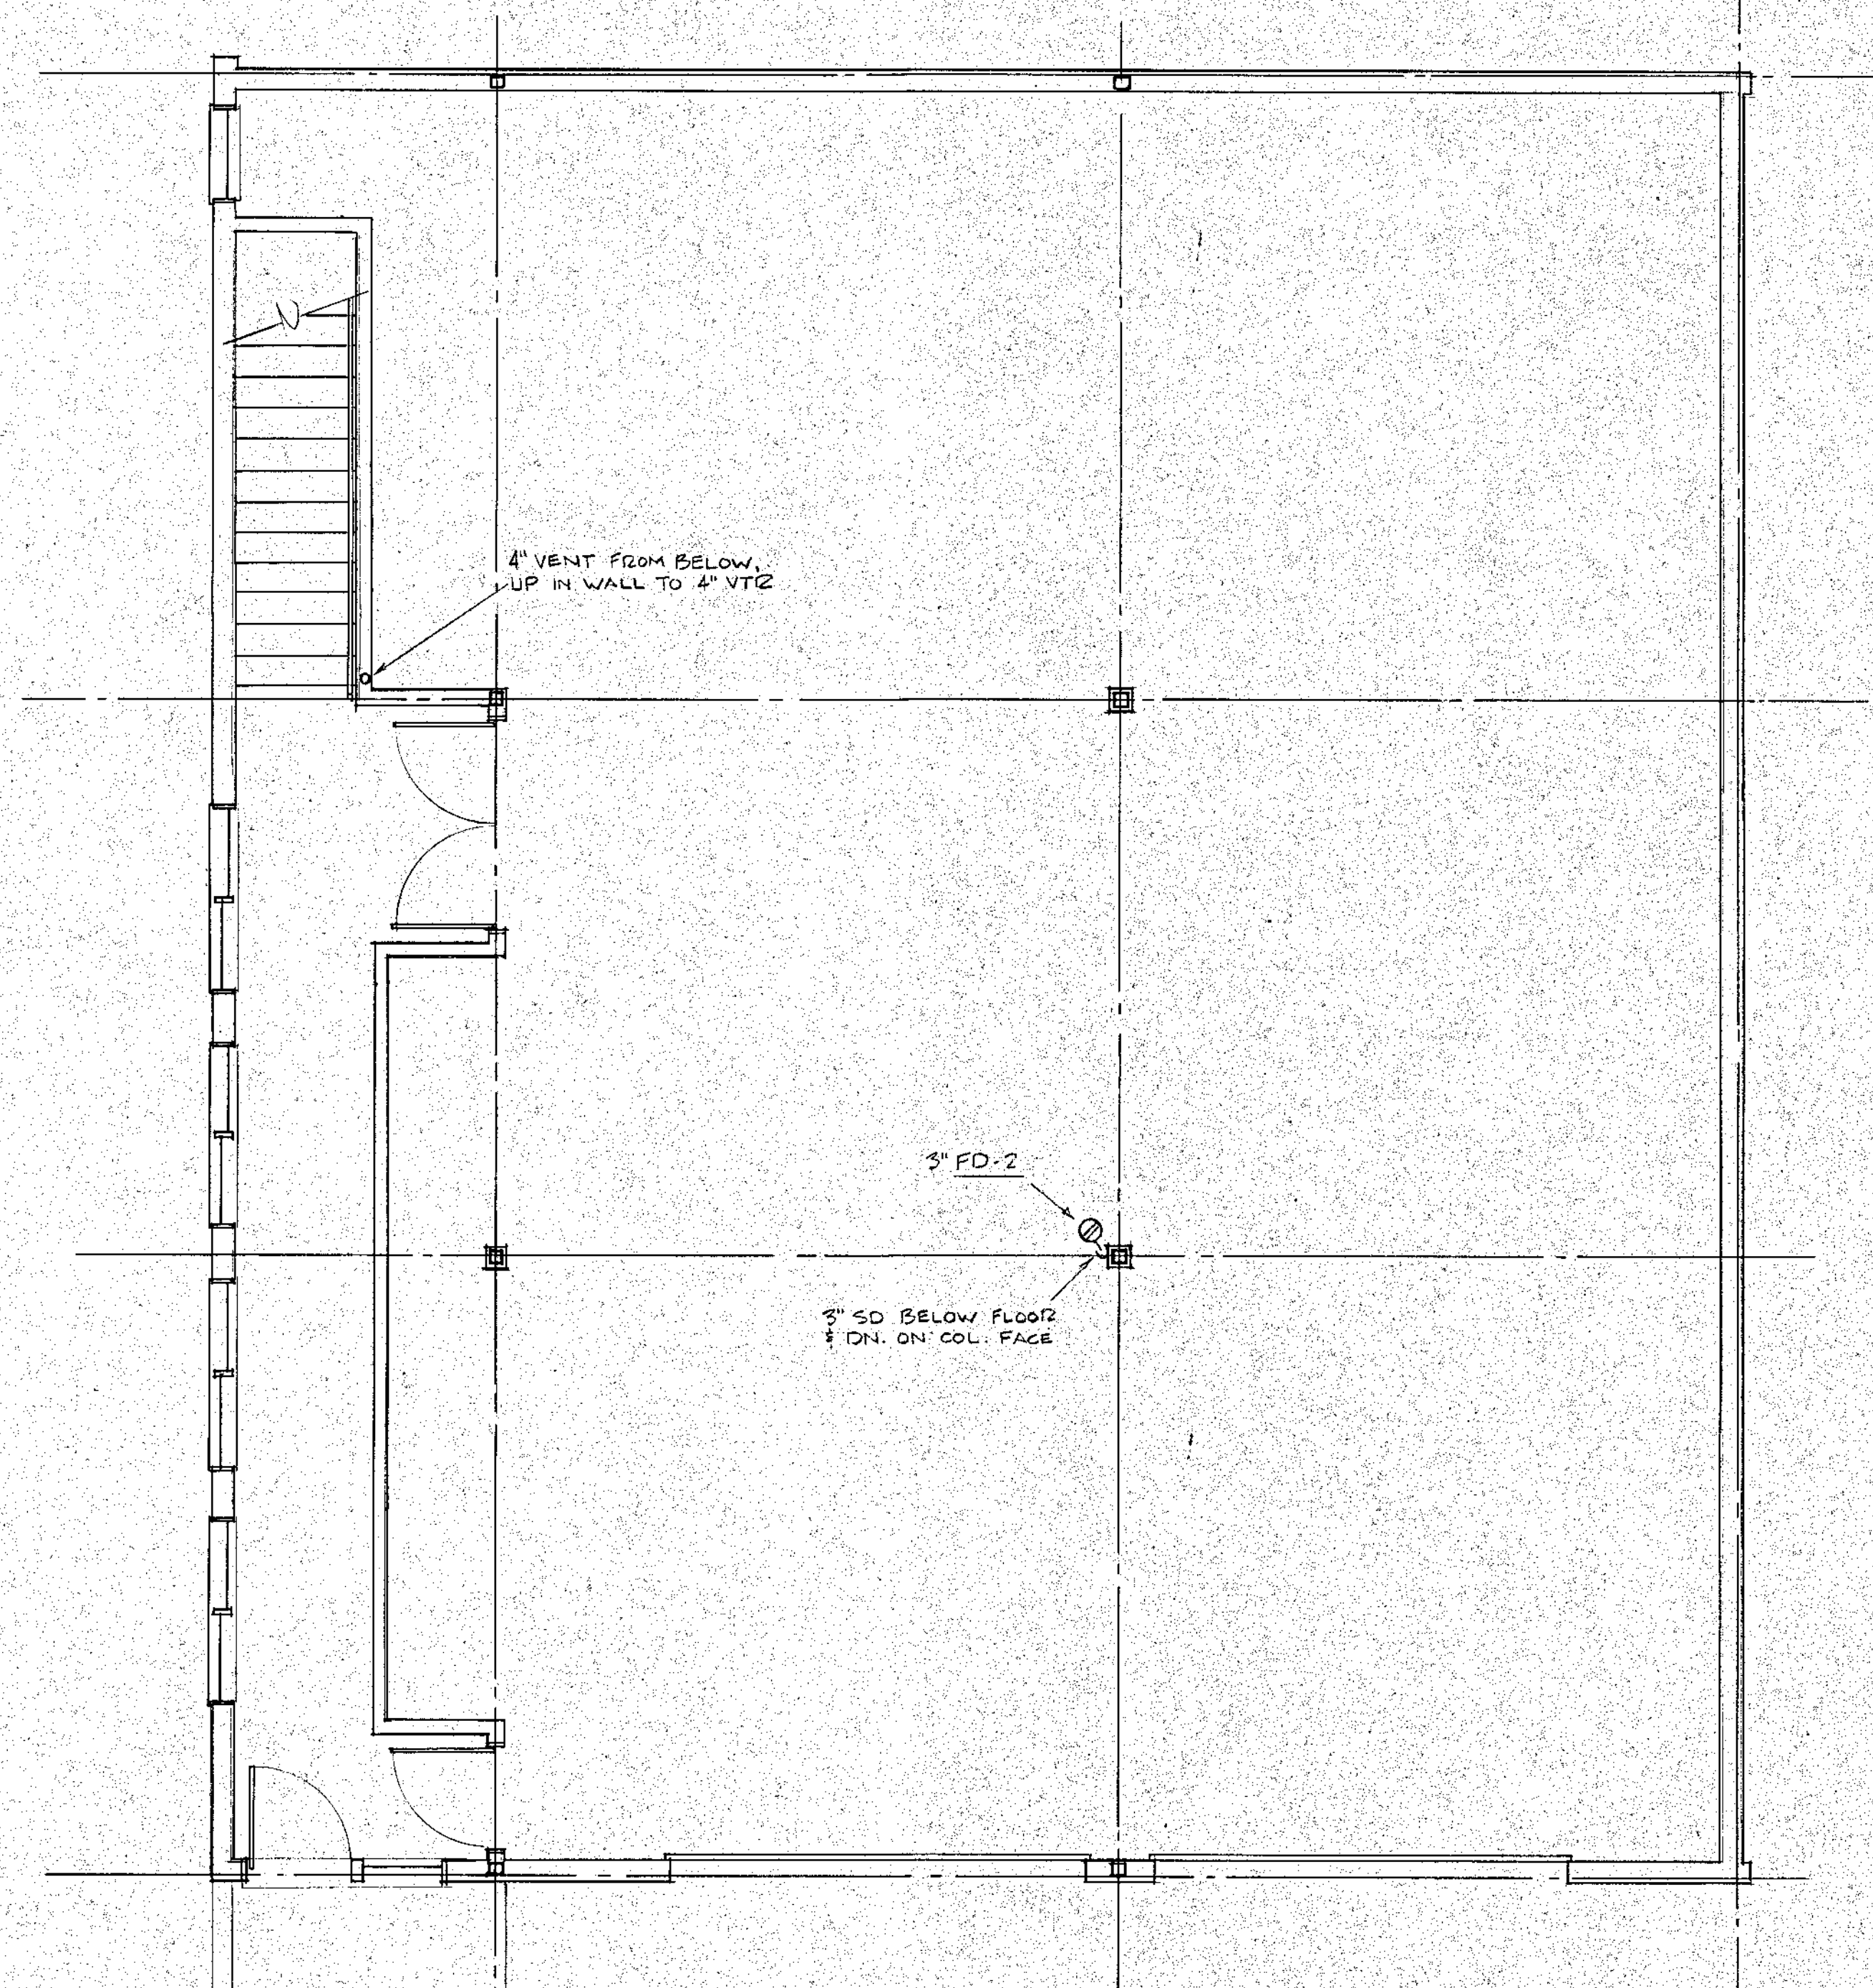


W	_____	WASTE PIPE ABOVE FLOOR
BD	_____	BLDG. DRAIN BELOW FLOOR
BS	_____	BLDG. SEWER BELOW GRADE
SD	_____	STORM DRAIN
_____	CW	DOM. COLD WATER
_____	HW	DOM. HOT WATER
_____	_____	PITCH PIPE IN DIRECTION SHOWN
_____	Y	VENT PIPING
VTR	_____	VENT THRU ROOF
CF	_____	COR. IRON
VCP	_____	VITRIFIED CLAY PIPE
WCO	_____	WALL CLEAN-OUT
FCD	_____	FLOOR CLEAN-OUT
SCO	_____	SURFACE CLEAN-OUT
FD	_____	FLOOR DRAIN
HB	_____	HOSE BIB
WH	_____	WALL HYDRANT

WASTE & VENT
RISER DIAGRAM
NO SCALE


DOM. WATER RISER DIAGRAM
NO SCALE

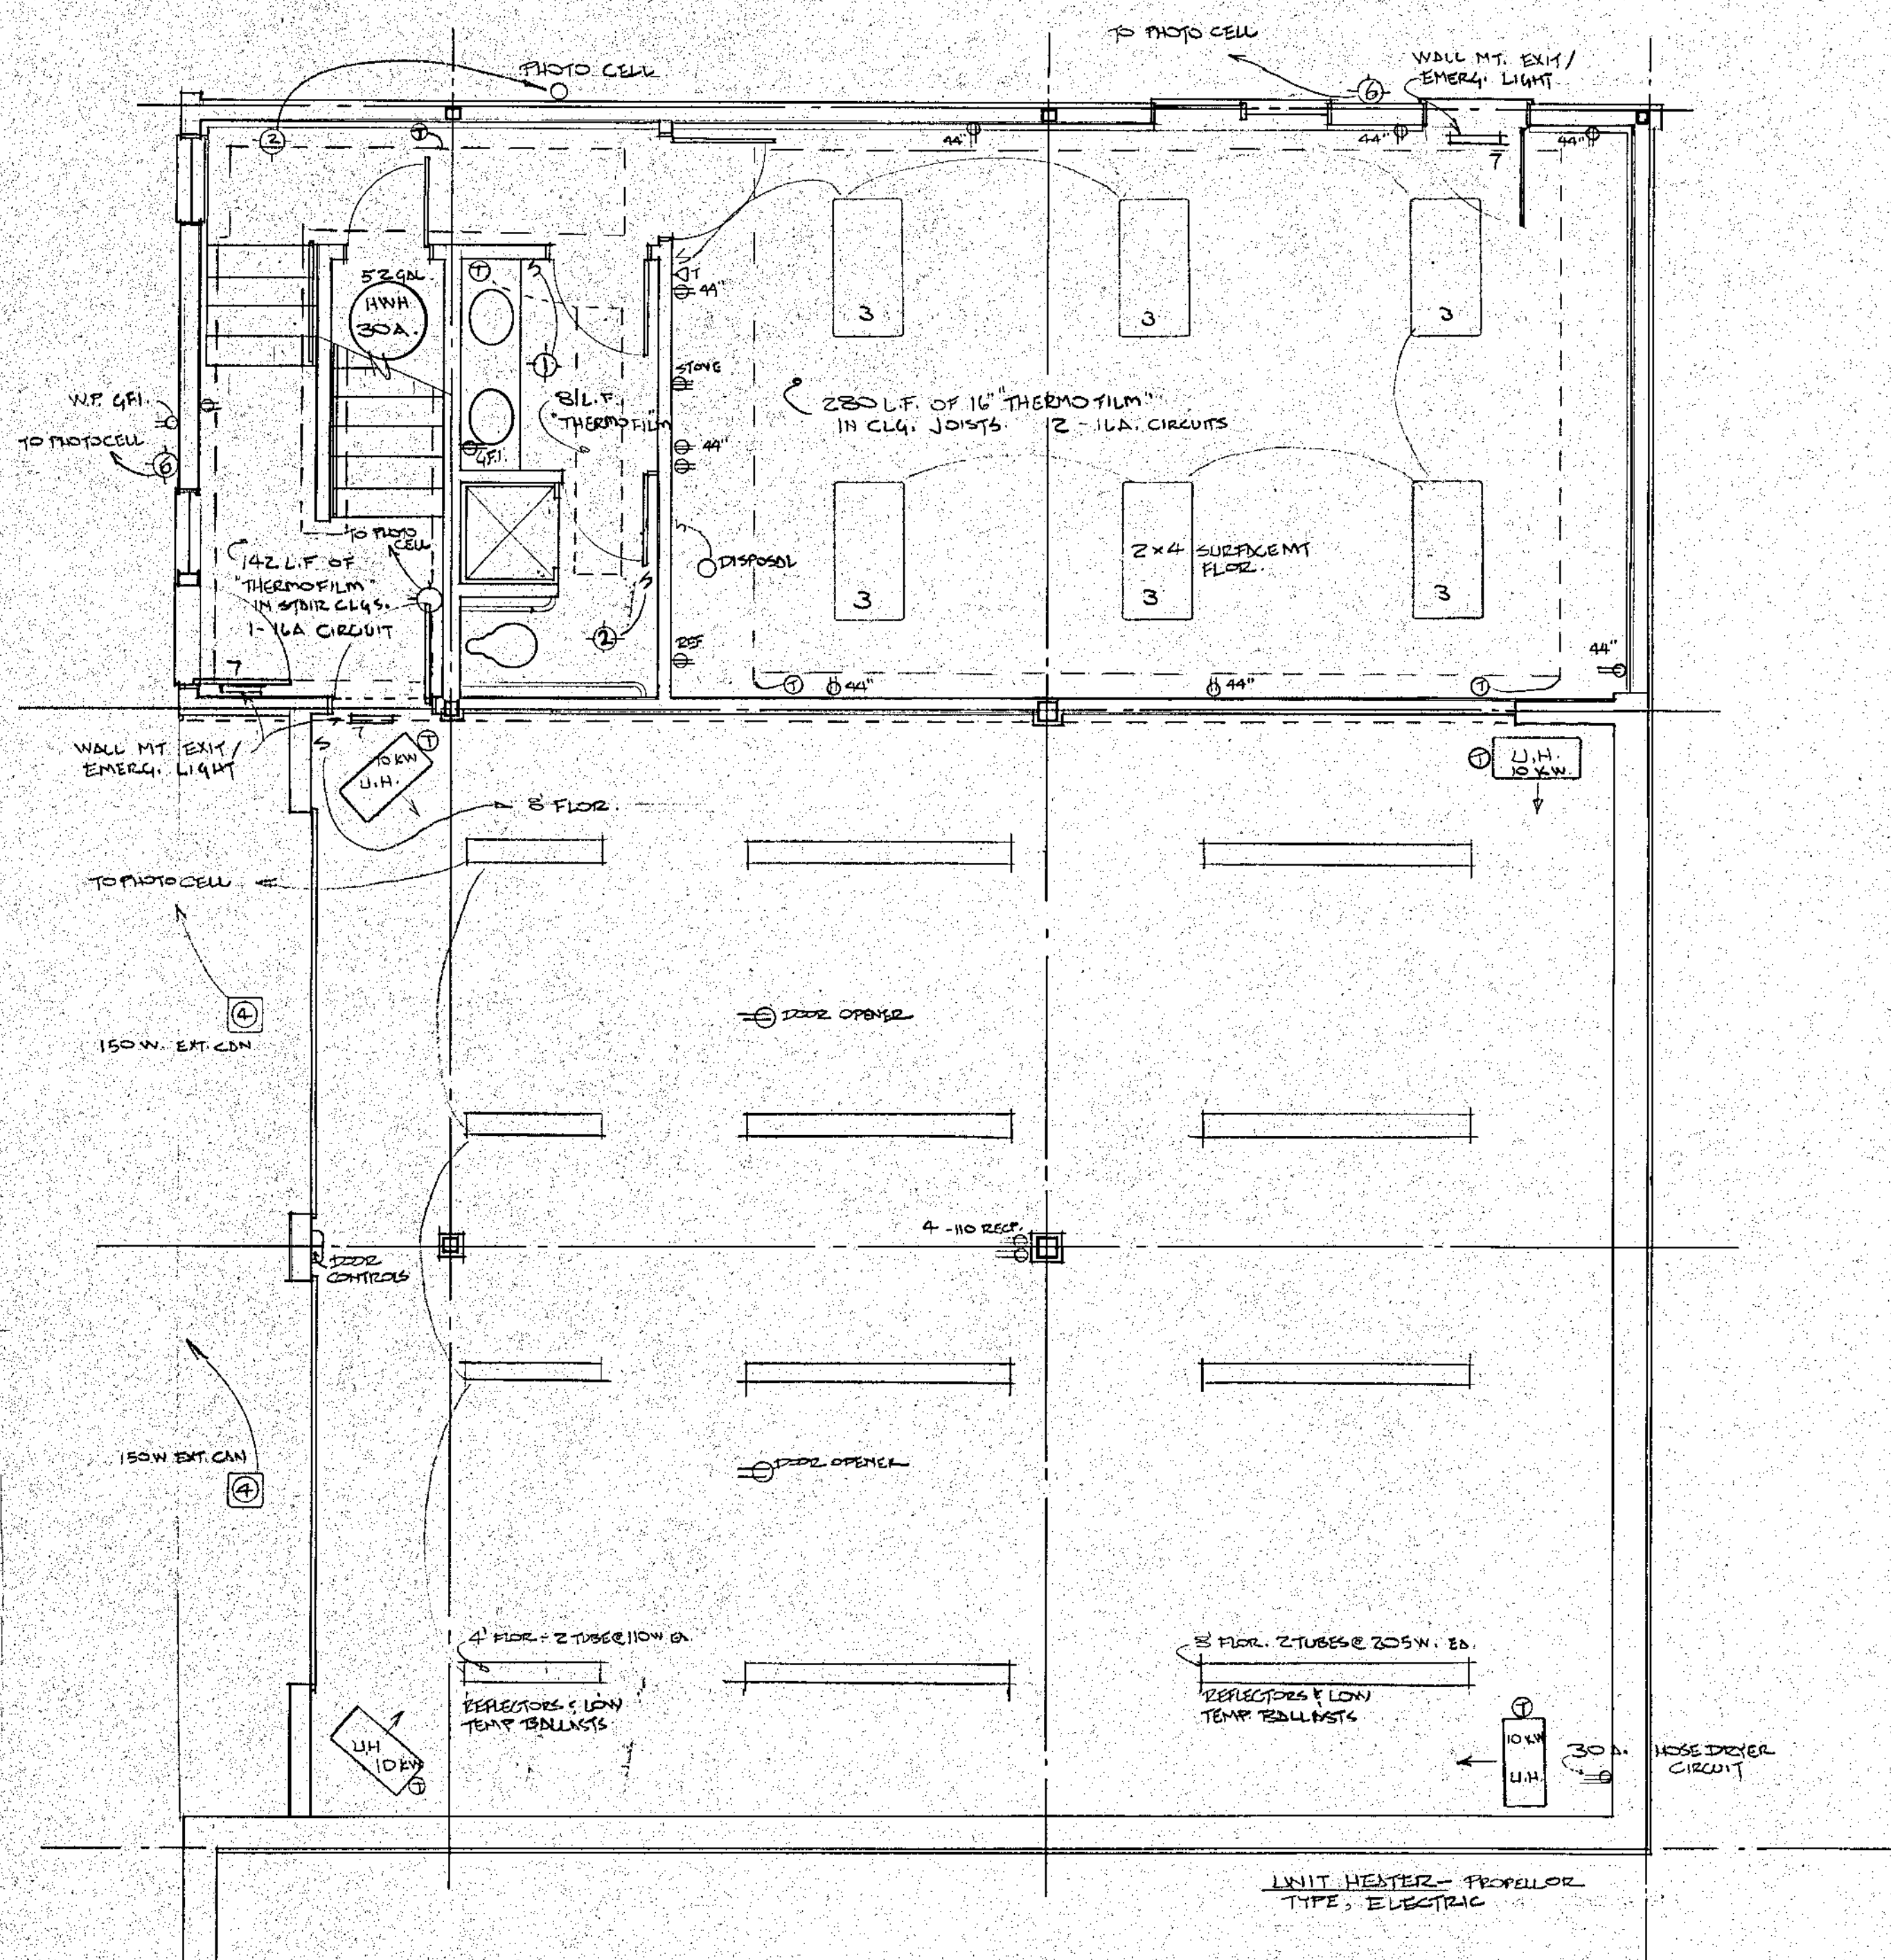

1 LOWER LEVEL
1/4" = 1'-0"

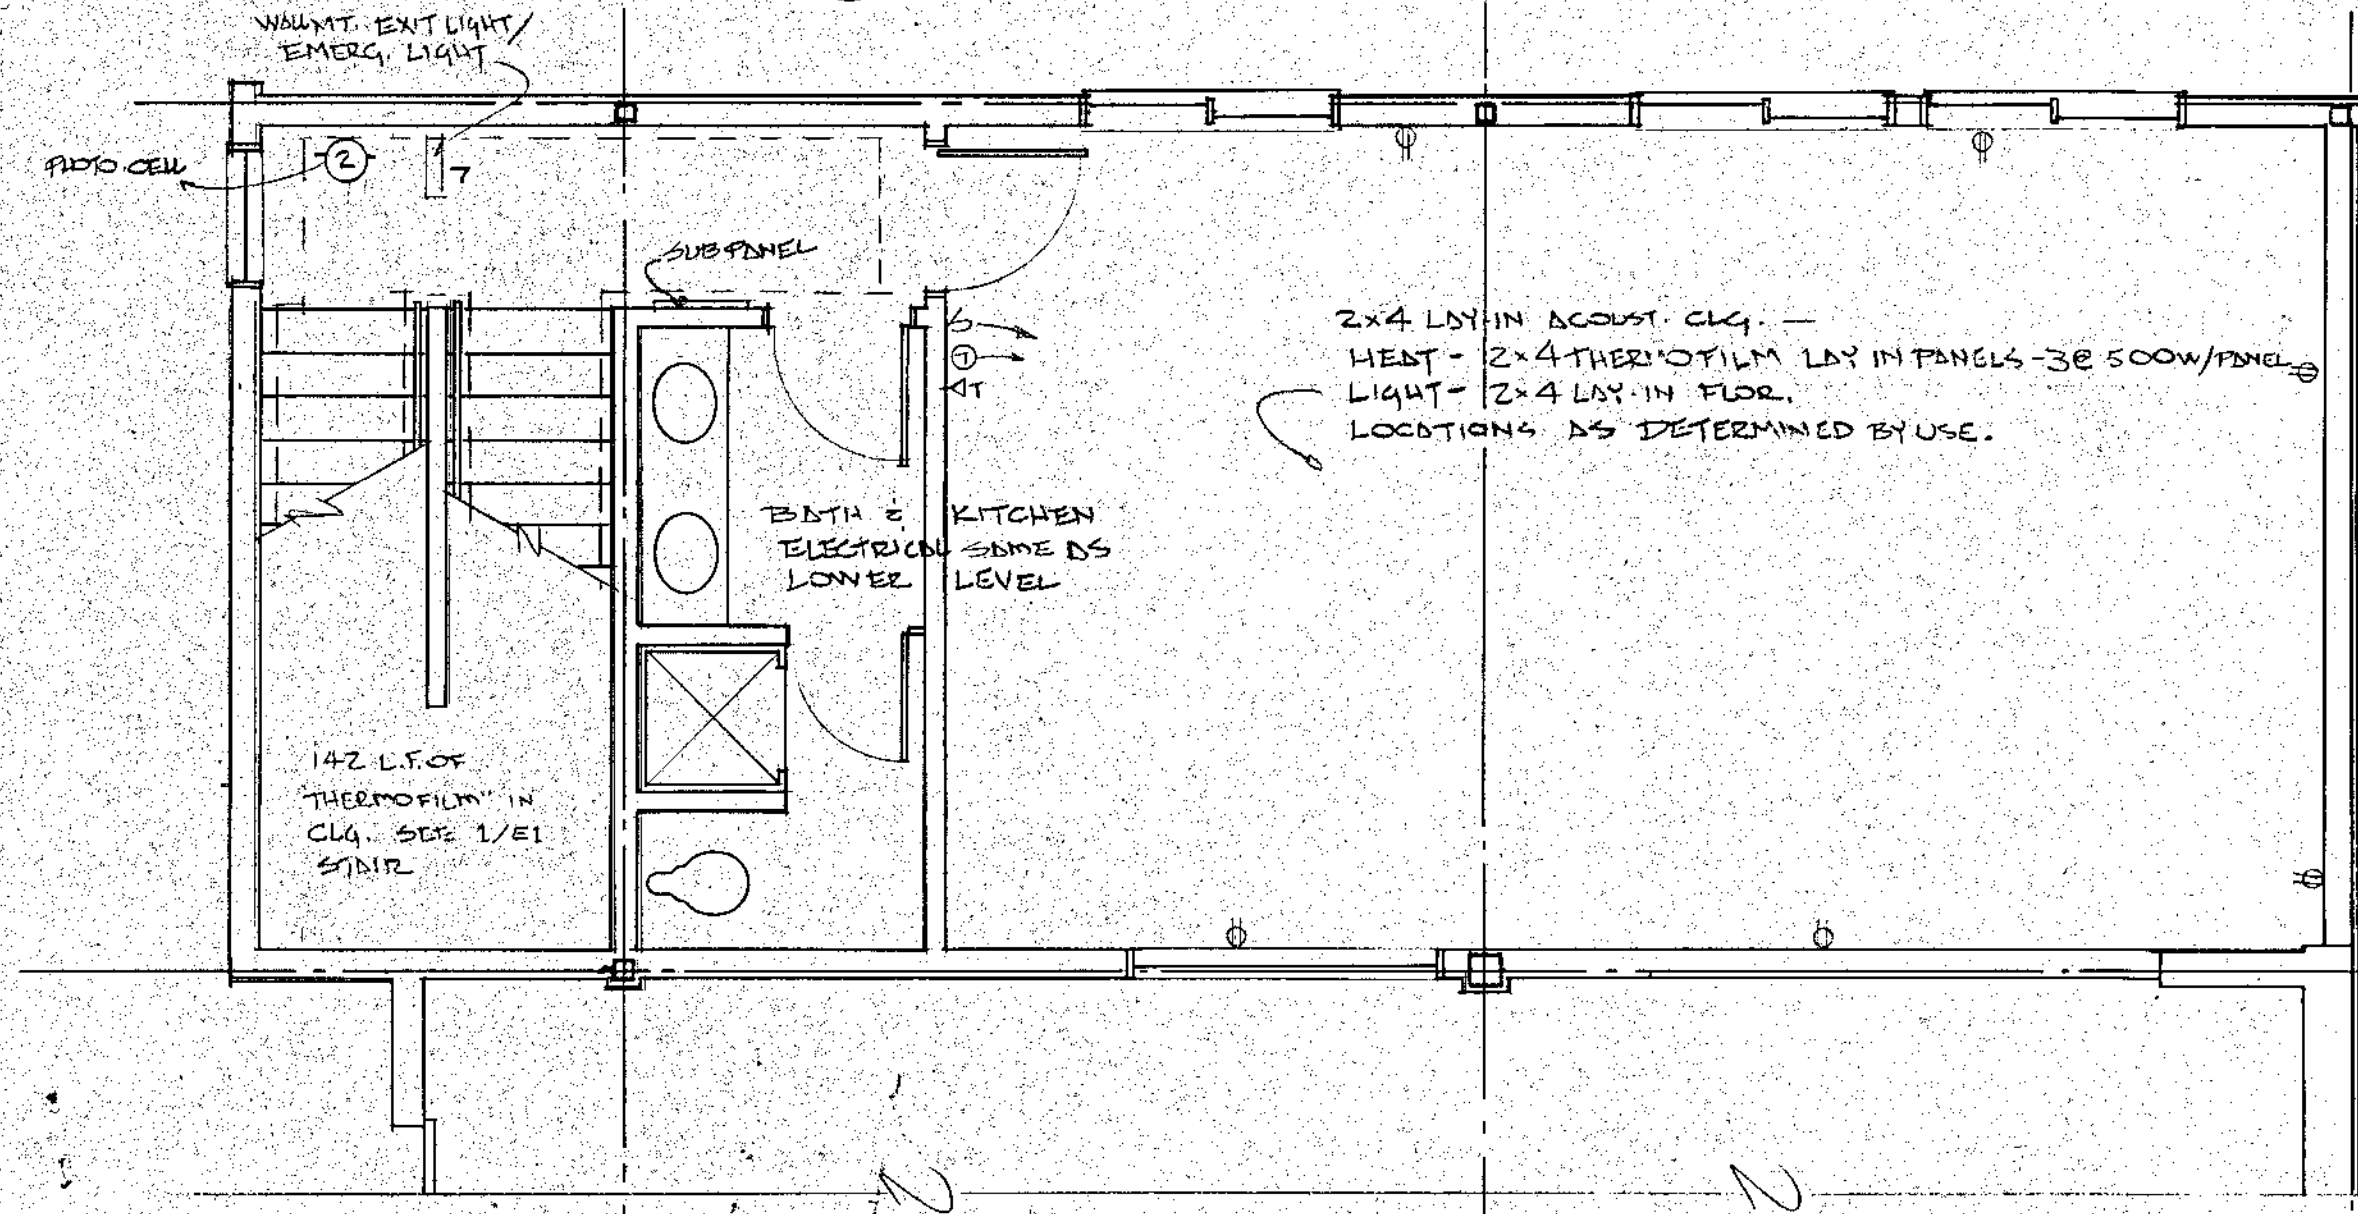

2 MIDDLE LEVEL
1/4" = 1'-0"

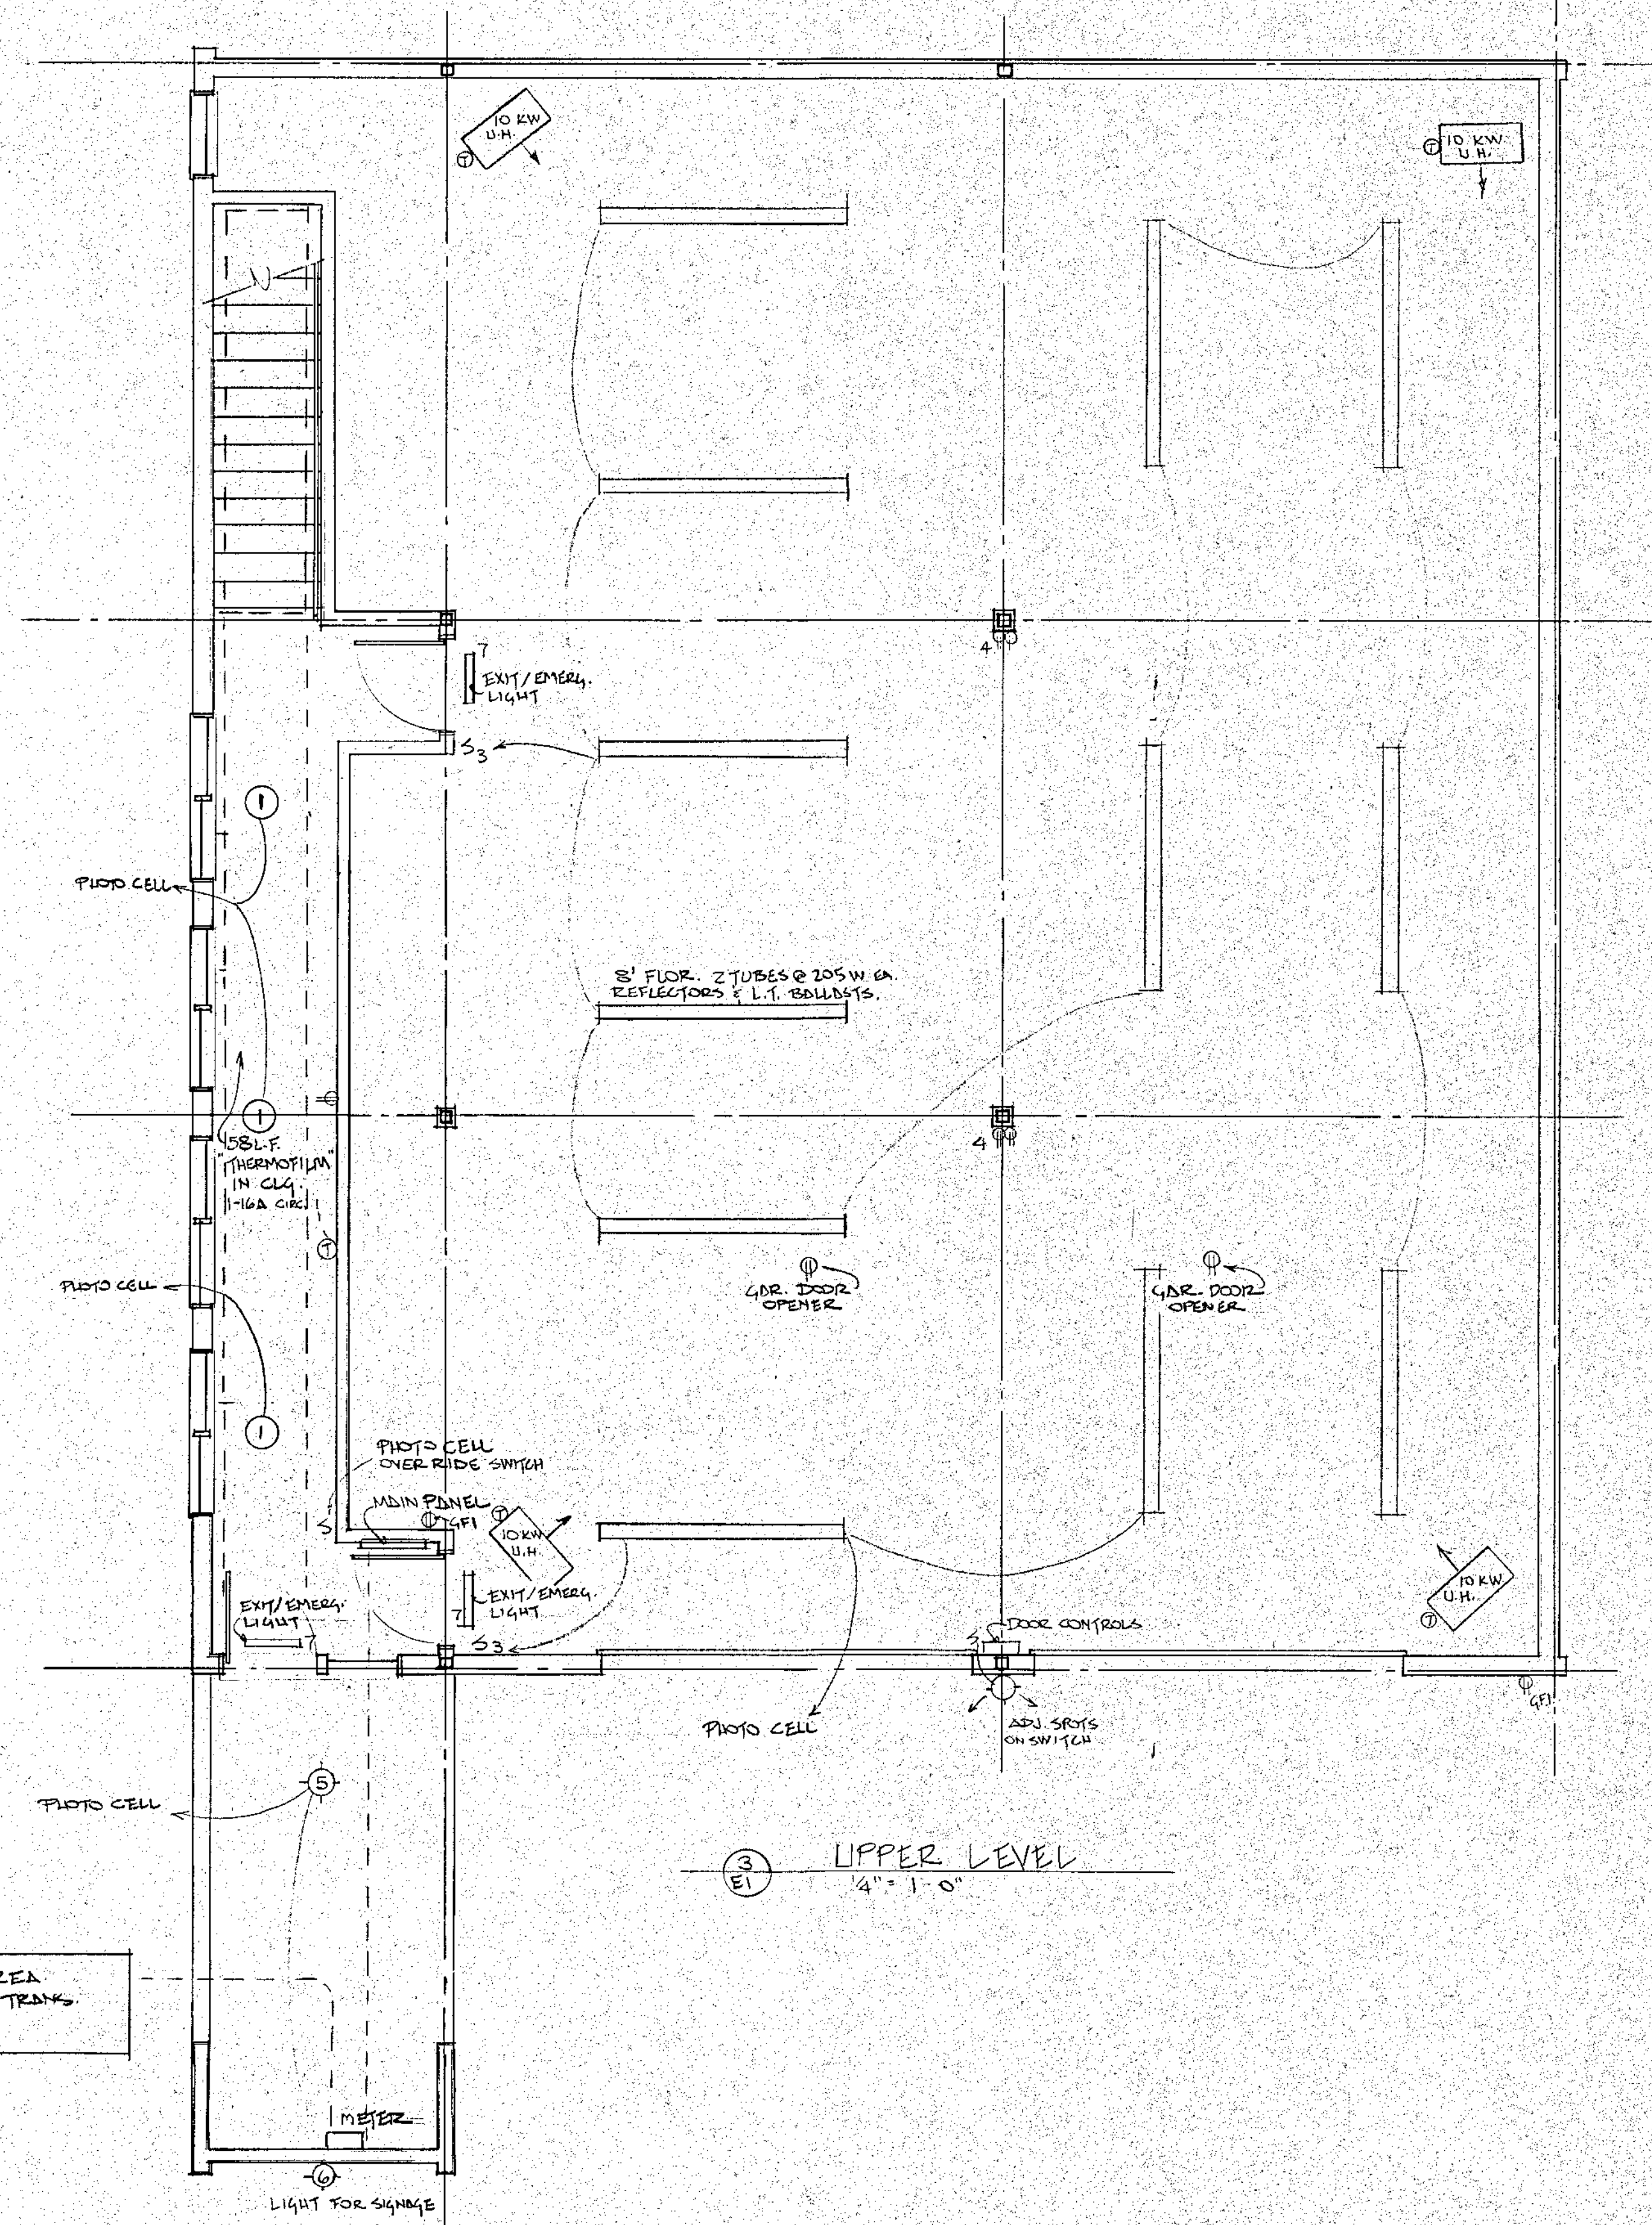

3 UPPER LEVEL
1/4" = 1'-0"

NOTE: ALL WIRING SHALL BE IN CONDUIT

LIGHT FIXTURE SCHEDULE (FOR FIXTURES NOT CALLED OUT ON PLANS)				
NO.	BRAND	MODEL	LAMP	REMARKS
1	LIGHTOLIER	OPALITE 6700	32 W CIRCUINE	
2	"	OPALITE 6700	22 W CIRCUINE	
3	"	LUMIFORM III 13535	4-40 W FLOR.	
4	PROGRESS	P-11 HOME/P 6094	150 W PAR 38	OR EQUIVALENT CURRENT MODEL
5	"	P 5707	60 W A-19	"
6	"	P 5657	60 W A-19	"
7	"	P 6023 WB or P 6024 WB	2-20 W T6 2-30 W T6 4-40 W T6	"